




- APPROVAL STAMP:
- NOTES:
- 1.) ALL DIMENSIONS TO BE VERIFIED BY CONTRACTOR ON SITE PRIOR TO COMMENCEMENT OF ANY WORK.
 - 2.) DO NOT SCALE THIS DRAWING FOR THE PURPOSE OF MEASUREMENT. ONLY SCALE DIMENSIONS WHERE SPECIFICALLY INSTRUCTED TO DO SO.
 - 3.) ALL MEASUREMENTS ARE IN MILLIMETERS UNLESS OTHERWISE SPECIFIED.
 - 4.) DIMENSIONS SHOWN ON THESE DRAWINGS ARE STRUCTURAL DIMENSIONS UNLESS CLEARLY NOTED OTHERWISE.
 - 5.) THIS DRAWING IS TO BE READ IN CONJUNCTION WITH ALL OTHER DRAWINGS, DETAIL AND SPECIFICATIONS. ANY DISCREPANCY TO BE IMMEDIATELY BROUGHT TO THE ATTENTION OF ARCHITECT PRIOR TO COMMENCING THE WORKS.

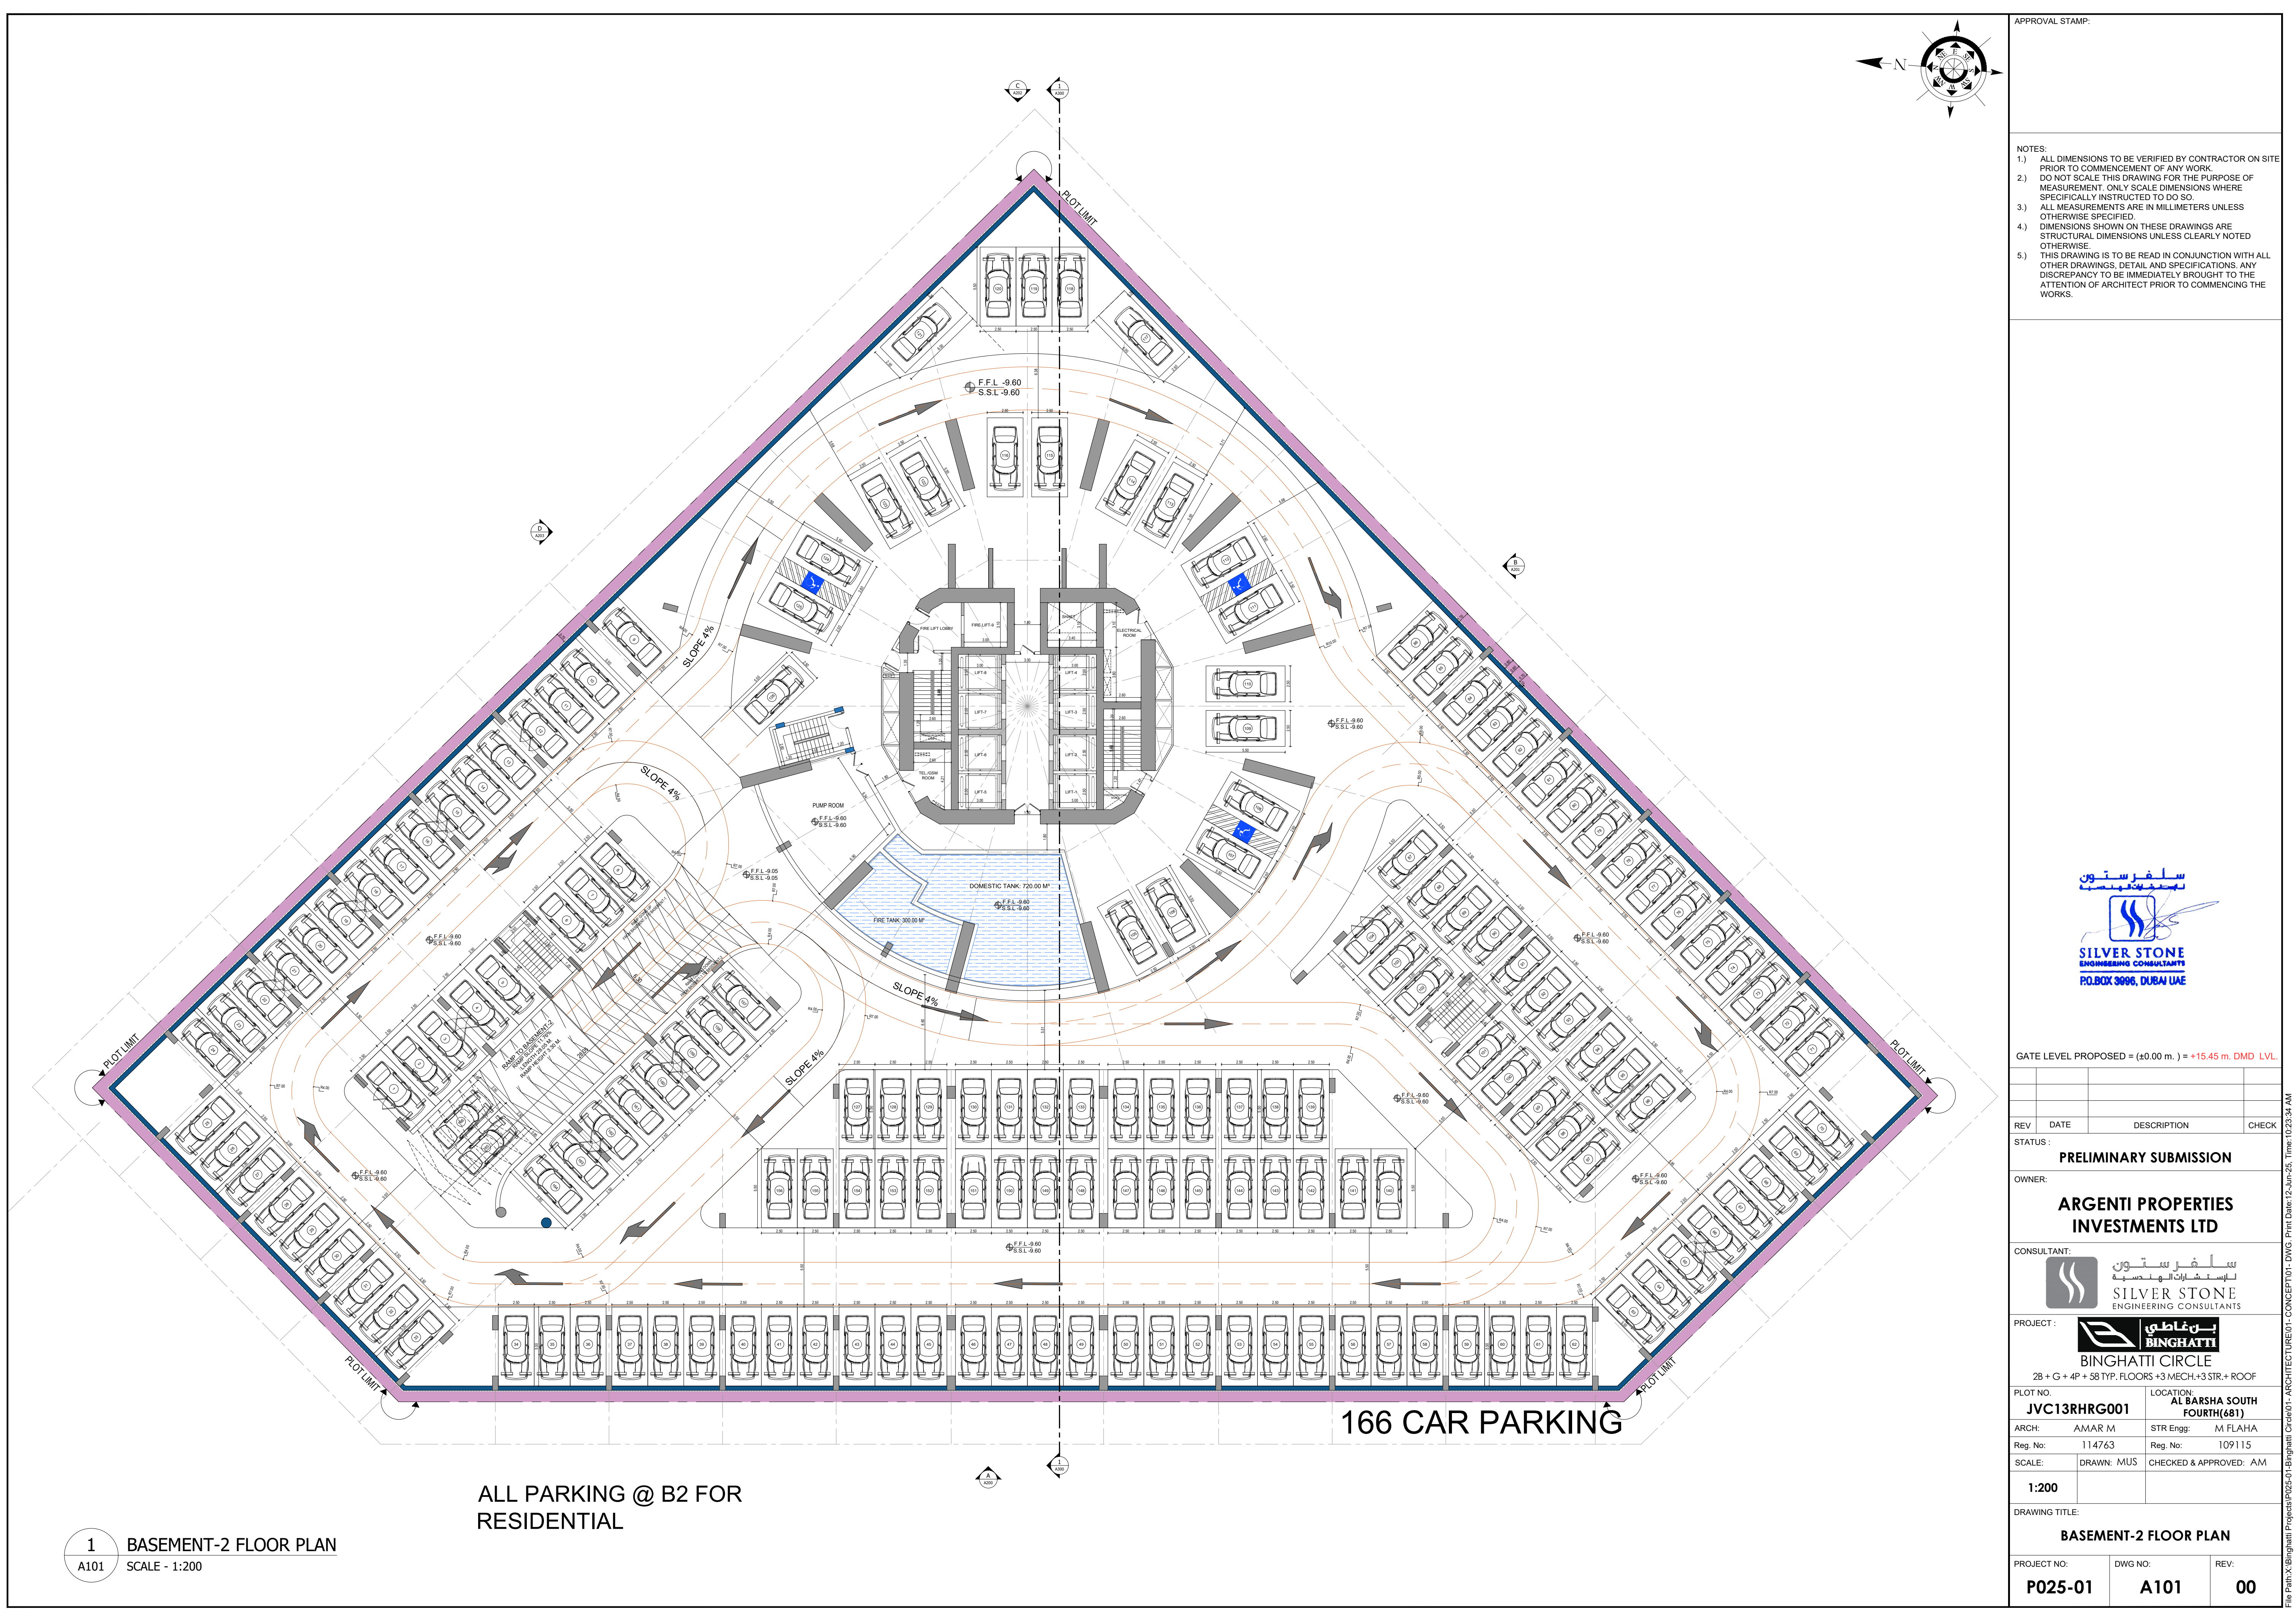

GATE LEVEL PROPOSED = (±0.00 m.) = +15.45 m. DMD LVL.

REV	DATE	DESCRIPTION	CHECK
STATUS:			
PRELIMINARY SUBMISSION			
OWNER:			
ARGENTI PROPERTIES INVESTMENTS LTD			
CONSULTANT:			
SILVER STONE ENGINEERING CONSULTANTS			
PROJECT:			
BINGHATTI CIRCLE			
2B + G + 4P + S8 TYP. FLOORS +3 MECH.+3 STR.+ ROOF			
PLOT NO:		LOCATION:	
JVC13RHRG001		AL BARSHA SOUTH FOURTH(681)	
ARCH:		STR Engg:	
AMAR M		M FLAHA	
Reg. No:		Reg. No:	
114763		109115	
SCALE:		DRAWN: MUS	
1:200		CHECKED & APPROVED: AM	
DRAWING TITLE:			
BASEMENT-2 FLOOR PLAN			
PROJECT NO:		DWG NO:	
P025-01		A101	
		REV:	
		00	

PRELIMINARY SUBMISSION

OWNER:

ARGENTI PROPERTIES INVESTMENTS LTD

CONSULTANT:

SILVER STONE ENGINEERING CONSULTANTS

PROJECT:

BINGHATTI CIRCLE

2B + G + 4P + S8 TYP. FLOORS +3 MECH.+3 STR.+ ROOF

PLOT NO:

JVC13RHRG001

LOCATION:

AL BARSHA SOUTH FOURTH(681)

ARCH:

AMAR M

STR Engg:

M FLAHA

Reg. No:

114763

Reg. No:

109115

SCALE:

DRAWN: MUS

CHECKED & APPROVED: AM

1:200

DRAWING TITLE:

BASEMENT-2 FLOOR PLAN

PROJECT NO:


P025-01

DWG NO:

A101

REV:

00

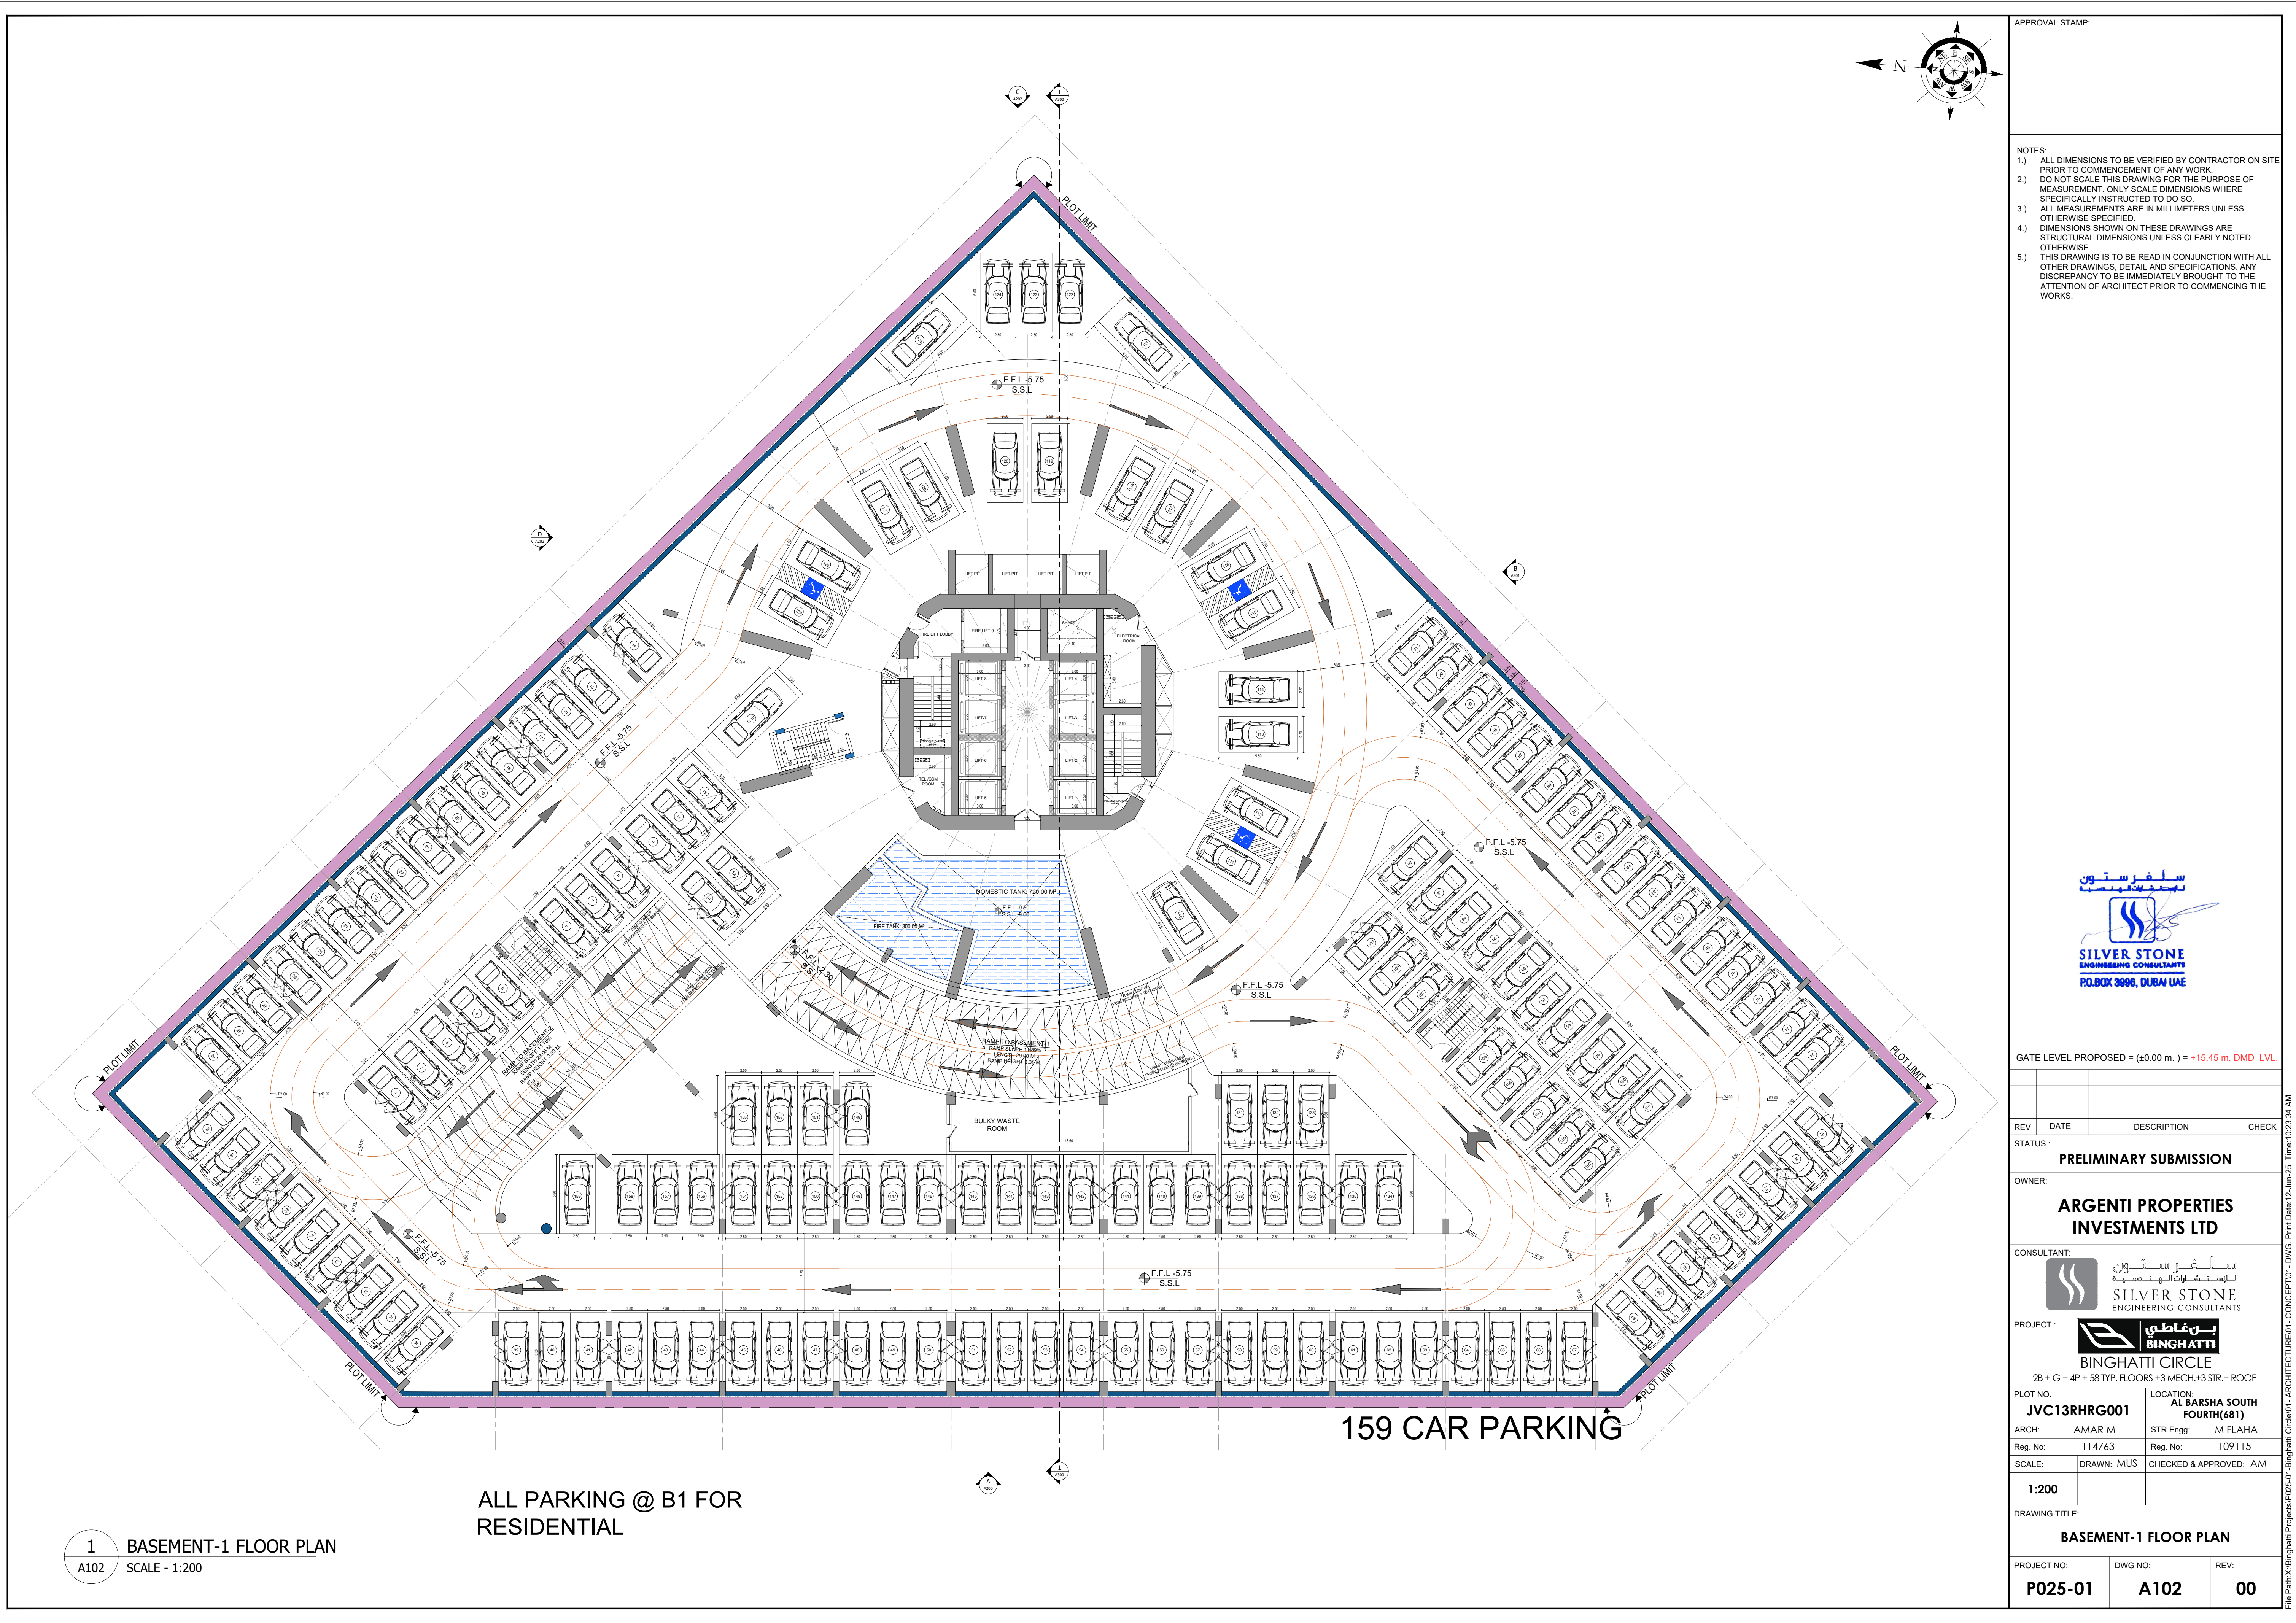

APPROVAL STAMP:

NOTES:

- 1.) ALL DIMENSIONS TO BE VERIFIED BY CONTRACTOR ON SITE PRIOR TO COMMENCEMENT OF ANY WORK.
- 2.) DO NOT SCALE THIS DRAWING FOR THE PURPOSE OF MEASUREMENT. ONLY SCALE DIMENSIONS WHERE SPECIFICALLY INSTRUCTED TO DO SO.
- 3.) ALL MEASUREMENTS ARE IN MILLIMETERS UNLESS OTHERWISE SPECIFIED.
- 4.) DIMENSIONS SHOWN ON THESE DRAWINGS ARE STRUCTURAL DIMENSIONS UNLESS CLEARLY NOTED OTHERWISE.
- 5.) THIS DRAWING IS TO BE READ IN CONJUNCTION WITH ALL OTHER DRAWINGS, DETAIL AND SPECIFICATIONS. ANY DISCREPANCY TO BE IMMEDIATELY BROUGHT TO THE ATTENTION OF ARCHITECT PRIOR TO COMMENCING THE WORKS.

سلفر ستون
الهندسة
SILVER STONE
ENGINEERING CONSULTANTS
P.O. BOX 3096, DUBAI UAE

GATE LEVEL PROPOSED = (±0.00 m.) = +15.45 m. DMD LVL.



REV	DATE	DESCRIPTION	CHECK
STATUS:			
PRELIMINARY SUBMISSION			
OWNER:			
ARGENTI PROPERTIES INVESTMENTS LTD			
CONSULTANT:			
سلفر ستون الهندسة SILVER STONE ENGINEERING CONSULTANTS			
PROJECT:			
BINGHATTI CIRCLE			
2B + G + 4P + S8 TYP. FLOORS +3 MECH.+3 STR.+ ROOF			
PLOT NO:		LOCATION:	
JVC13RHRG001		AL BARSHA SOUTH FOURTH(681)	
ARCH:		STR Engg:	
AMAR M		M FLAHA	
Reg. No:		Reg. No:	
114763		109115	
SCALE:		DRAWN: MUS	
1:200		CHECKED & APPROVED: AM	
DRAWING TITLE:			
BASEMENT-1 FLOOR PLAN			
PROJECT NO:		DWG NO:	
P025-01		A102	
		REV:	
		00	

ALL PARKING @ B1 FOR
RESIDENTIAL

159 CAR PARKING

1 BASEMENT-1 FLOOR PLAN
A102 SCALE - 1:200

File Path: X:\Binghatti Project\025-01-Binghatti Circle\01- ARCHITECTURE\01- CONCEPT\01- DWG- Print Date: 12-Jun-25, Time: 10:23:34 AM

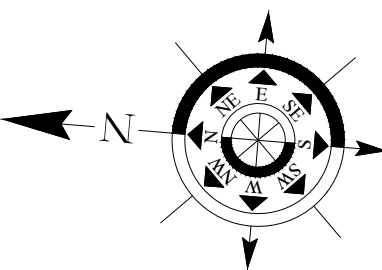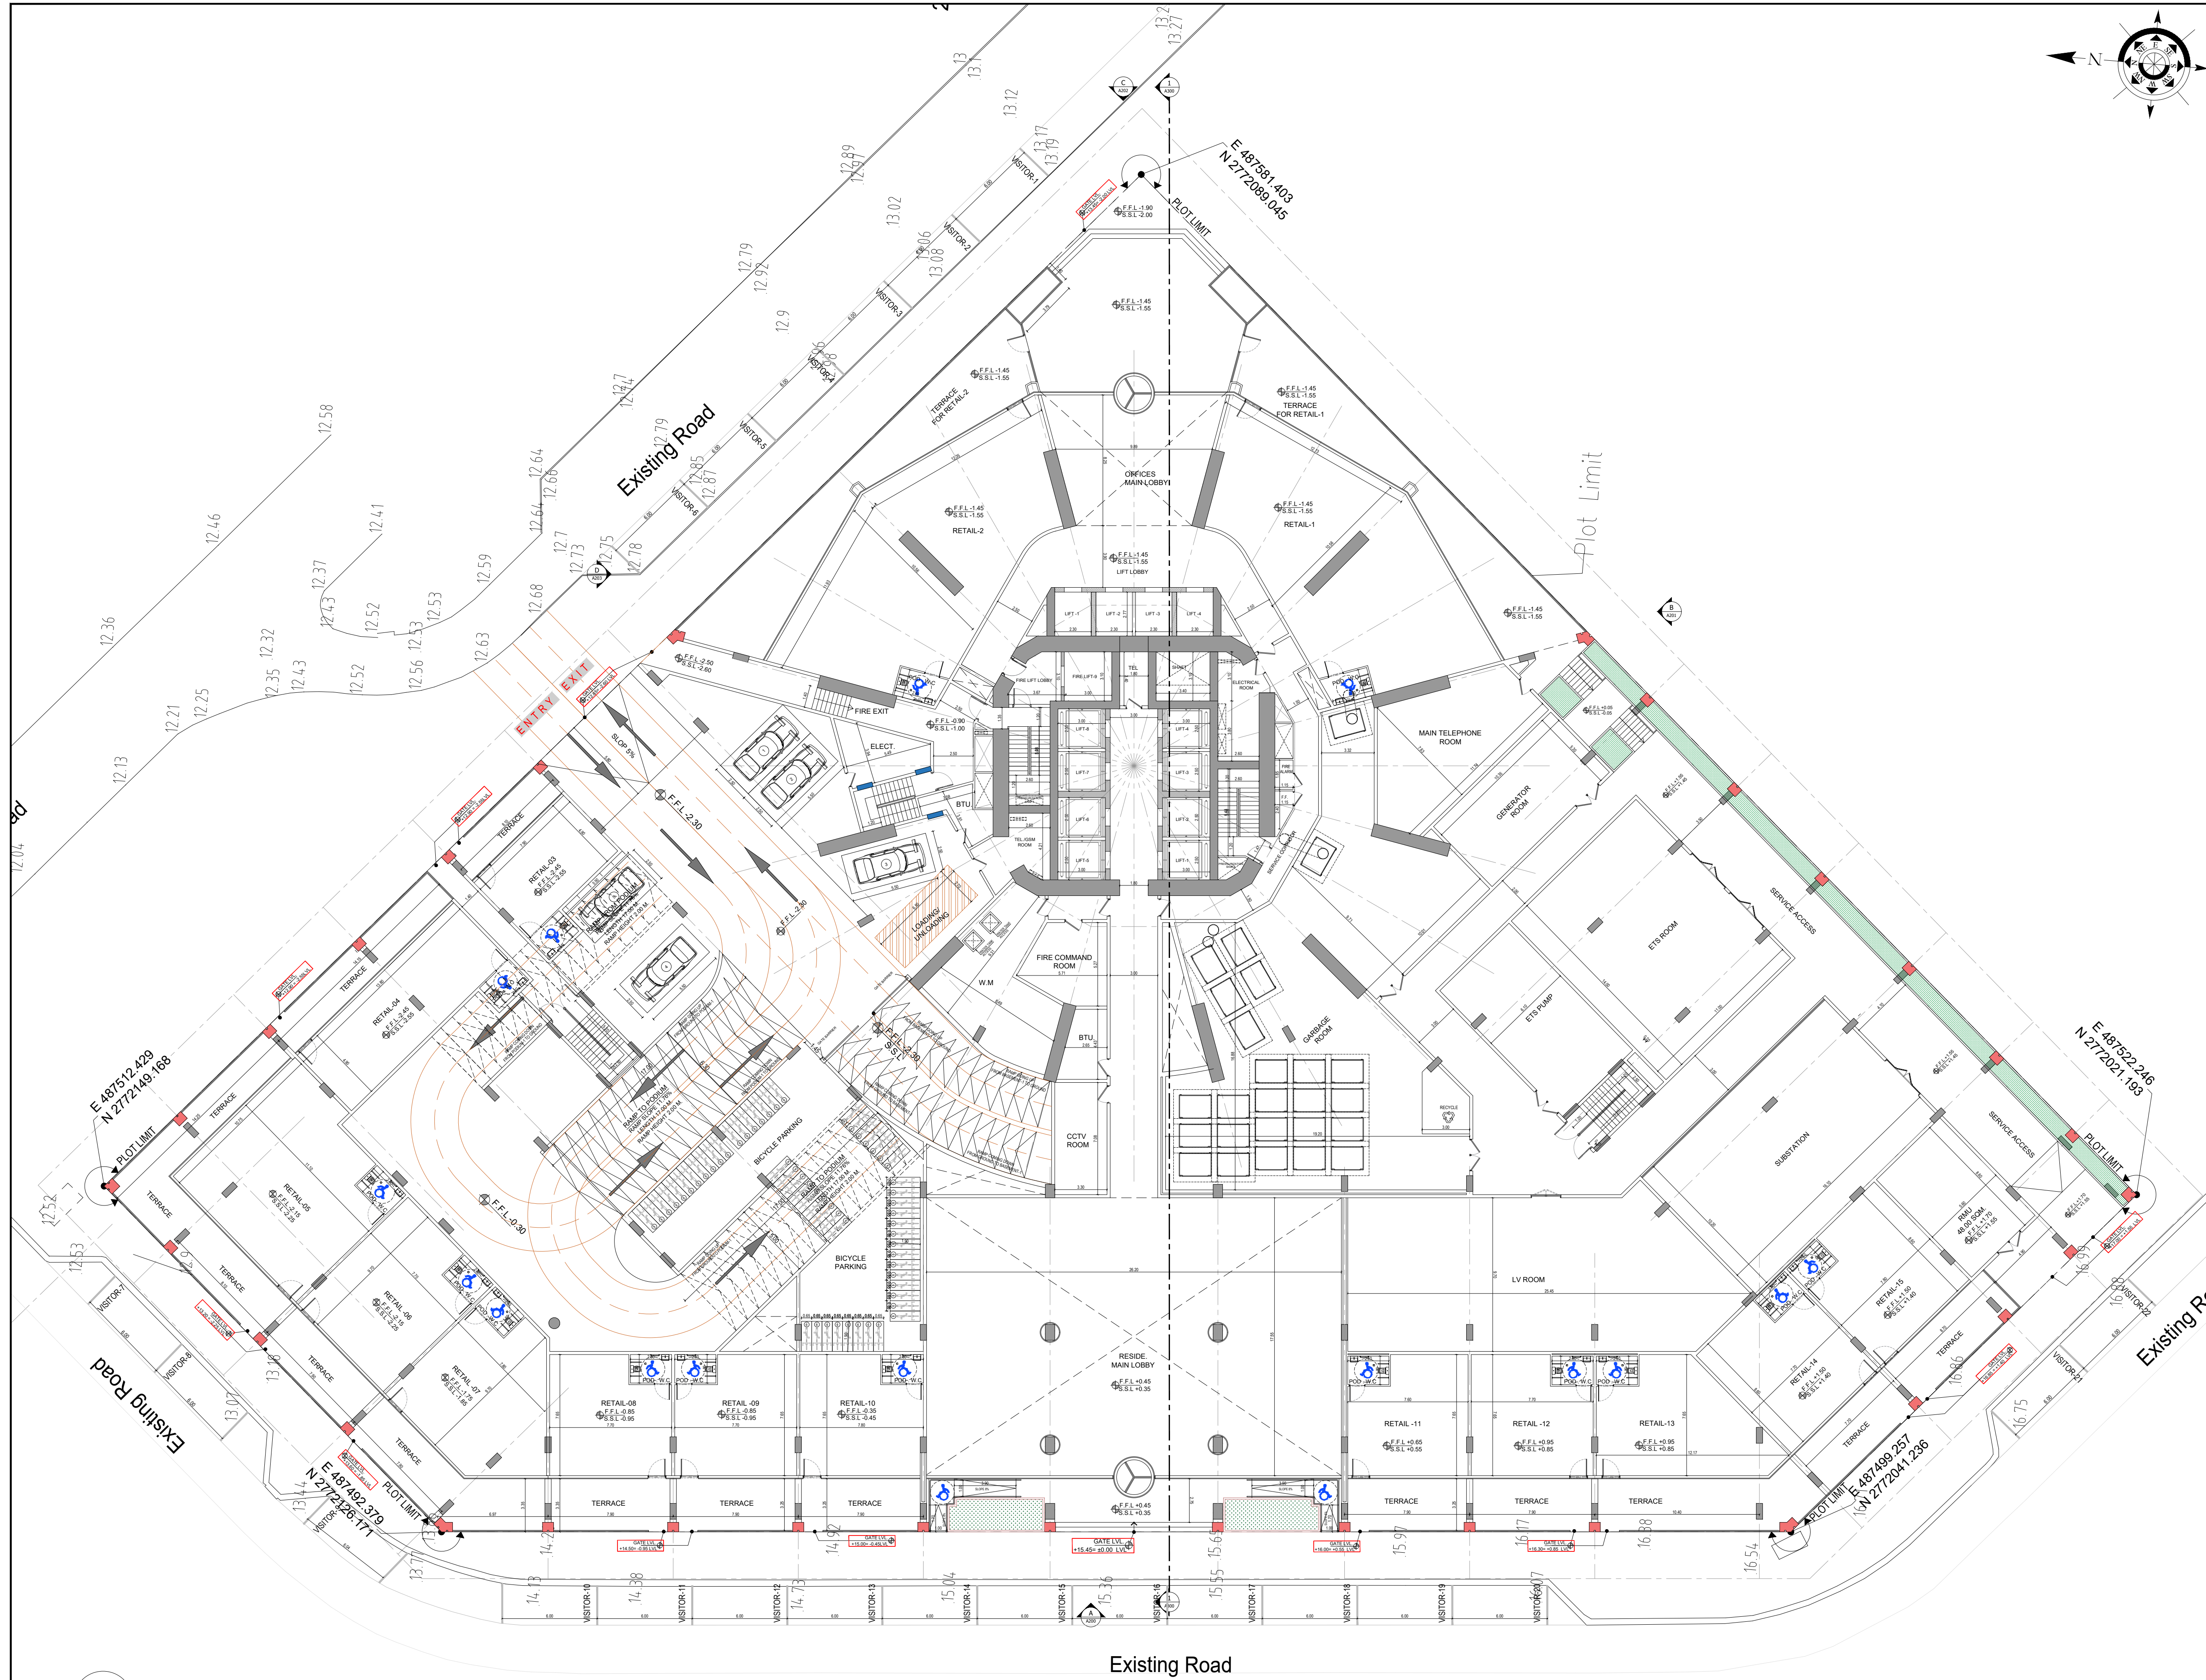

- APPROVAL STAMP:
- NOTES:
- 1.) ALL DIMENSIONS TO BE VERIFIED BY CONTRACTOR ON SITE PRIOR TO COMMENCEMENT OF ANY WORK.
 - 2.) DO NOT SCALE THIS DRAWING FOR THE PURPOSE OF MEASUREMENT. ONLY SCALE DIMENSIONS WHERE SPECIFICALLY INSTRUCTED TO DO SO.
 - 3.) ALL MEASUREMENTS ARE IN MILLIMETERS UNLESS OTHERWISE SPECIFIED.
 - 4.) DIMENSIONS SHOWN ON THESE DRAWINGS ARE STRUCTURAL DIMENSIONS UNLESS CLEARLY NOTED OTHERWISE.
 - 5.) THIS DRAWING IS TO BE READ IN CONJUNCTION WITH ALL OTHER DRAWINGS, DETAIL AND SPECIFICATIONS. ANY DISCREPANCY TO BE IMMEDIATELY BROUGHT TO THE ATTENTION OF ARCHITECT PRIOR TO COMMENCING THE WORKS.



GATE LEVEL PROPOSED = (±0.00 m.) = +15.45 m. DMD LVL.


REV	DATE	DESCRIPTION	CHECK
STATUS :			
PRELIMINARY SUBMISSION			
OWNER:			
ARGENTI PROPERTIES INVESTMENTS LTD			
CONSULTANT:			
		 SILVER STONE ENGINEERING CONSULTANTS	
PROJECT :		 BINGHATTI CIRCLE	
2B + G + 4P + S8 TYP. FLOORS +3 MECH.+3 STR.+ ROOF			
PLOT NO:		LOCATION:	
JVC13RHRG001		AL BARSHA SOUTH FOURTH(681)	
ARCH: AMAR M		STR Engg: M FLAHA	
Reg. No: 114763		Reg. No: 109115	
SCALE:		CHECKED & APPROVED: AM	
DRAWN: MUS			
1:200			
DRAWING TITLE:			
GROUND FLOOR PLAN			
PROJECT NO:		DWG NO:	
P025-01		A103	
		REV:	
		00	

1 GROUND FLOOR PLAN
A103 SCALE - 1:200

Existing Road

5 CAR PARKING

File Path: X:\Binghatti Project\025-01-Binghatti Circle\01- ARCHITECTURE\01- CONCEPT\01- DWG- Print Date: 12-Jun-25, Time: 10:23:34 AM

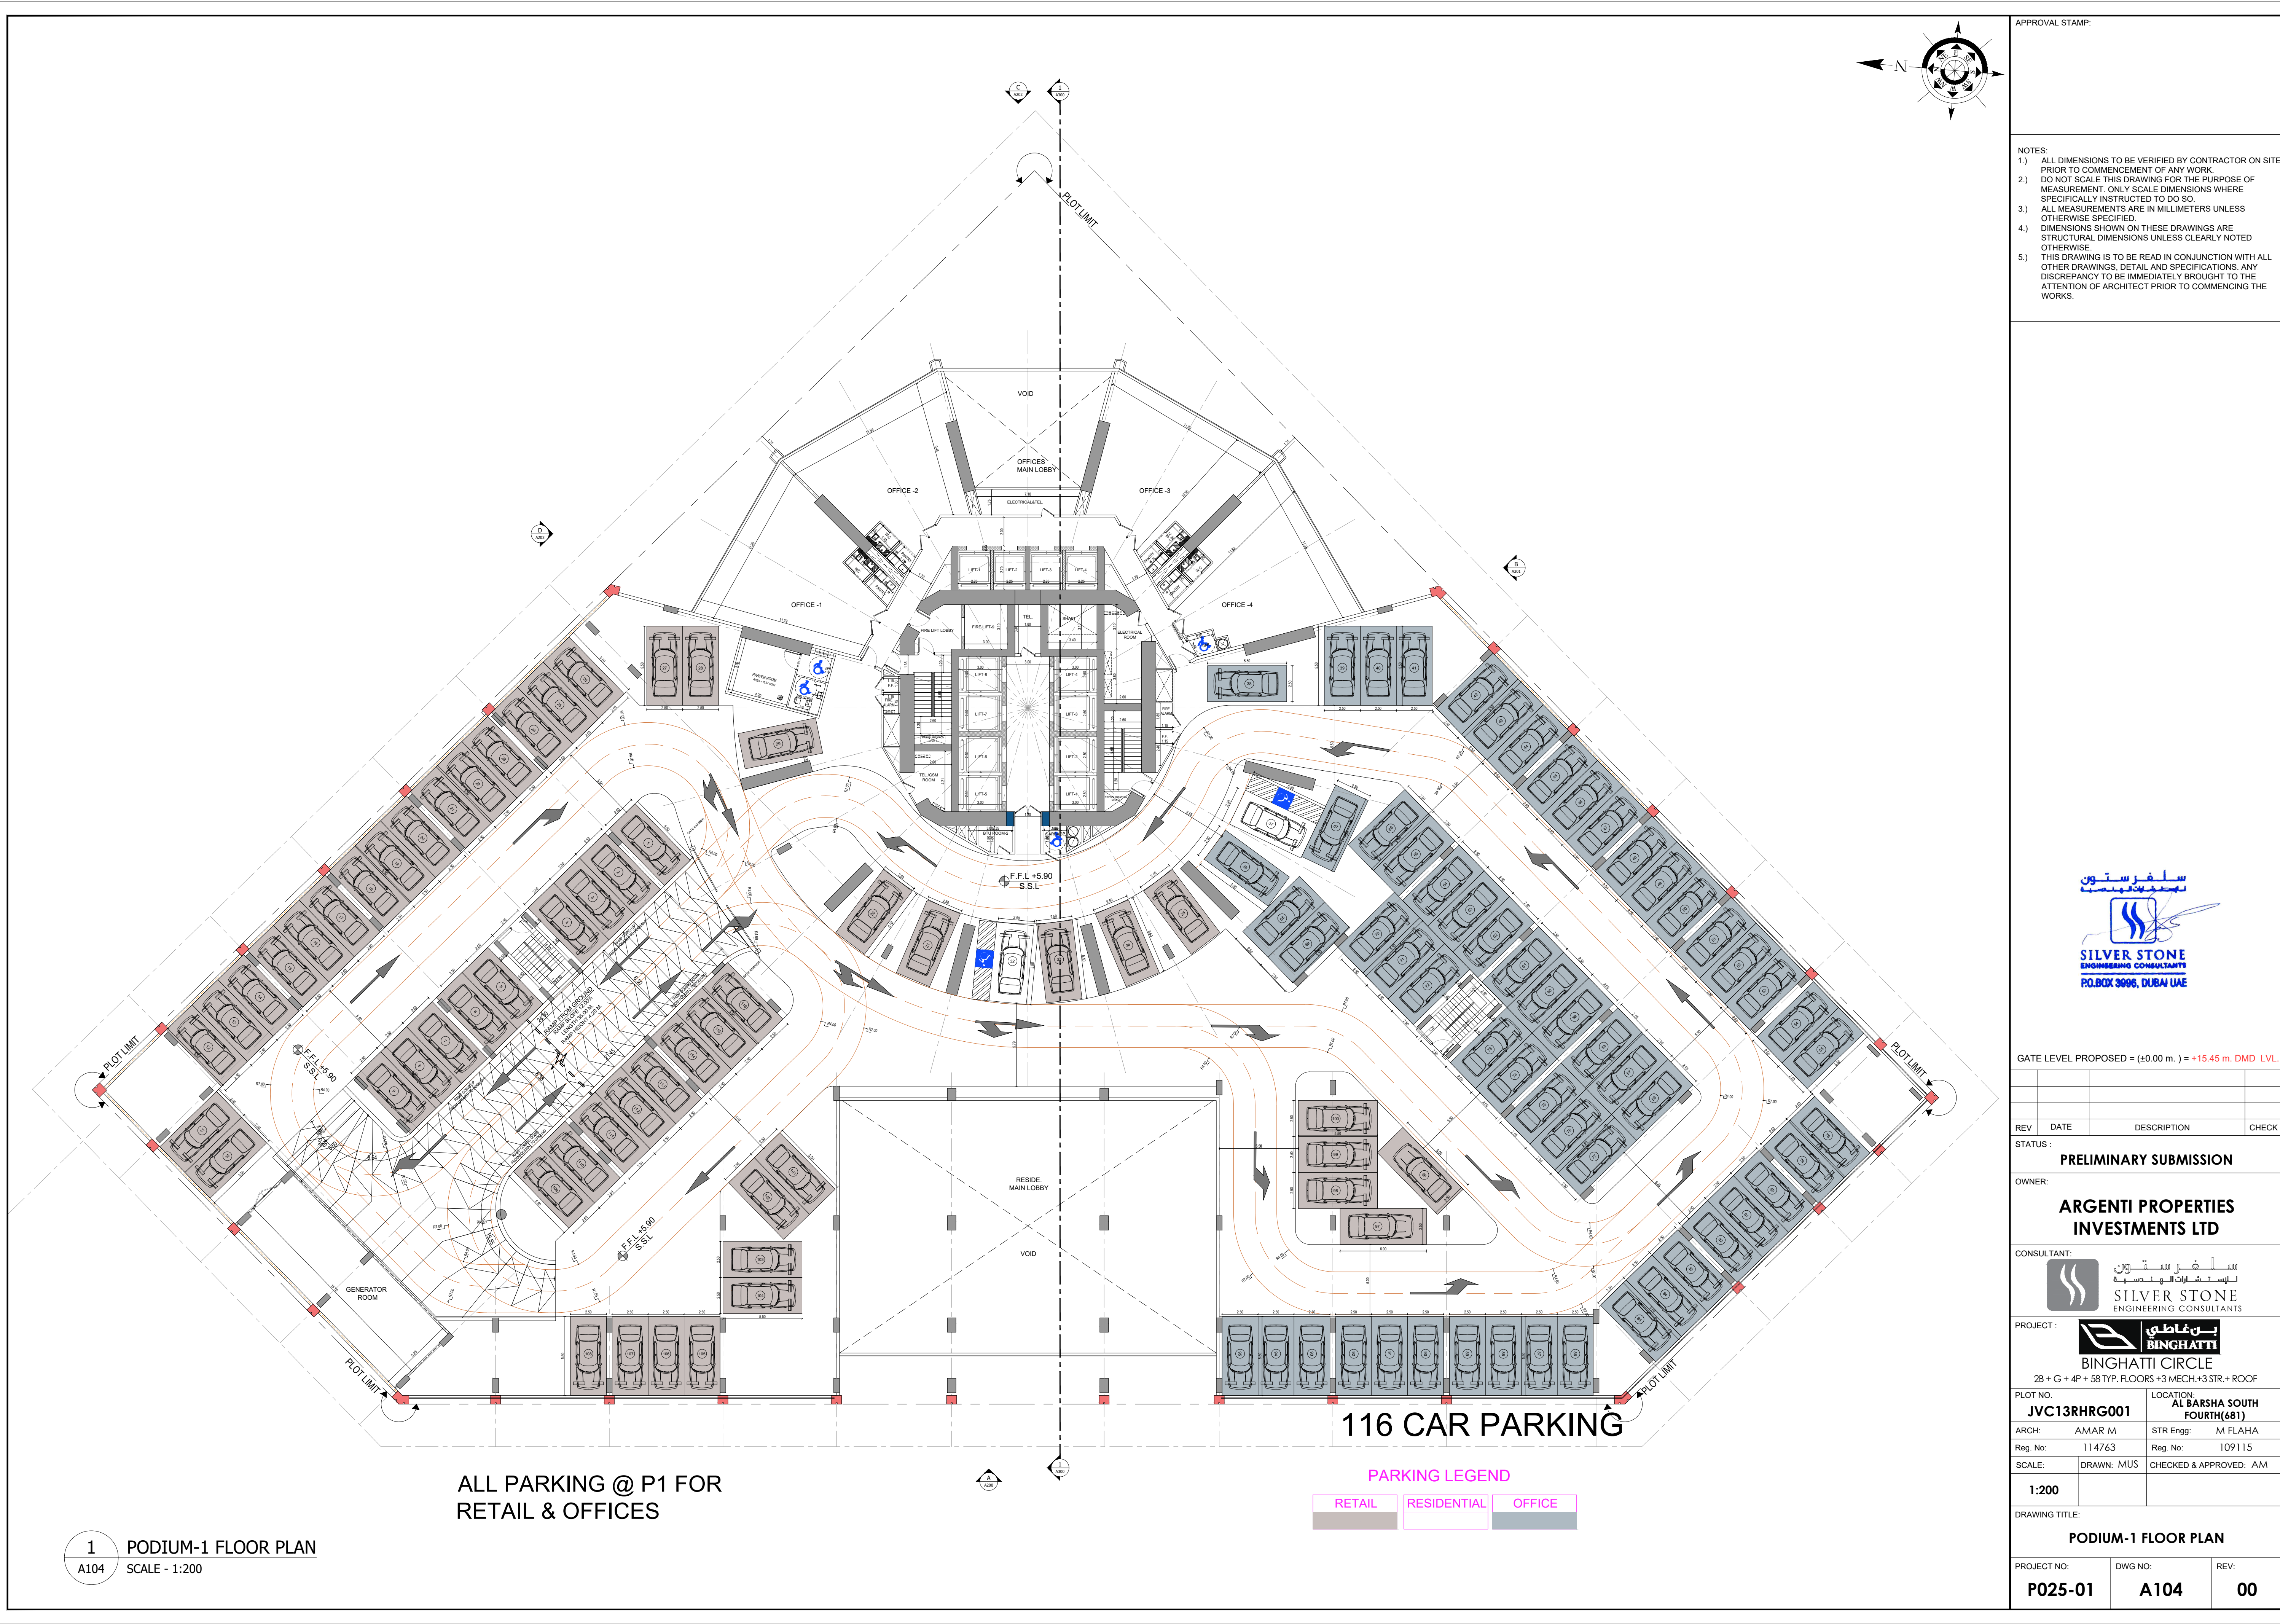

APPROVAL STAMP:

NOTES:

- 1.) ALL DIMENSIONS TO BE VERIFIED BY CONTRACTOR ON SITE PRIOR TO COMMENCEMENT OF ANY WORK.
- 2.) DO NOT SCALE THIS DRAWING FOR THE PURPOSE OF MEASUREMENT. ONLY SCALE DIMENSIONS WHERE SPECIFICALLY INSTRUCTED TO DO SO.
- 3.) ALL MEASUREMENTS ARE IN MILLIMETERS UNLESS OTHERWISE SPECIFIED.
- 4.) DIMENSIONS SHOWN ON THESE DRAWINGS ARE STRUCTURAL DIMENSIONS UNLESS CLEARLY NOTED OTHERWISE.
- 5.) THIS DRAWING IS TO BE READ IN CONJUNCTION WITH ALL OTHER DRAWINGS, DETAIL AND SPECIFICATIONS. ANY DISCREPANCY TO BE IMMEDIATELY BROUGHT TO THE ATTENTION OF ARCHITECT PRIOR TO COMMENCING THE WORKS.



GATE LEVEL PROPOSED = (±0.00 m.) = +15.45 m. DMD LVL.

REV	DATE	DESCRIPTION	CHECK
STATUS:			

PRELIMINARY SUBMISSION

OWNER:
ARGENTI PROPERTIES INVESTMENTS LTD

CONSULTANT:
SILVER STONE ENGINEERING CONSULTANTS

PROJECT:
BINGHATTI CIRCLE

PLOT NO: JVC13RHRG001	LOCATION: AL BARSHA SOUTH FOURTH(681)
ARCH: AMAR M	STR Engg: M FLAHA
Reg. No: 114763	Reg. No: 109115
SCALE: 1:200	DRAWN: MUS CHECKED & APPROVED: AM

DRAWING TITLE: PODIUM-1 FLOOR PLAN		
PROJECT NO: P025-01	DWG NO: A104	REV: 00


116 CAR PARKING


PARKING LEGEND

RETAIL	RESIDENTIAL	OFFICE
--------	-------------	--------

ALL PARKING @ P1 FOR
RETAIL & OFFICES

1 PODIUM-1 FLOOR PLAN
A104 SCALE - 1:200

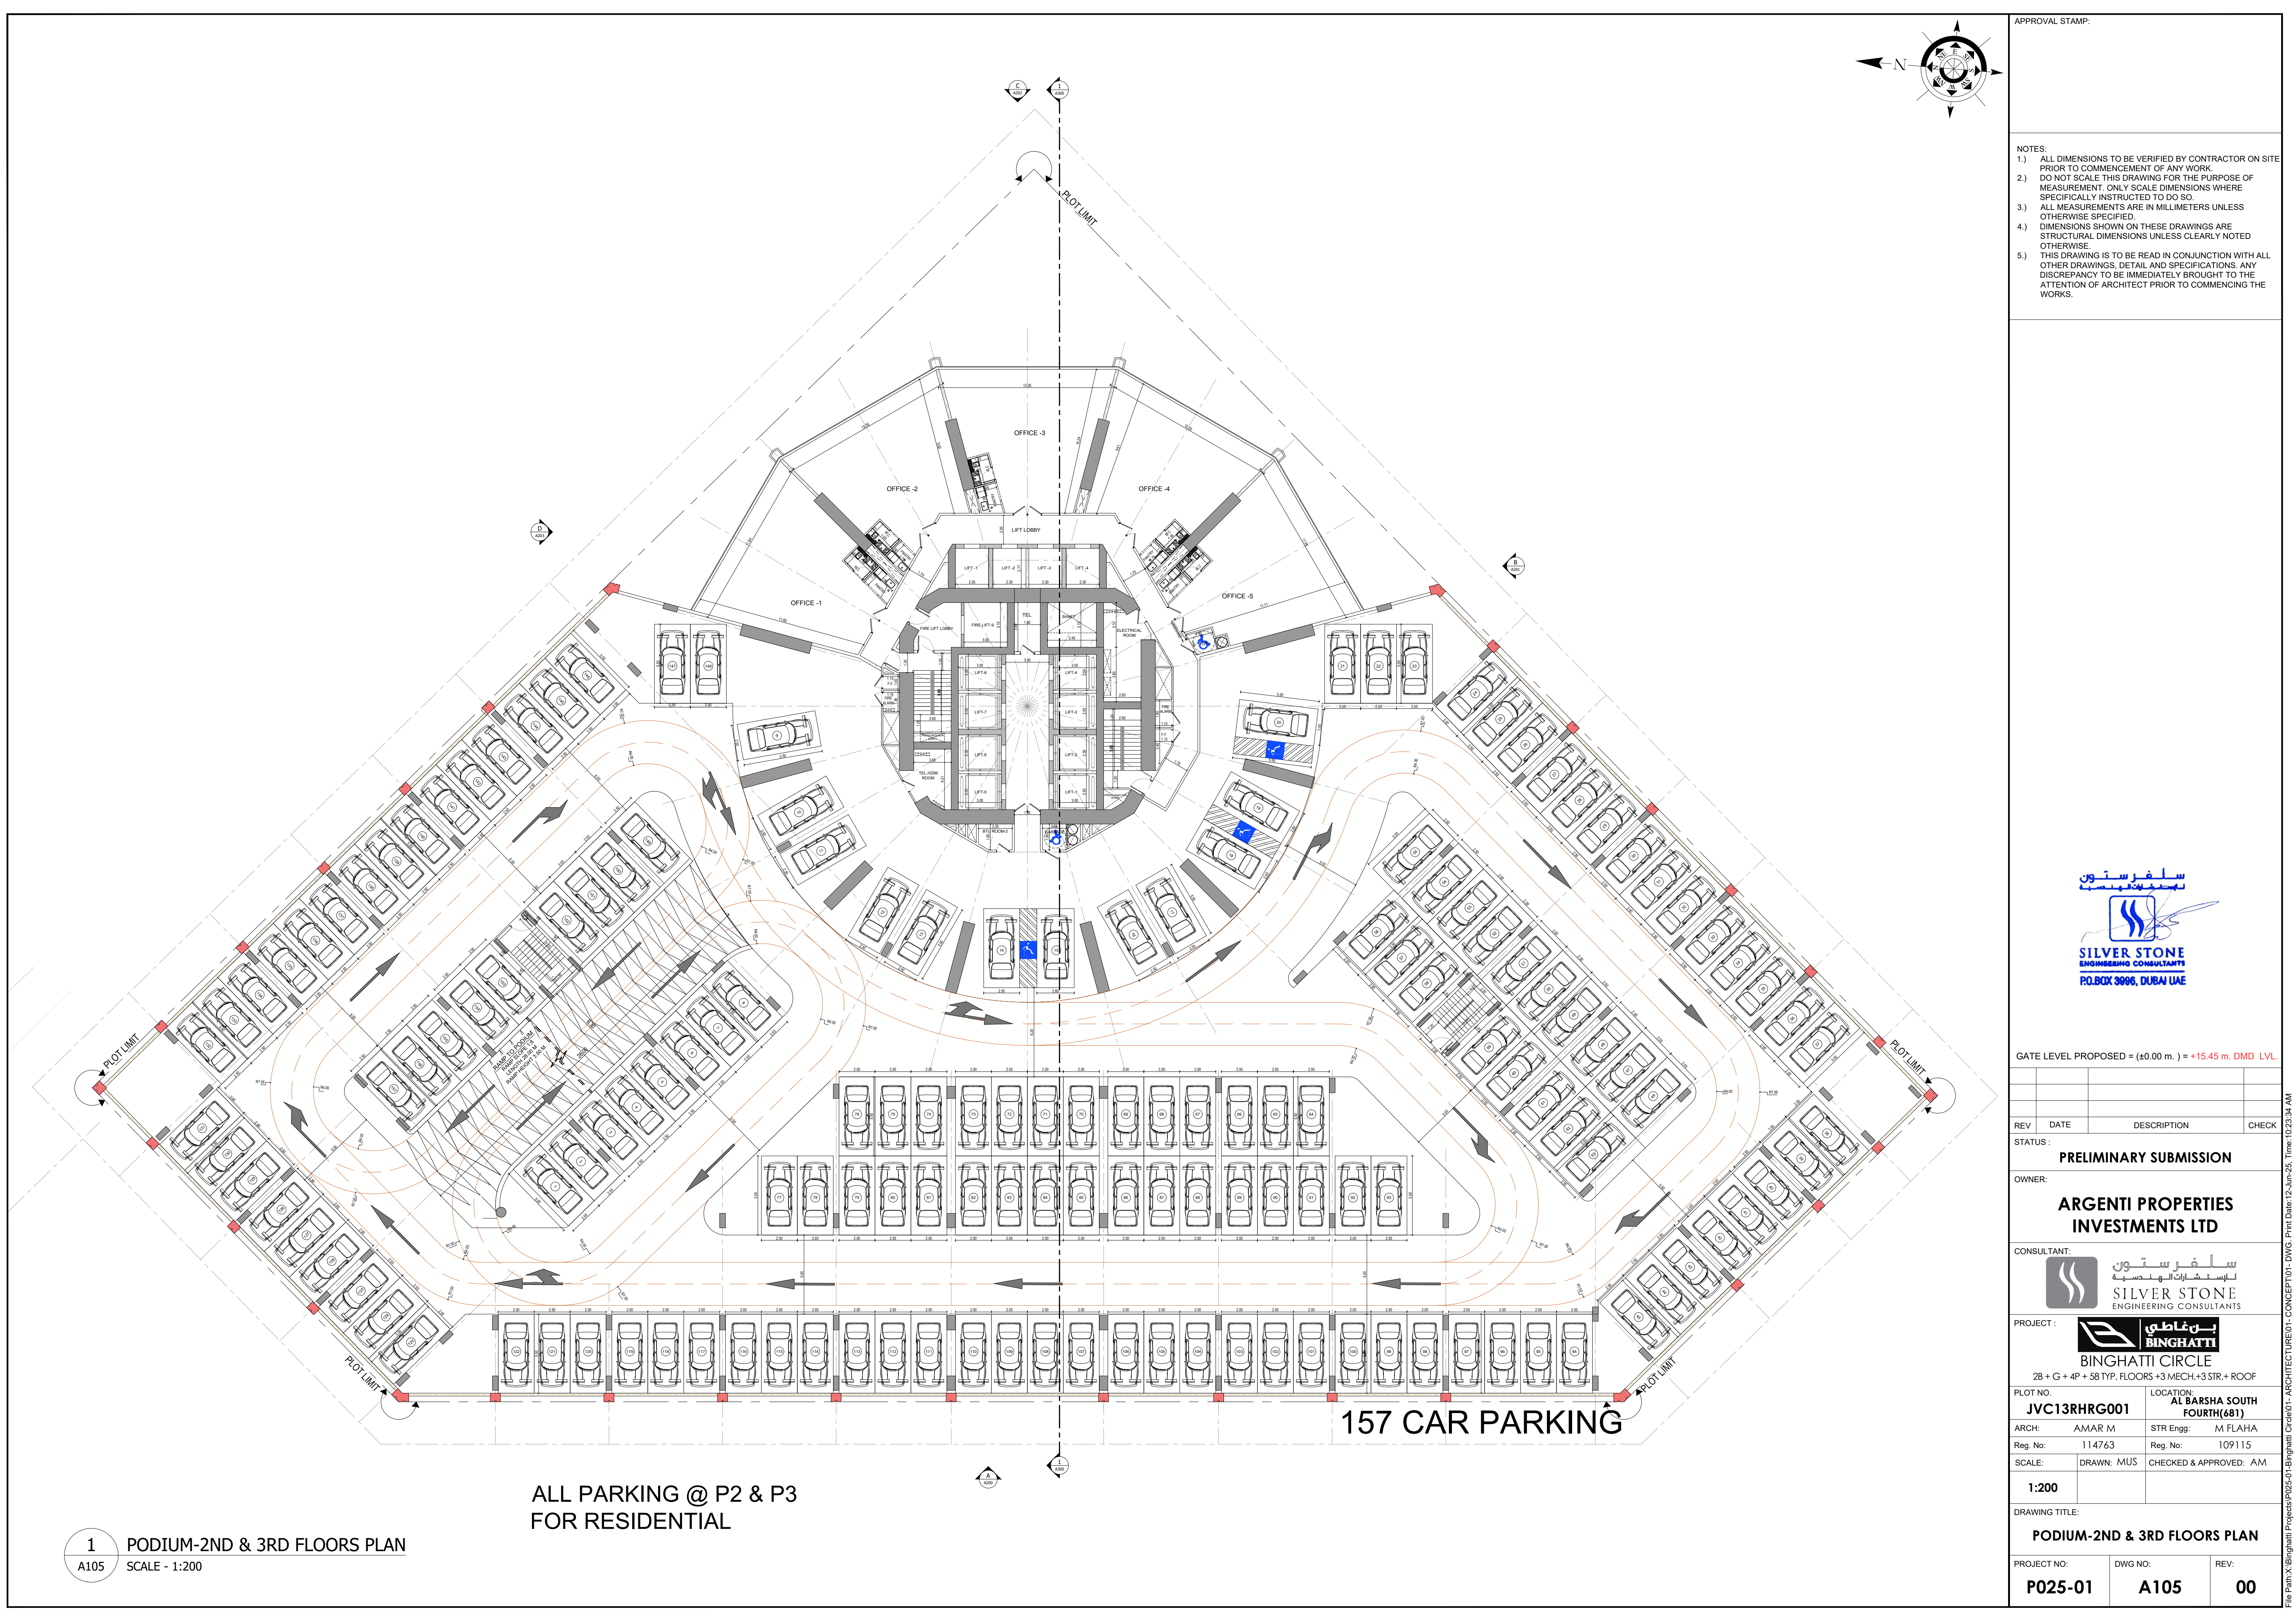

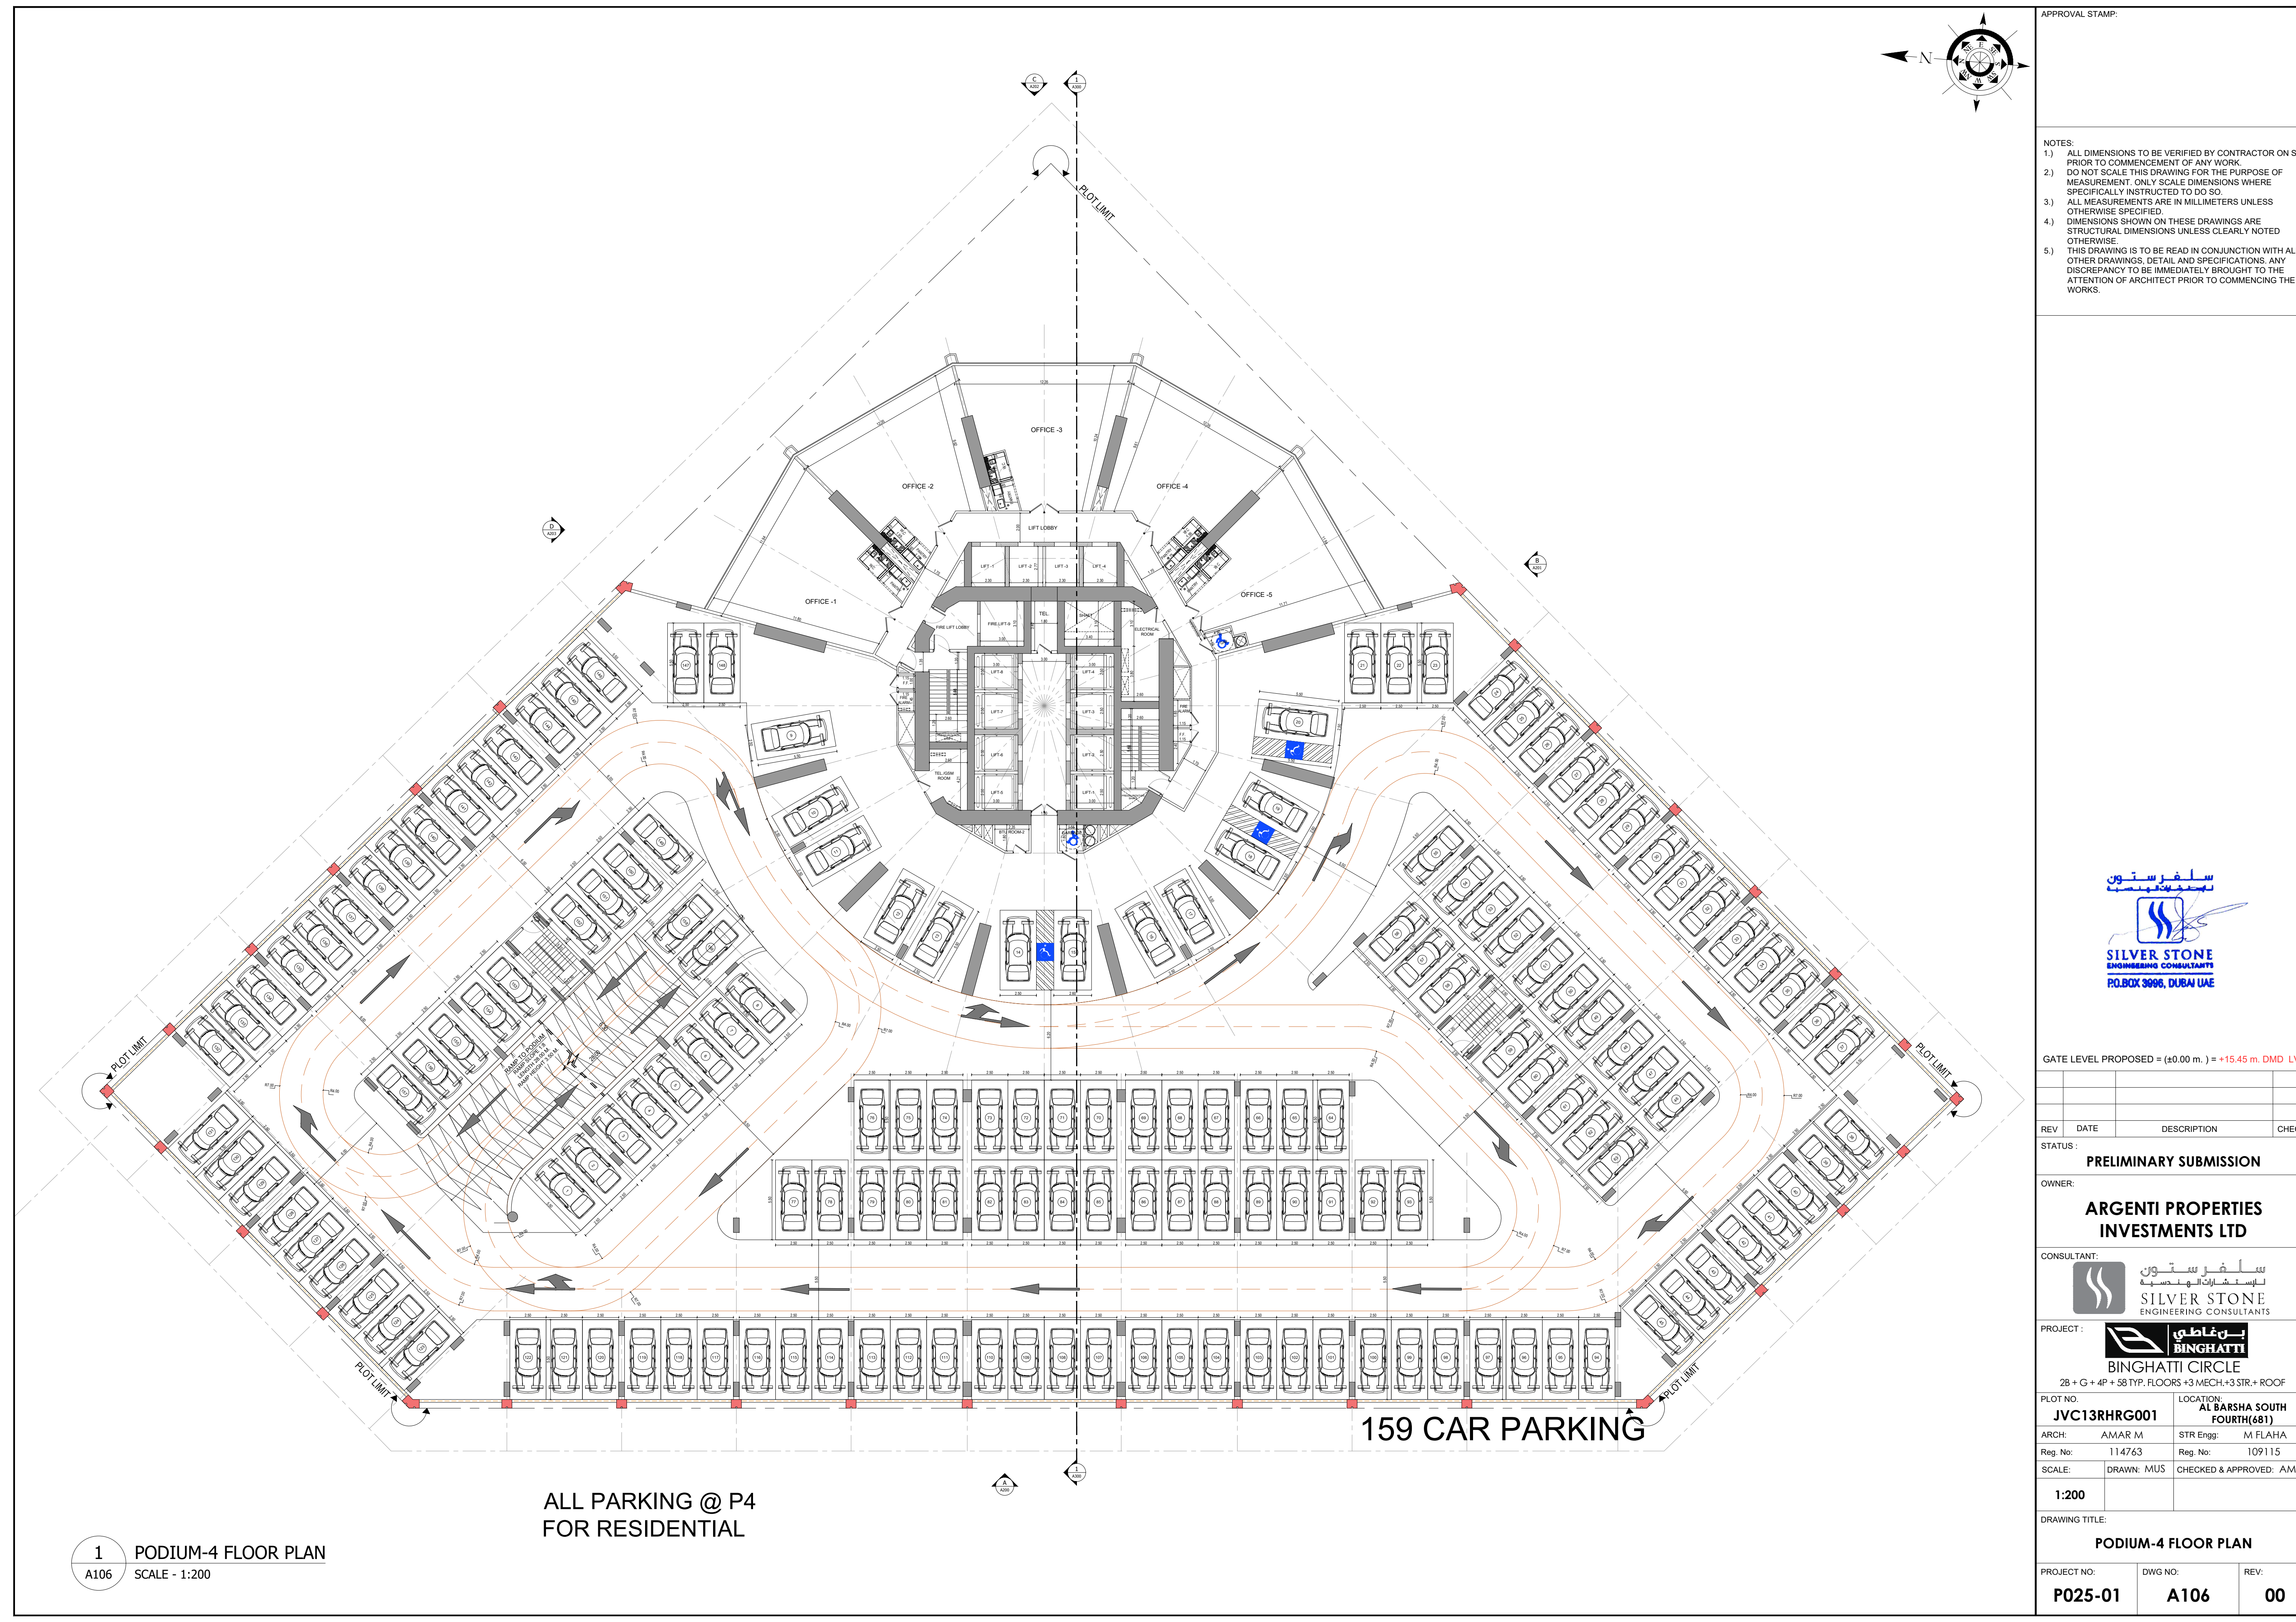

APPROVAL STAMP:

NOTES:

- 1.) ALL DIMENSIONS TO BE VERIFIED BY CONTRACTOR ON SITE PRIOR TO COMMENCEMENT OF ANY WORK.
- 2.) DO NOT SCALE THIS DRAWING FOR THE PURPOSE OF MEASUREMENT. ONLY SCALE DIMENSIONS WHERE SPECIFICALLY INSTRUCTED TO DO SO.
- 3.) ALL MEASUREMENTS ARE IN MILLIMETERS UNLESS OTHERWISE SPECIFIED.
- 4.) DIMENSIONS SHOWN ON THESE DRAWINGS ARE STRUCTURAL DIMENSIONS UNLESS CLEARLY NOTED OTHERWISE.
- 5.) THIS DRAWING IS TO BE READ IN CONJUNCTION WITH ALL OTHER DRAWINGS, DETAIL AND SPECIFICATIONS. ANY DISCREPANCY TO BE IMMEDIATELY BROUGHT TO THE ATTENTION OF ARCHITECT PRIOR TO COMMENCING THE WORKS.



GATE LEVEL PROPOSED = (±0.00 m.) = +15.45 m. DMD LVL.

REV	DATE	DESCRIPTION	CHECK
STATUS:			

PRELIMINARY SUBMISSION

OWNER:

ARGENTI PROPERTIES INVESTMENTS LTD



PROJECT : **بن غاطي BINGHATTI**
BINGHATTI CIRCLE

2B + G + 4P + S8 TYP. FLOORS +3 MECH.+3 STR.+ ROOF

PLOT NO: **JVC13RHRG001** LOCATION: **AL BARSHA SOUTH FOURTH(681)**

ARCH: **AMAR M** STR Enng: **M FLAHA**

Reg. No: **114763** Reg. No: **109115**

SCALE: **1:200** DRAWN: **MUS** CHECKED & APPROVED: **AM**

DRAWING TITLE:


PODIUM-4 FLOOR PLAN

PROJECT NO: **P025-01** DWG NO: **A106** REV: **00**

1 **PODIUM-4 FLOOR PLAN**
A106 SCALE - 1:200

**ALL PARKING @ P4
FOR RESIDENTIAL**

159 CAR PARKING

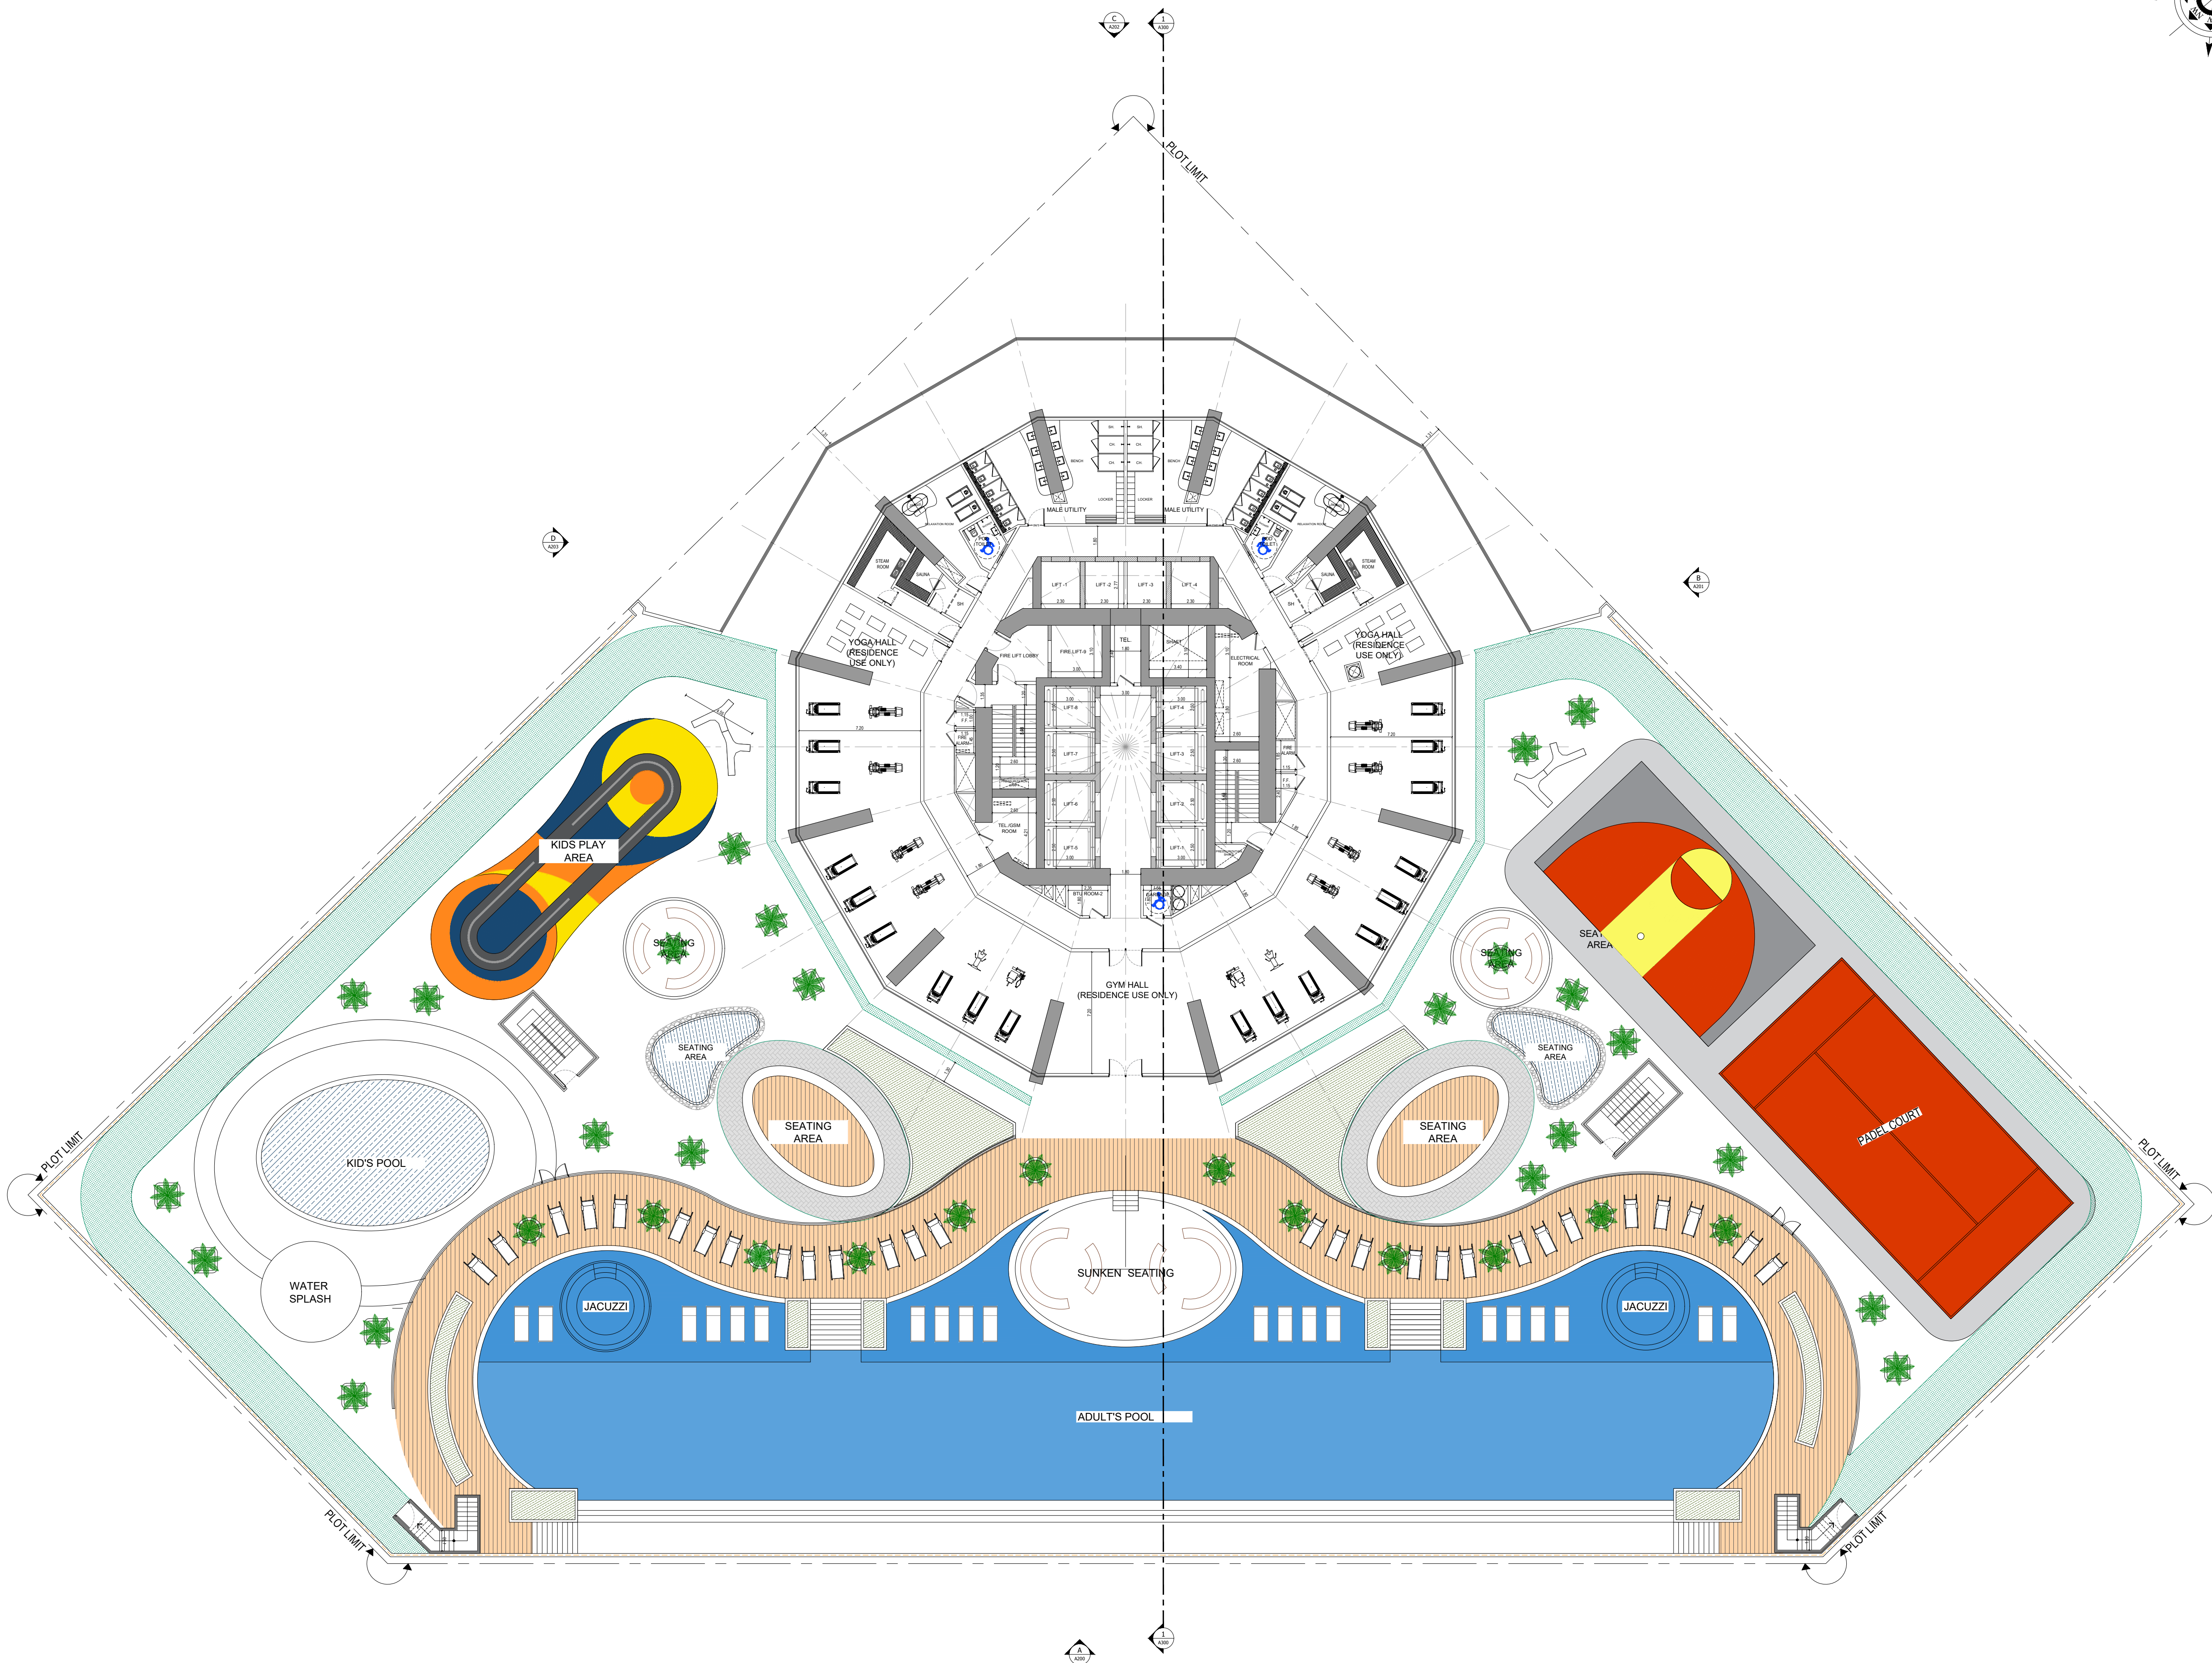

1 FIRST FLOOR PLAN
A107 SCALE - 1:200

APPROVAL STAMP:

- NOTES:
- 1.) ALL DIMENSIONS TO BE VERIFIED BY CONTRACTOR ON SITE PRIOR TO COMMENCEMENT OF ANY WORK.
 - 2.) DO NOT SCALE THIS DRAWING FOR THE PURPOSE OF MEASUREMENT. ONLY SCALE DIMENSIONS WHERE SPECIFICALLY INSTRUCTED TO DO SO.
 - 3.) ALL MEASUREMENTS ARE IN MILLIMETERS UNLESS OTHERWISE SPECIFIED.
 - 4.) DIMENSIONS SHOWN ON THESE DRAWINGS ARE STRUCTURAL DIMENSIONS UNLESS CLEARLY NOTED OTHERWISE.
 - 5.) THIS DRAWING IS TO BE READ IN CONJUNCTION WITH ALL OTHER DRAWINGS, DETAIL AND SPECIFICATIONS. ANY DISCREPANCY TO BE IMMEDIATELY BROUGHT TO THE ATTENTION OF ARCHITECT PRIOR TO COMMENCING THE WORKS.



GATE LEVEL PROPOSED = (±0.00 m.) = +15.45 m. DMD LVL.

REV	DATE	DESCRIPTION	CHECK

STATUS: PRELIMINARY SUBMISSION

OWNER: ARGENTI PROPERTIES INVESTMENTS LTD

CONSULTANT: SILVER STONE ENGINEERING CONSULTANTS



PROJECT: BINGHATTI CIRCLE
2B + G + 4P + S8 TYP. FLOORS +3 MECH.+3 STR.+ ROOF

PLOT NO:	JVC13RHRG001	LOCATION:	AL BARSHA SOUTH FOURTH(681)
ARCH:	AMAR M	STR Engg:	M FLAHA
Reg. No:	114763	Reg. No:	109115
SCALE:	DRAWN: MUS	CHECKED & APPROVED:	AM

1:200

DRAWING TITLE: FIRST FLOOR PLAN


PROJECT NO:	DWG NO:	REV:
P025-01	A107	00

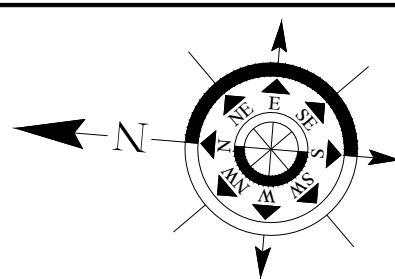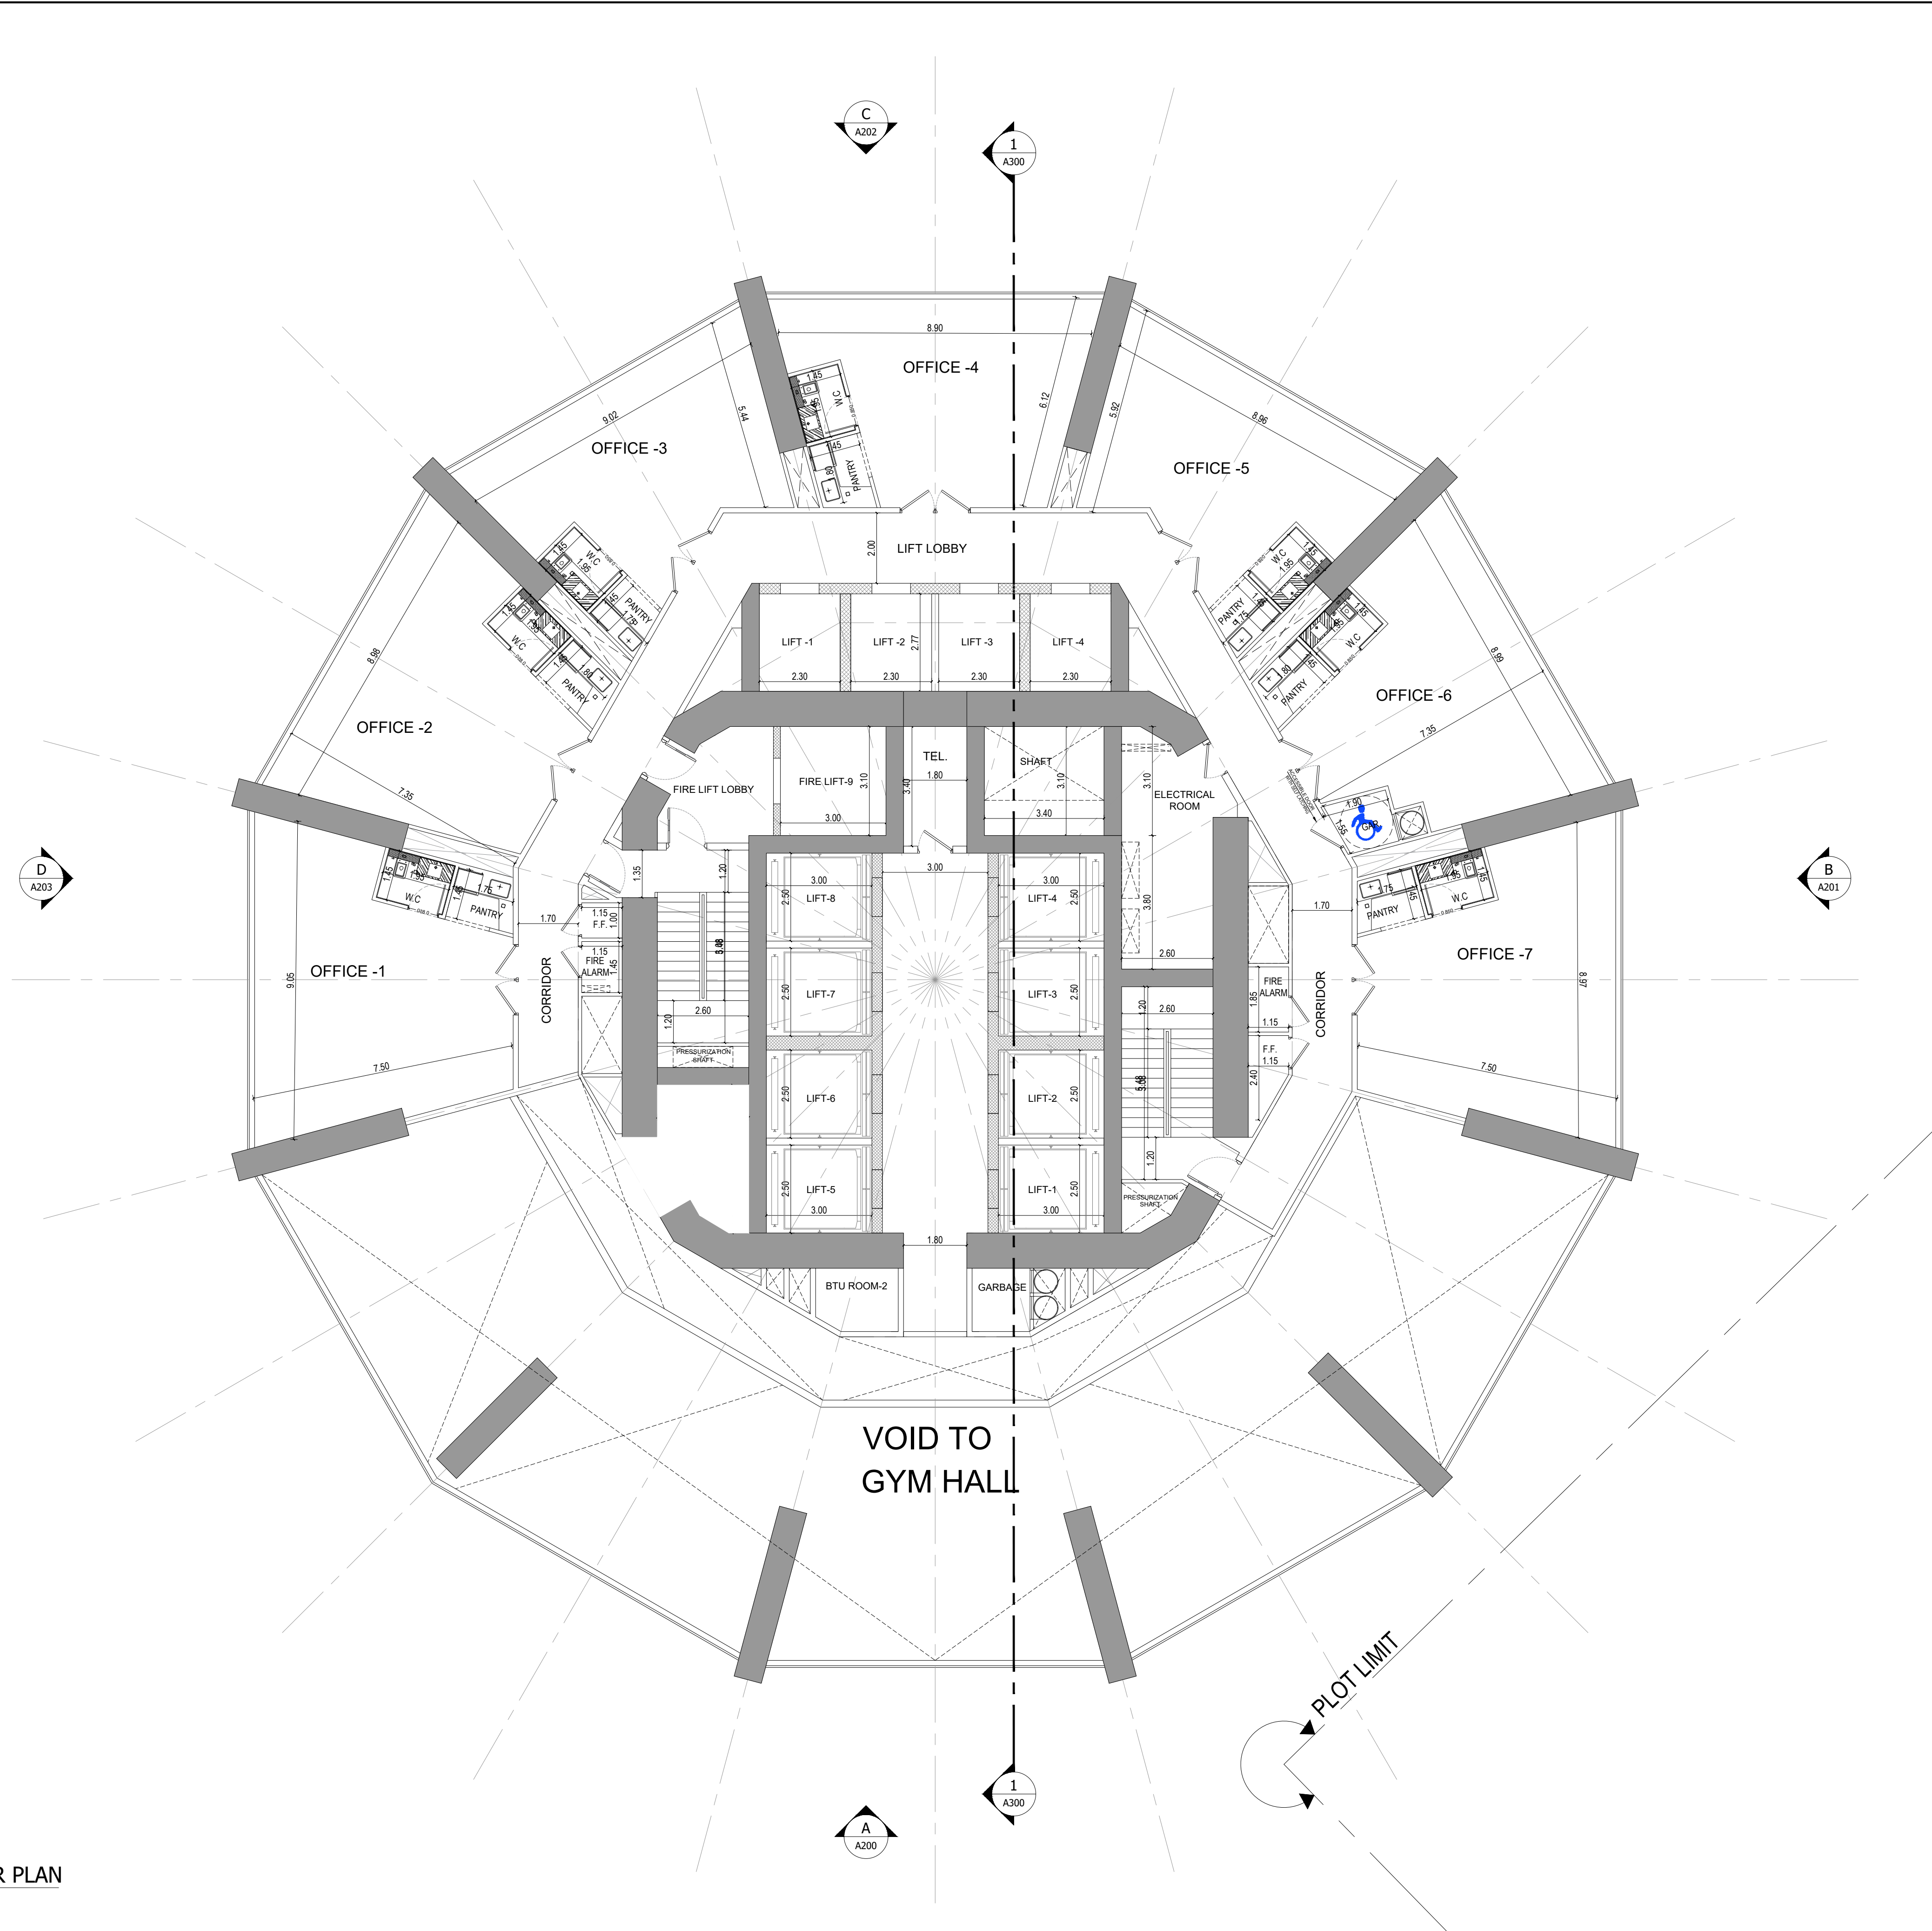

APPROVAL STAMP:

NOTES:

- 1.) ALL DIMENSIONS TO BE VERIFIED BY CONTRACTOR ON SITE PRIOR TO COMMENCEMENT OF ANY WORK.
- 2.) DO NOT SCALE THIS DRAWING FOR THE PURPOSE OF MEASUREMENT. ONLY SCALE DIMENSIONS WHERE SPECIFICALLY INSTRUCTED TO DO SO.
- 3.) ALL MEASUREMENTS ARE IN MILLIMETERS UNLESS OTHERWISE SPECIFIED.
- 4.) DIMENSIONS SHOWN ON THESE DRAWINGS ARE STRUCTURAL DIMENSIONS UNLESS CLEARLY NOTED OTHERWISE.
- 5.) THIS DRAWING IS TO BE READ IN CONJUNCTION WITH ALL OTHER DRAWINGS, DETAIL AND SPECIFICATIONS. ANY DISCREPANCY TO BE IMMEDIATELY BROUGHT TO THE ATTENTION OF ARCHITECT PRIOR TO COMMENCING THE WORKS.

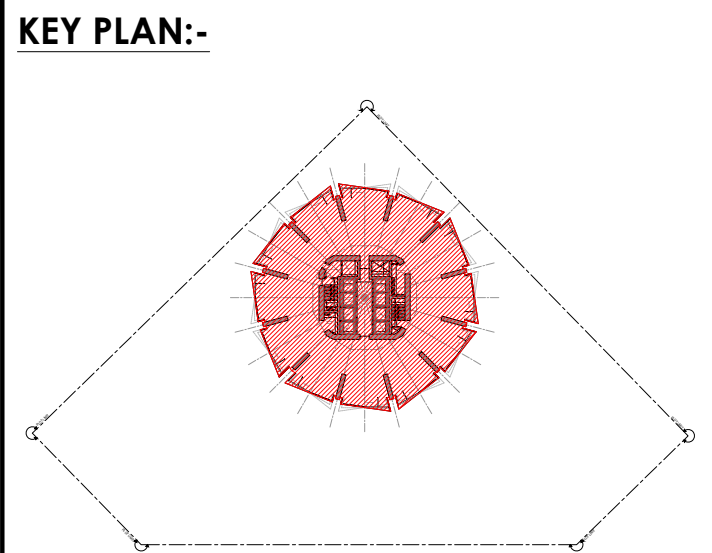

GATE LEVEL PROPOSED = (±0.00 m.) = +15.45 m. DMD LVL.

REV	DATE	DESCRIPTION	CHECK

STATUS : PRELIMINARY SUBMISSION

OWNER: ARGENTI PROPERTIES INVESTMENTS LTD

CONSULTANT: SILVER STONE ENGINEERING CONSULTANTS

PROJECT : BINGHATTI CIRCLE

PLOT NO: JVC13RHRG001 LOCATION: AL BARSHA SOUTH FOURTH(681)


ARCH: AMAR M	STR Engg: M FLAHA
Reg. No: 114763	Reg. No: 109115
SCALE: 1:100	DRAWN: MUS
CHECKED & APPROVED: AM	

DRAWING TITLE: 2ND FLOOR PLAN

PROJECT NO: P025-01	DWG NO: A108	REV: 00
---------------------	--------------	---------

1 2ND FLOOR PLAN
A108 SCALE - 1:100


File Path: X:\Binghatti Project\Process\025-01-Binghatti Circle\01- ARCHITECTURE\01- CONCEPT\01- DWG- Print Date: 12-Jun-25, Time: 10:23:34 AM

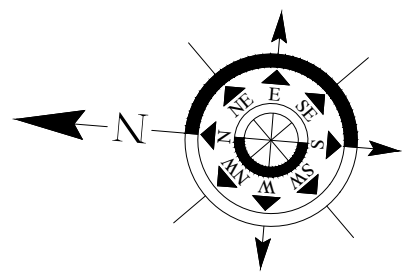

APPROVAL STAMP:

- NOTES:
- 1.) ALL DIMENSIONS TO BE VERIFIED BY CONTRACTOR ON SITE PRIOR TO COMMENCEMENT OF ANY WORK.
 - 2.) DO NOT SCALE THIS DRAWING FOR THE PURPOSE OF MEASUREMENT. ONLY SCALE DIMENSIONS WHERE SPECIFICALLY INSTRUCTED TO DO SO.
 - 3.) ALL MEASUREMENTS ARE IN MILLIMETERS UNLESS OTHERWISE SPECIFIED.
 - 4.) DIMENSIONS SHOWN ON THESE DRAWINGS ARE STRUCTURAL DIMENSIONS UNLESS CLEARLY NOTED OTHERWISE.
 - 5.) THIS DRAWING IS TO BE READ IN CONJUNCTION WITH ALL OTHER DRAWINGS, DETAIL AND SPECIFICATIONS. ANY DISCREPANCY TO BE IMMEDIATELY BROUGHT TO THE ATTENTION OF ARCHITECT PRIOR TO COMMENCING THE WORKS.

KEY PLAN:-

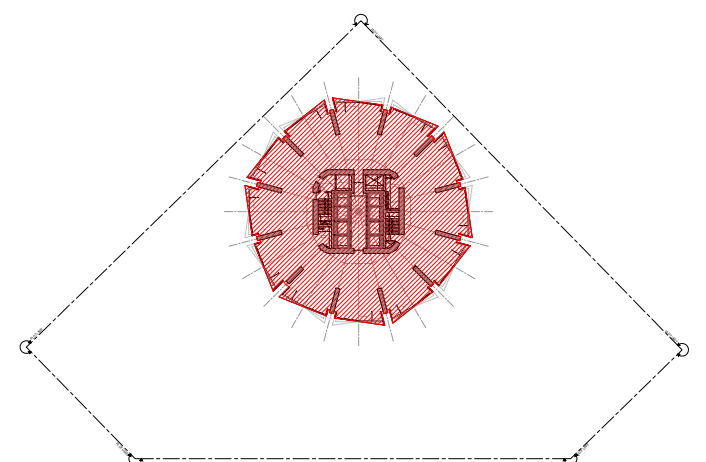

GATE LEVEL PROPOSED = (±0.00 m.) = +15.45 m. DMD LVL.

REV DATE DESCRIPTION CHECK

STATUS:

PRELIMINARY SUBMISSION

OWNER:

ARGENTI PROPERTIES
INVESTMENTS LTD

CONSULTANT:



PROJECT:



BINGHATTI CIRCLE

2B + G + 4P + S8 TYP. FLOORS +3 MECH.+3 STR.+ ROOF

PLOT NO:

JVC13RHRG001

LOCATION:

AL BARSHA SOUTH FOURTH(681)

ARCH: AMAR M STR Engg: M FLAHA

Reg. No: 114763 Reg. No: 109115

SCALE: DRAWN: MUS CHECKED & APPROVED: AM


1:100

DRAWING TITLE:

3RD FLOOR PLAN


PROJECT NO: DWG NO: REV:

P025-01 A109 00

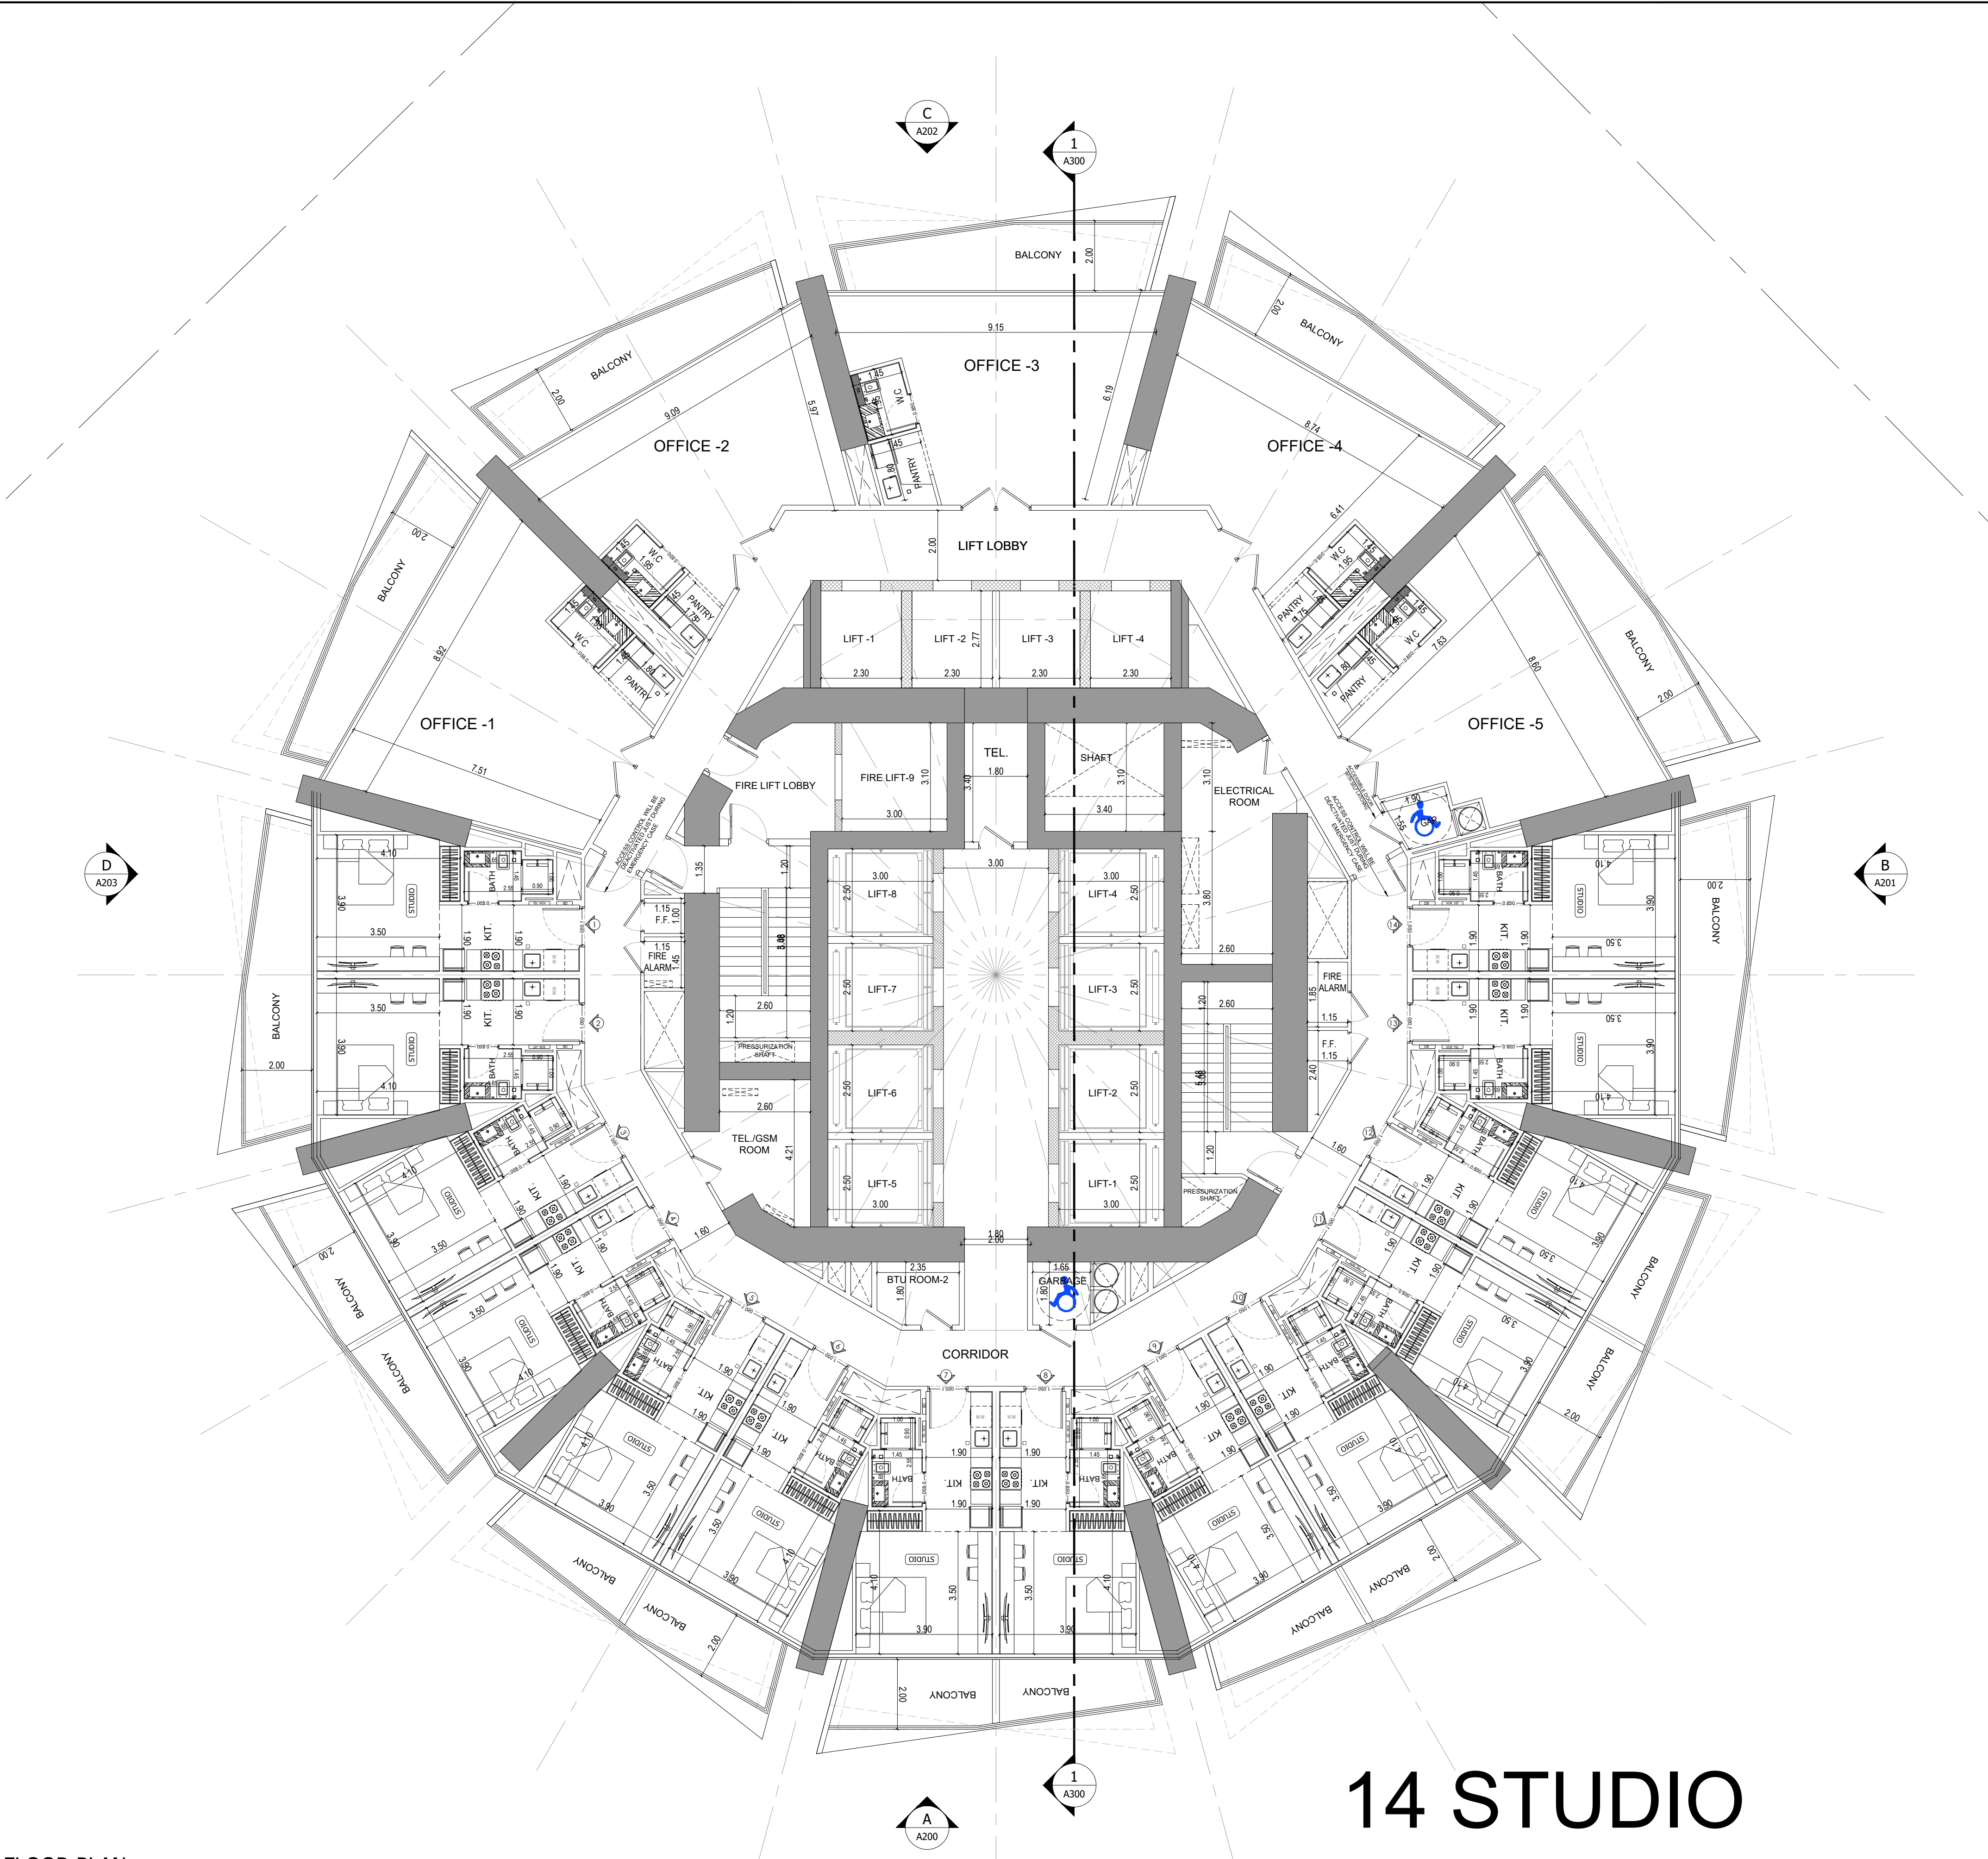

14 STUDIO


1 3RD FLOOR PLAN
A109 SCALE - 1:100

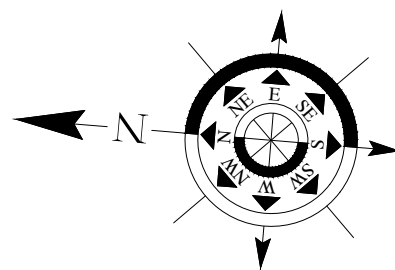

APPROVAL STAMP:

- NOTES:
- 1.) ALL DIMENSIONS TO BE VERIFIED BY CONTRACTOR ON SITE PRIOR TO COMMENCEMENT OF ANY WORK.
 - 2.) DO NOT SCALE THIS DRAWING FOR THE PURPOSE OF MEASUREMENT. ONLY SCALE DIMENSIONS WHERE SPECIFICALLY INSTRUCTED TO DO SO.
 - 3.) ALL MEASUREMENTS ARE IN MILLIMETERS UNLESS OTHERWISE SPECIFIED.
 - 4.) DIMENSIONS SHOWN ON THESE DRAWINGS ARE STRUCTURAL DIMENSIONS UNLESS CLEARLY NOTED OTHERWISE.
 - 5.) THIS DRAWING IS TO BE READ IN CONJUNCTION WITH ALL OTHER DRAWINGS, DETAIL AND SPECIFICATIONS. ANY DISCREPANCY TO BE IMMEDIATELY BROUGHT TO THE ATTENTION OF ARCHITECT PRIOR TO COMMENCING THE WORKS.

KEY PLAN:-

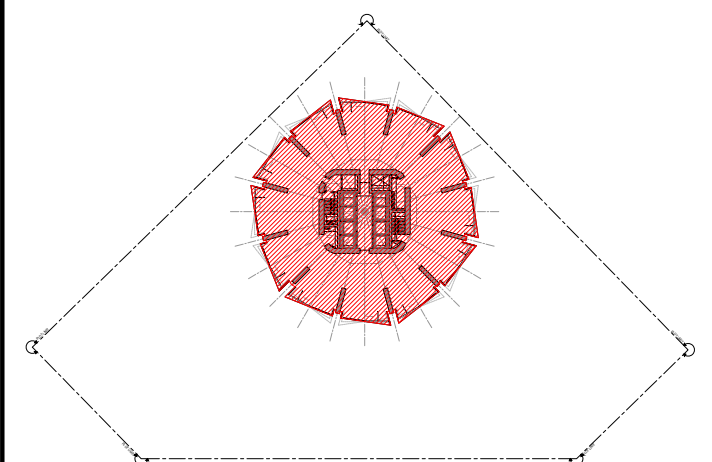

GATE LEVEL PROPOSED = (±0.00 m.) = +15.45 m. DMD LVL.

REV DATE DESCRIPTION CHECK

STATUS:

PRELIMINARY SUBMISSION

OWNER:

ARGENTI PROPERTIES
INVESTMENTS LTD

CONSULTANT:



PROJECT:



BINGHATTI CIRCLE

2B + G + 4P + S8 TYP. FLOORS +3 MECH.+3 STR.+ ROOF

PLOT NO:

JVC13RHRG001

LOCATION:

AL BARSHA SOUTH FOURTH(681)

ARCH: AMAR M

STR Engg: M FLAHA

Reg. No: 114763

Reg. No: 109115

SCALE: DRAWN: MUS

CHECKED & APPROVED: AM

1:100

DRAWING TITLE:

4TH FLOOR PLAN

PROJECT NO:


P025-01

DWG NO:

A110


REV:

00

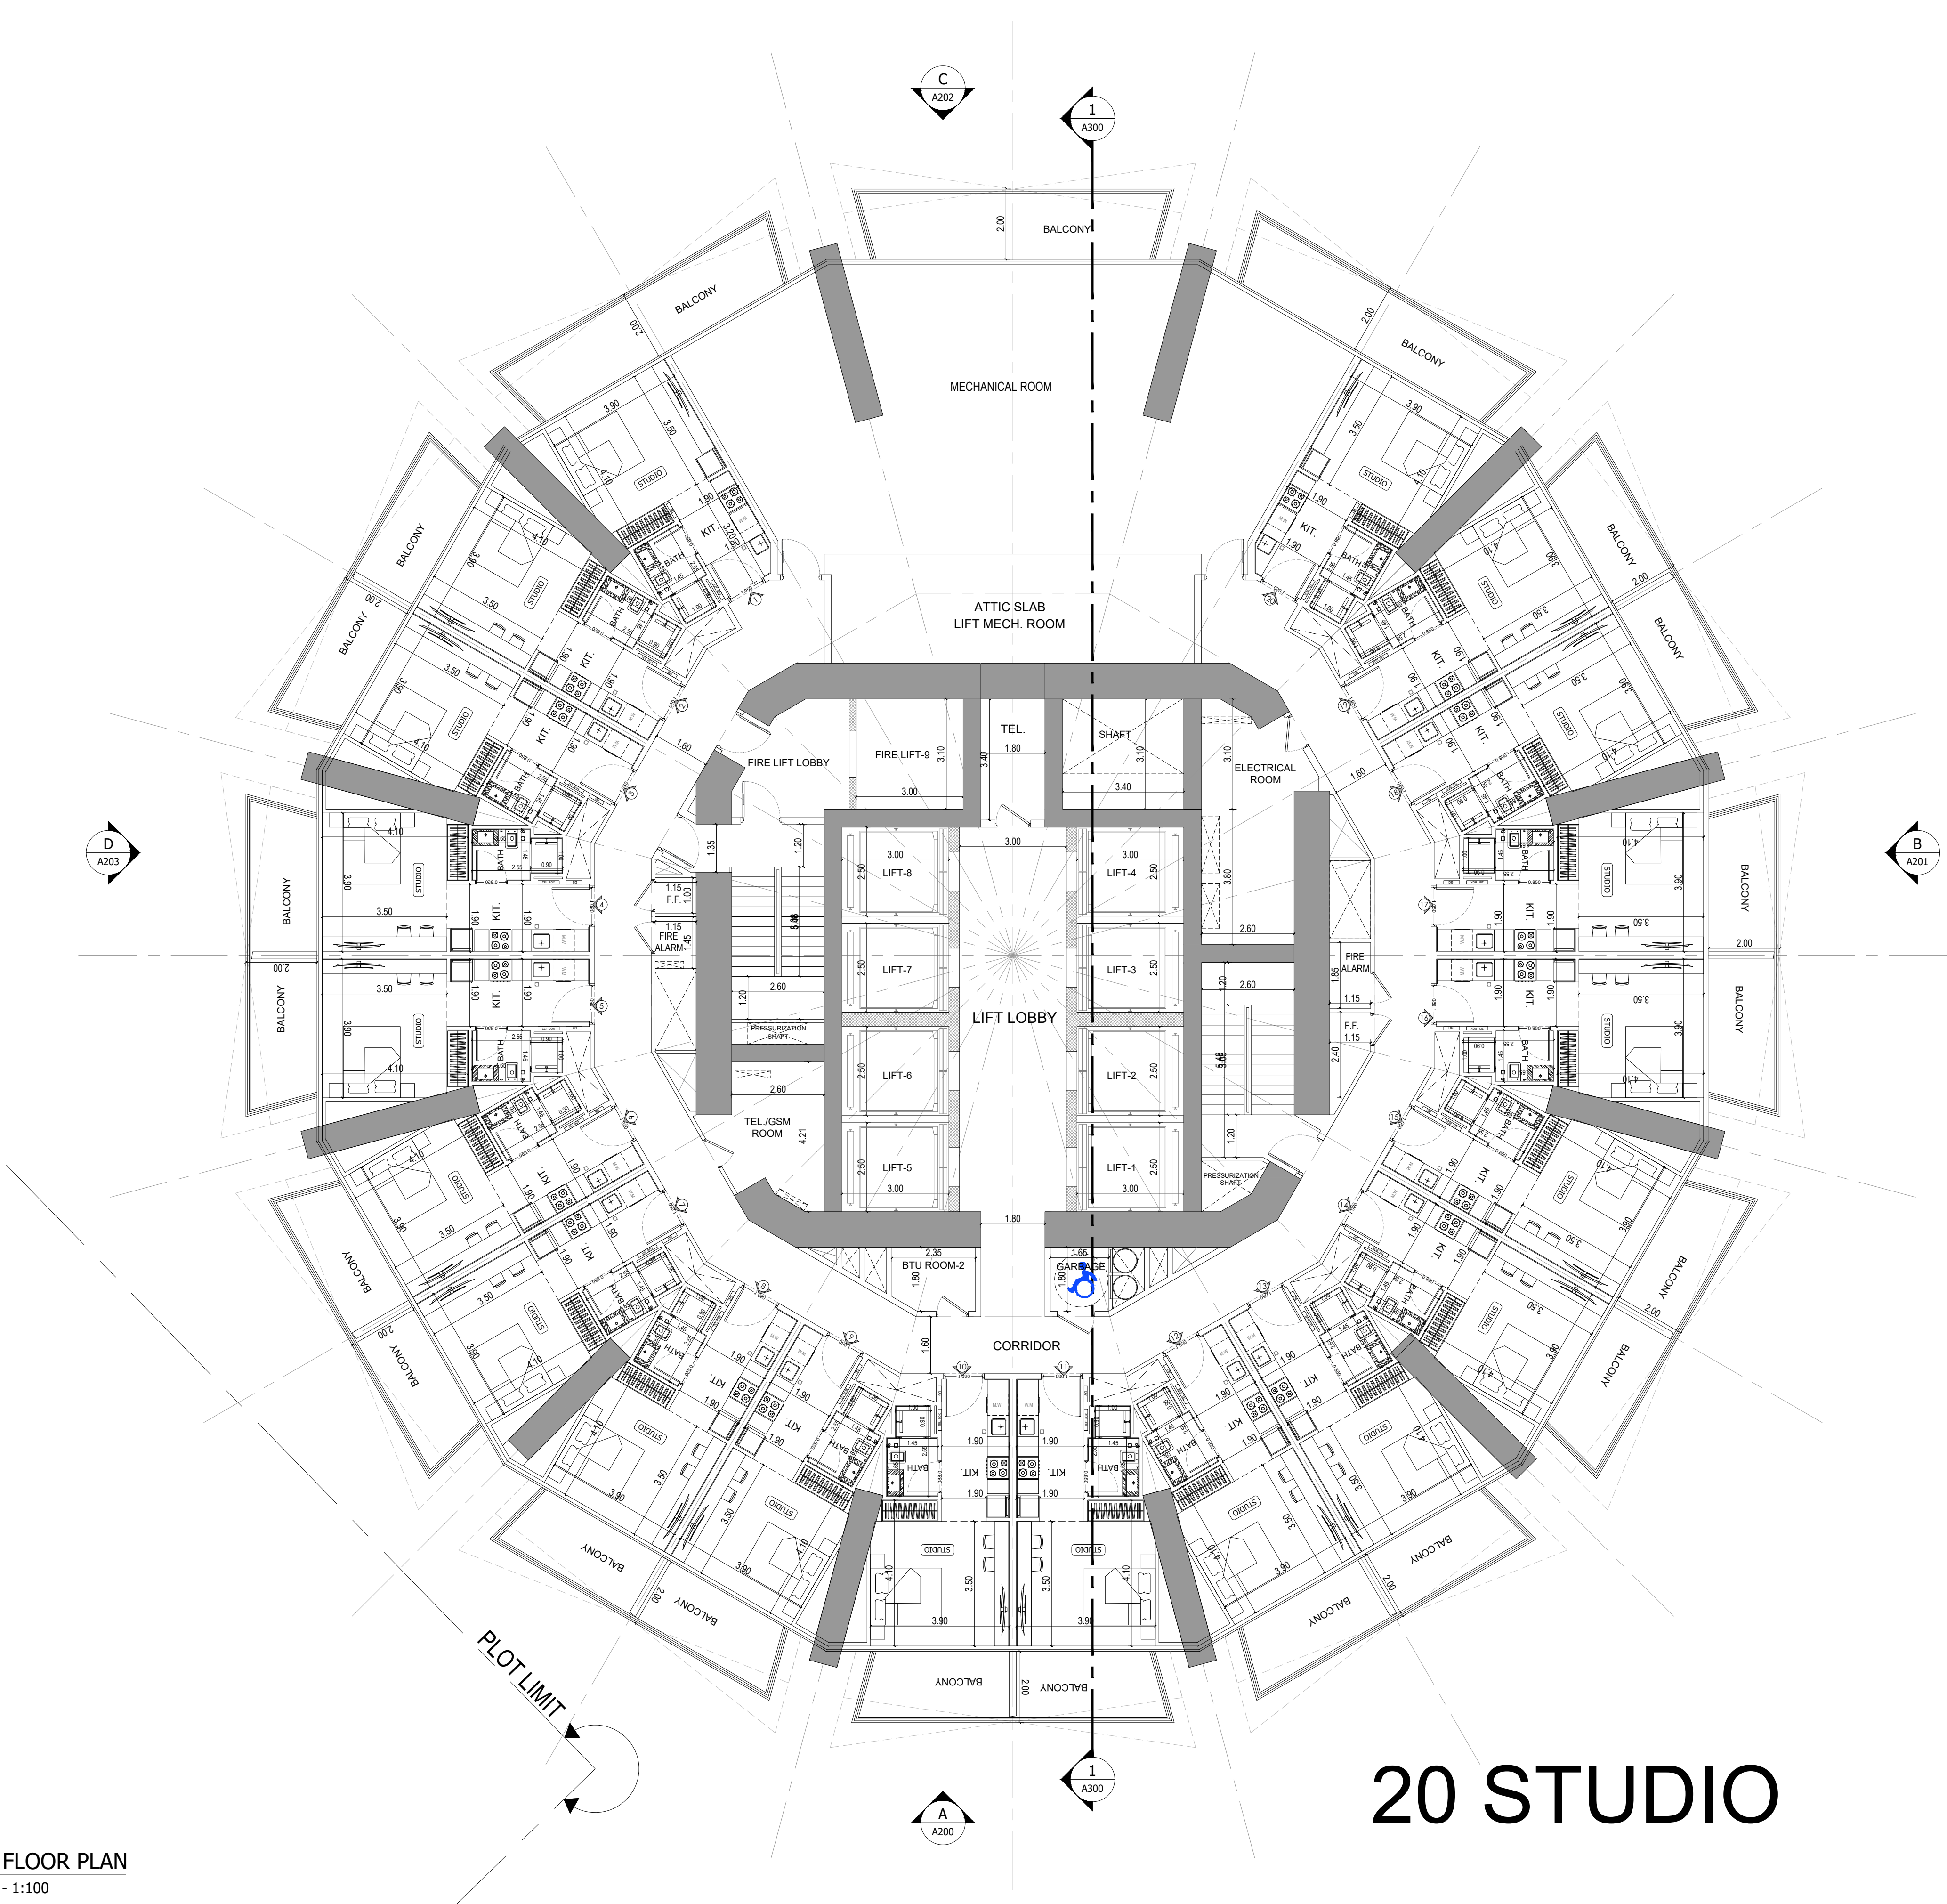

20 STUDIO

1 4TH FLOOR PLAN
A110 SCALE - 1:100

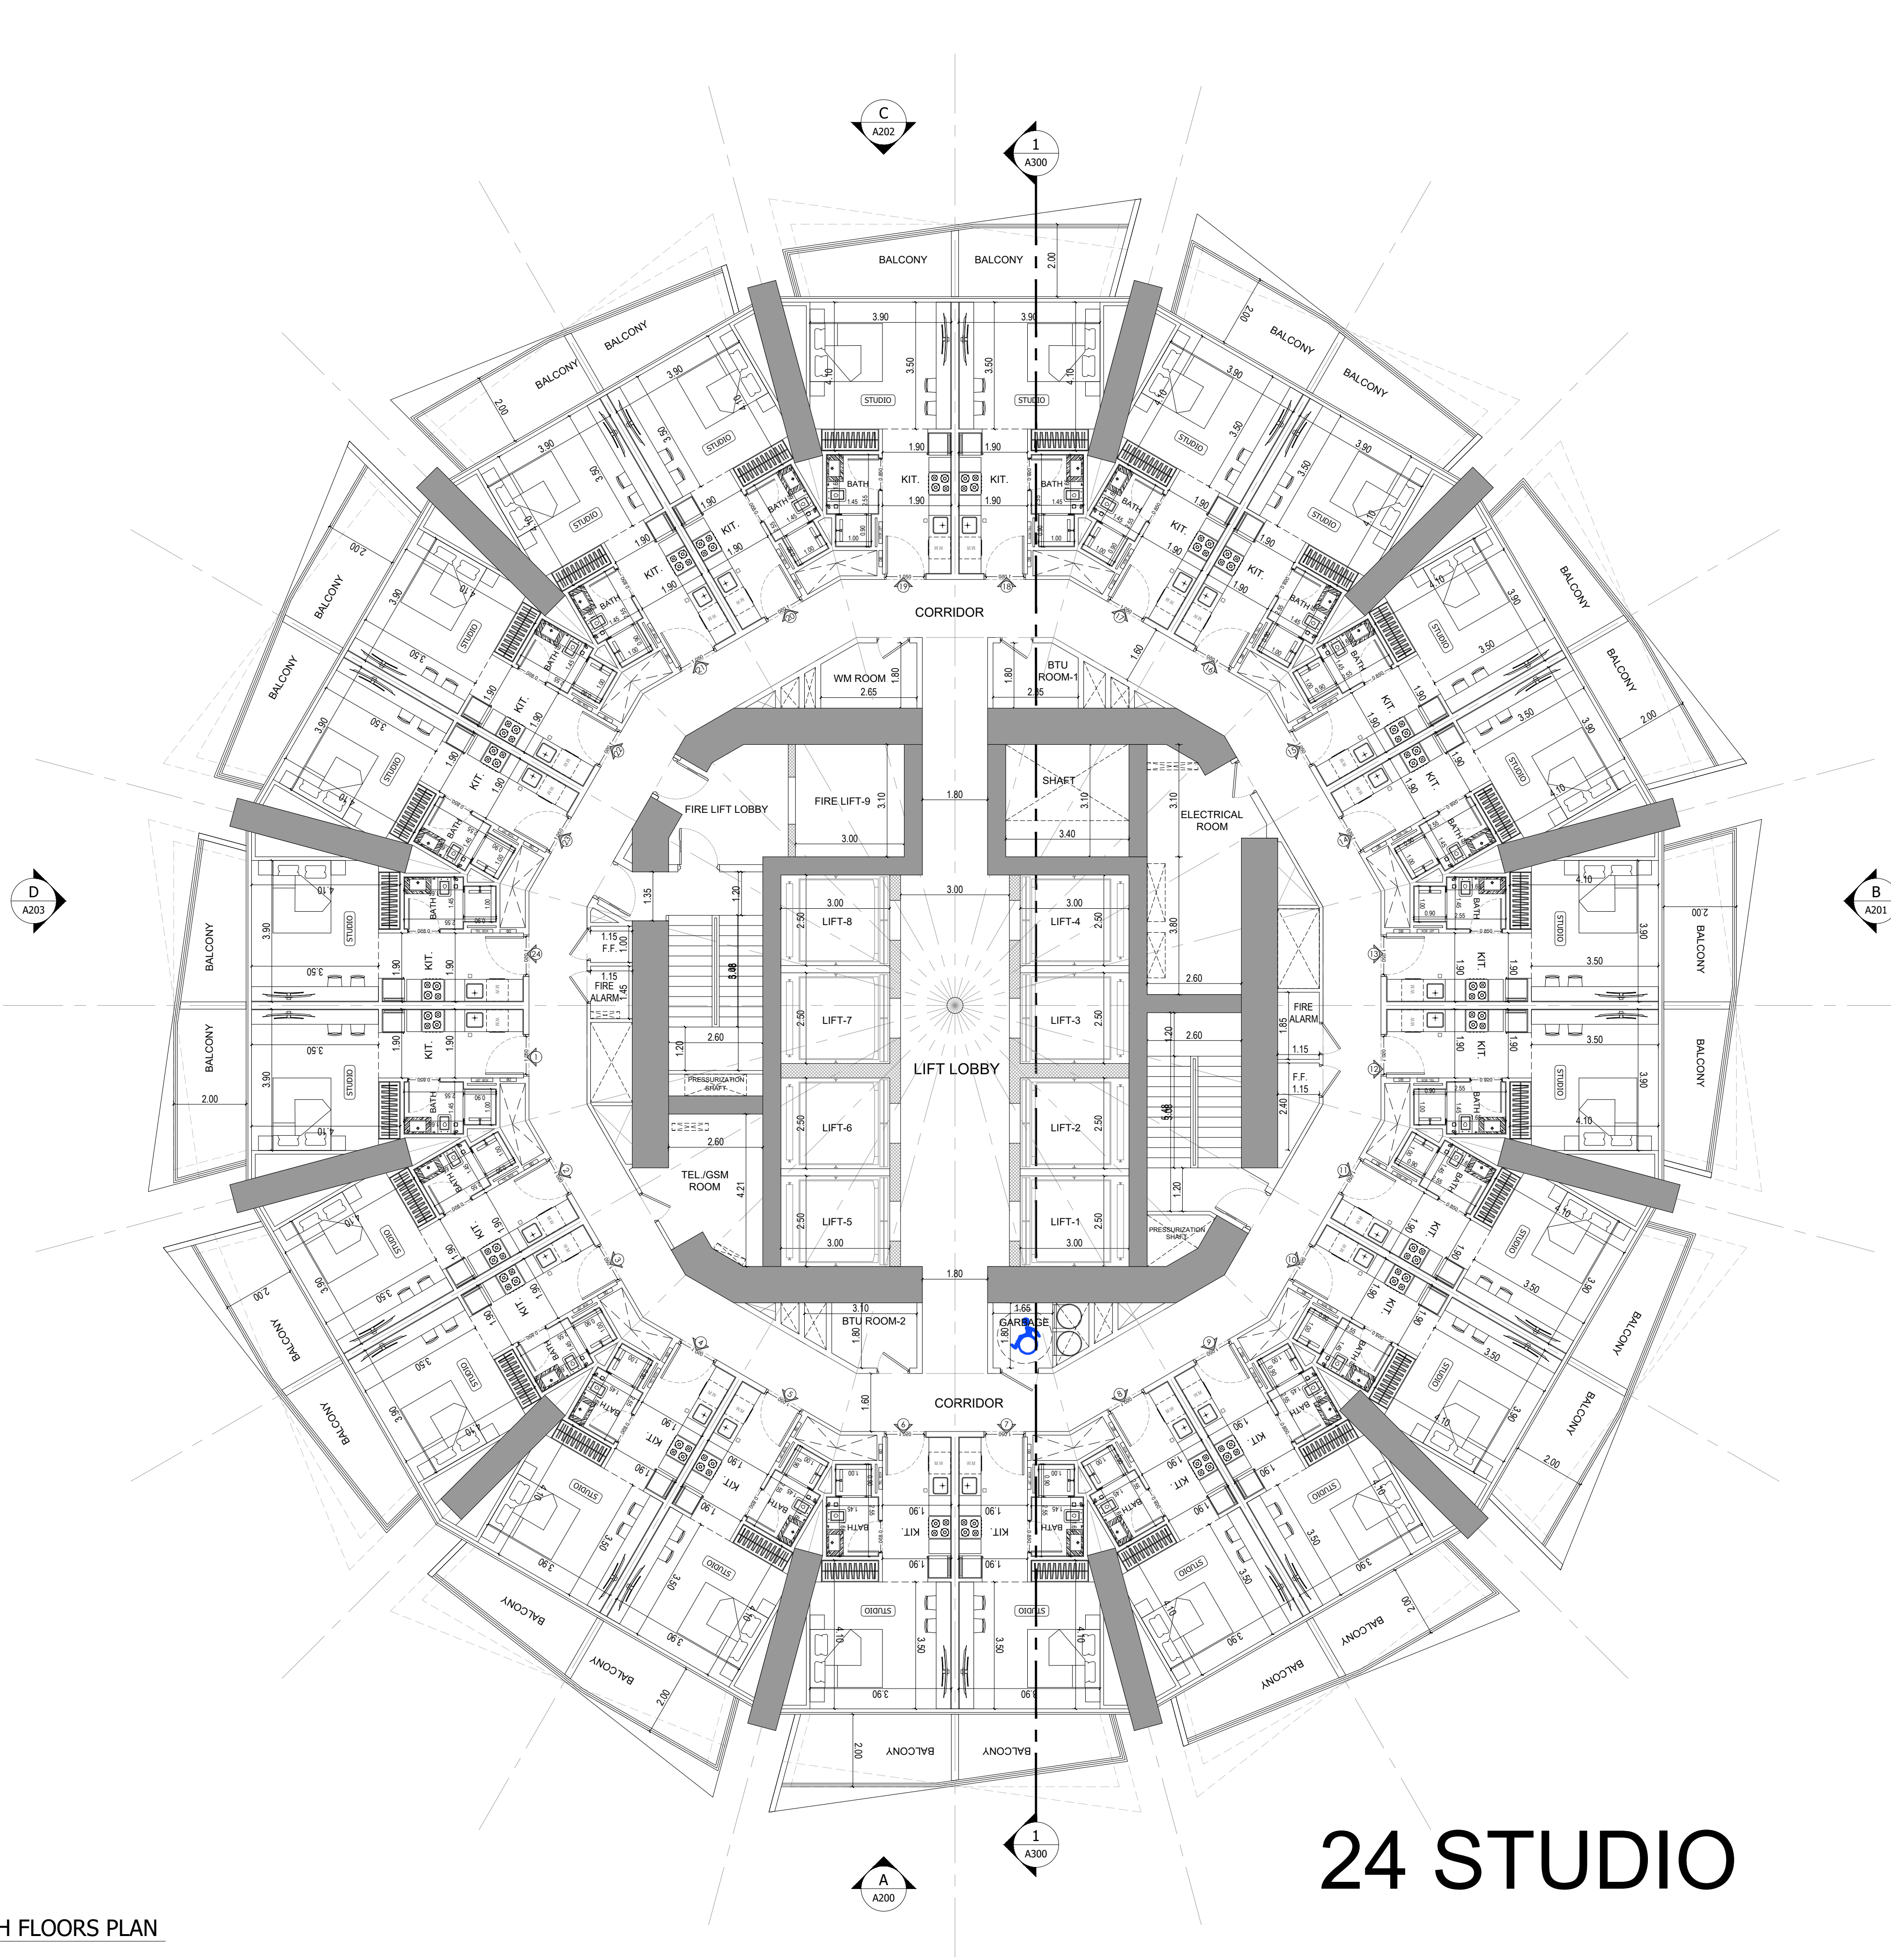


24 STUDIO

1 7,11 & 15TH FLOORS PLAN
A111 SCALE - 1:100

APPROVAL STAMP:

NOTES:

- 1.) ALL DIMENSIONS TO BE VERIFIED BY CONTRACTOR ON SITE PRIOR TO COMMENCEMENT OF ANY WORK.
- 2.) DO NOT SCALE THIS DRAWING FOR THE PURPOSE OF MEASUREMENT. ONLY SCALE DIMENSIONS WHERE SPECIFICALLY INSTRUCTED TO DO SO.
- 3.) ALL MEASUREMENTS ARE IN MILLIMETERS UNLESS OTHERWISE SPECIFIED.
- 4.) DIMENSIONS SHOWN ON THESE DRAWINGS ARE STRUCTURAL DIMENSIONS UNLESS CLEARLY NOTED OTHERWISE.
- 5.) THIS DRAWING IS TO BE READ IN CONJUNCTION WITH ALL OTHER DRAWINGS, DETAIL AND SPECIFICATIONS. ANY DISCREPANCY TO BE IMMEDIATELY BROUGHT TO THE ATTENTION OF ARCHITECT PRIOR TO COMMENCING THE WORKS.

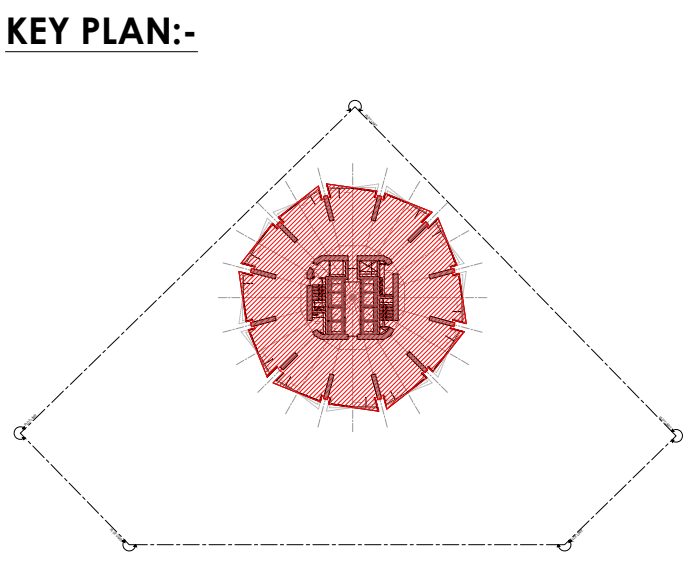

GATE LEVEL PROPOSED = (±0.00 m.) = +15.45 m. DMD LVL.

REV	DATE	DESCRIPTION	CHECK
-----	------	-------------	-------

STATUS:

PRELIMINARY SUBMISSION

OWNER:

ARGENTI PROPERTIES INVESTMENTS LTD



PROJECT:

BINGHATTI CIRCLE
2B + G + 4P + S8 TYP. FLOORS +3 MECH.+3 STR.+ ROOF



LOCATON:	AL BARSHA SOUTH FOURTH(681)
ARCH:	AMAR M
STR Engg:	M FLAHA
Reg. No:	114763
Reg. No:	109115
SCALE:	DRAWN: MUS
CHECKED & APPROVED:	AM

1:100

DRAWING TITLE:


7,11 & 15TH FLOORS PLAN

PROJECT NO:	DWG NO:	REV:
P025-01	A111	00

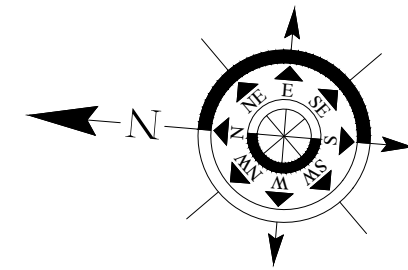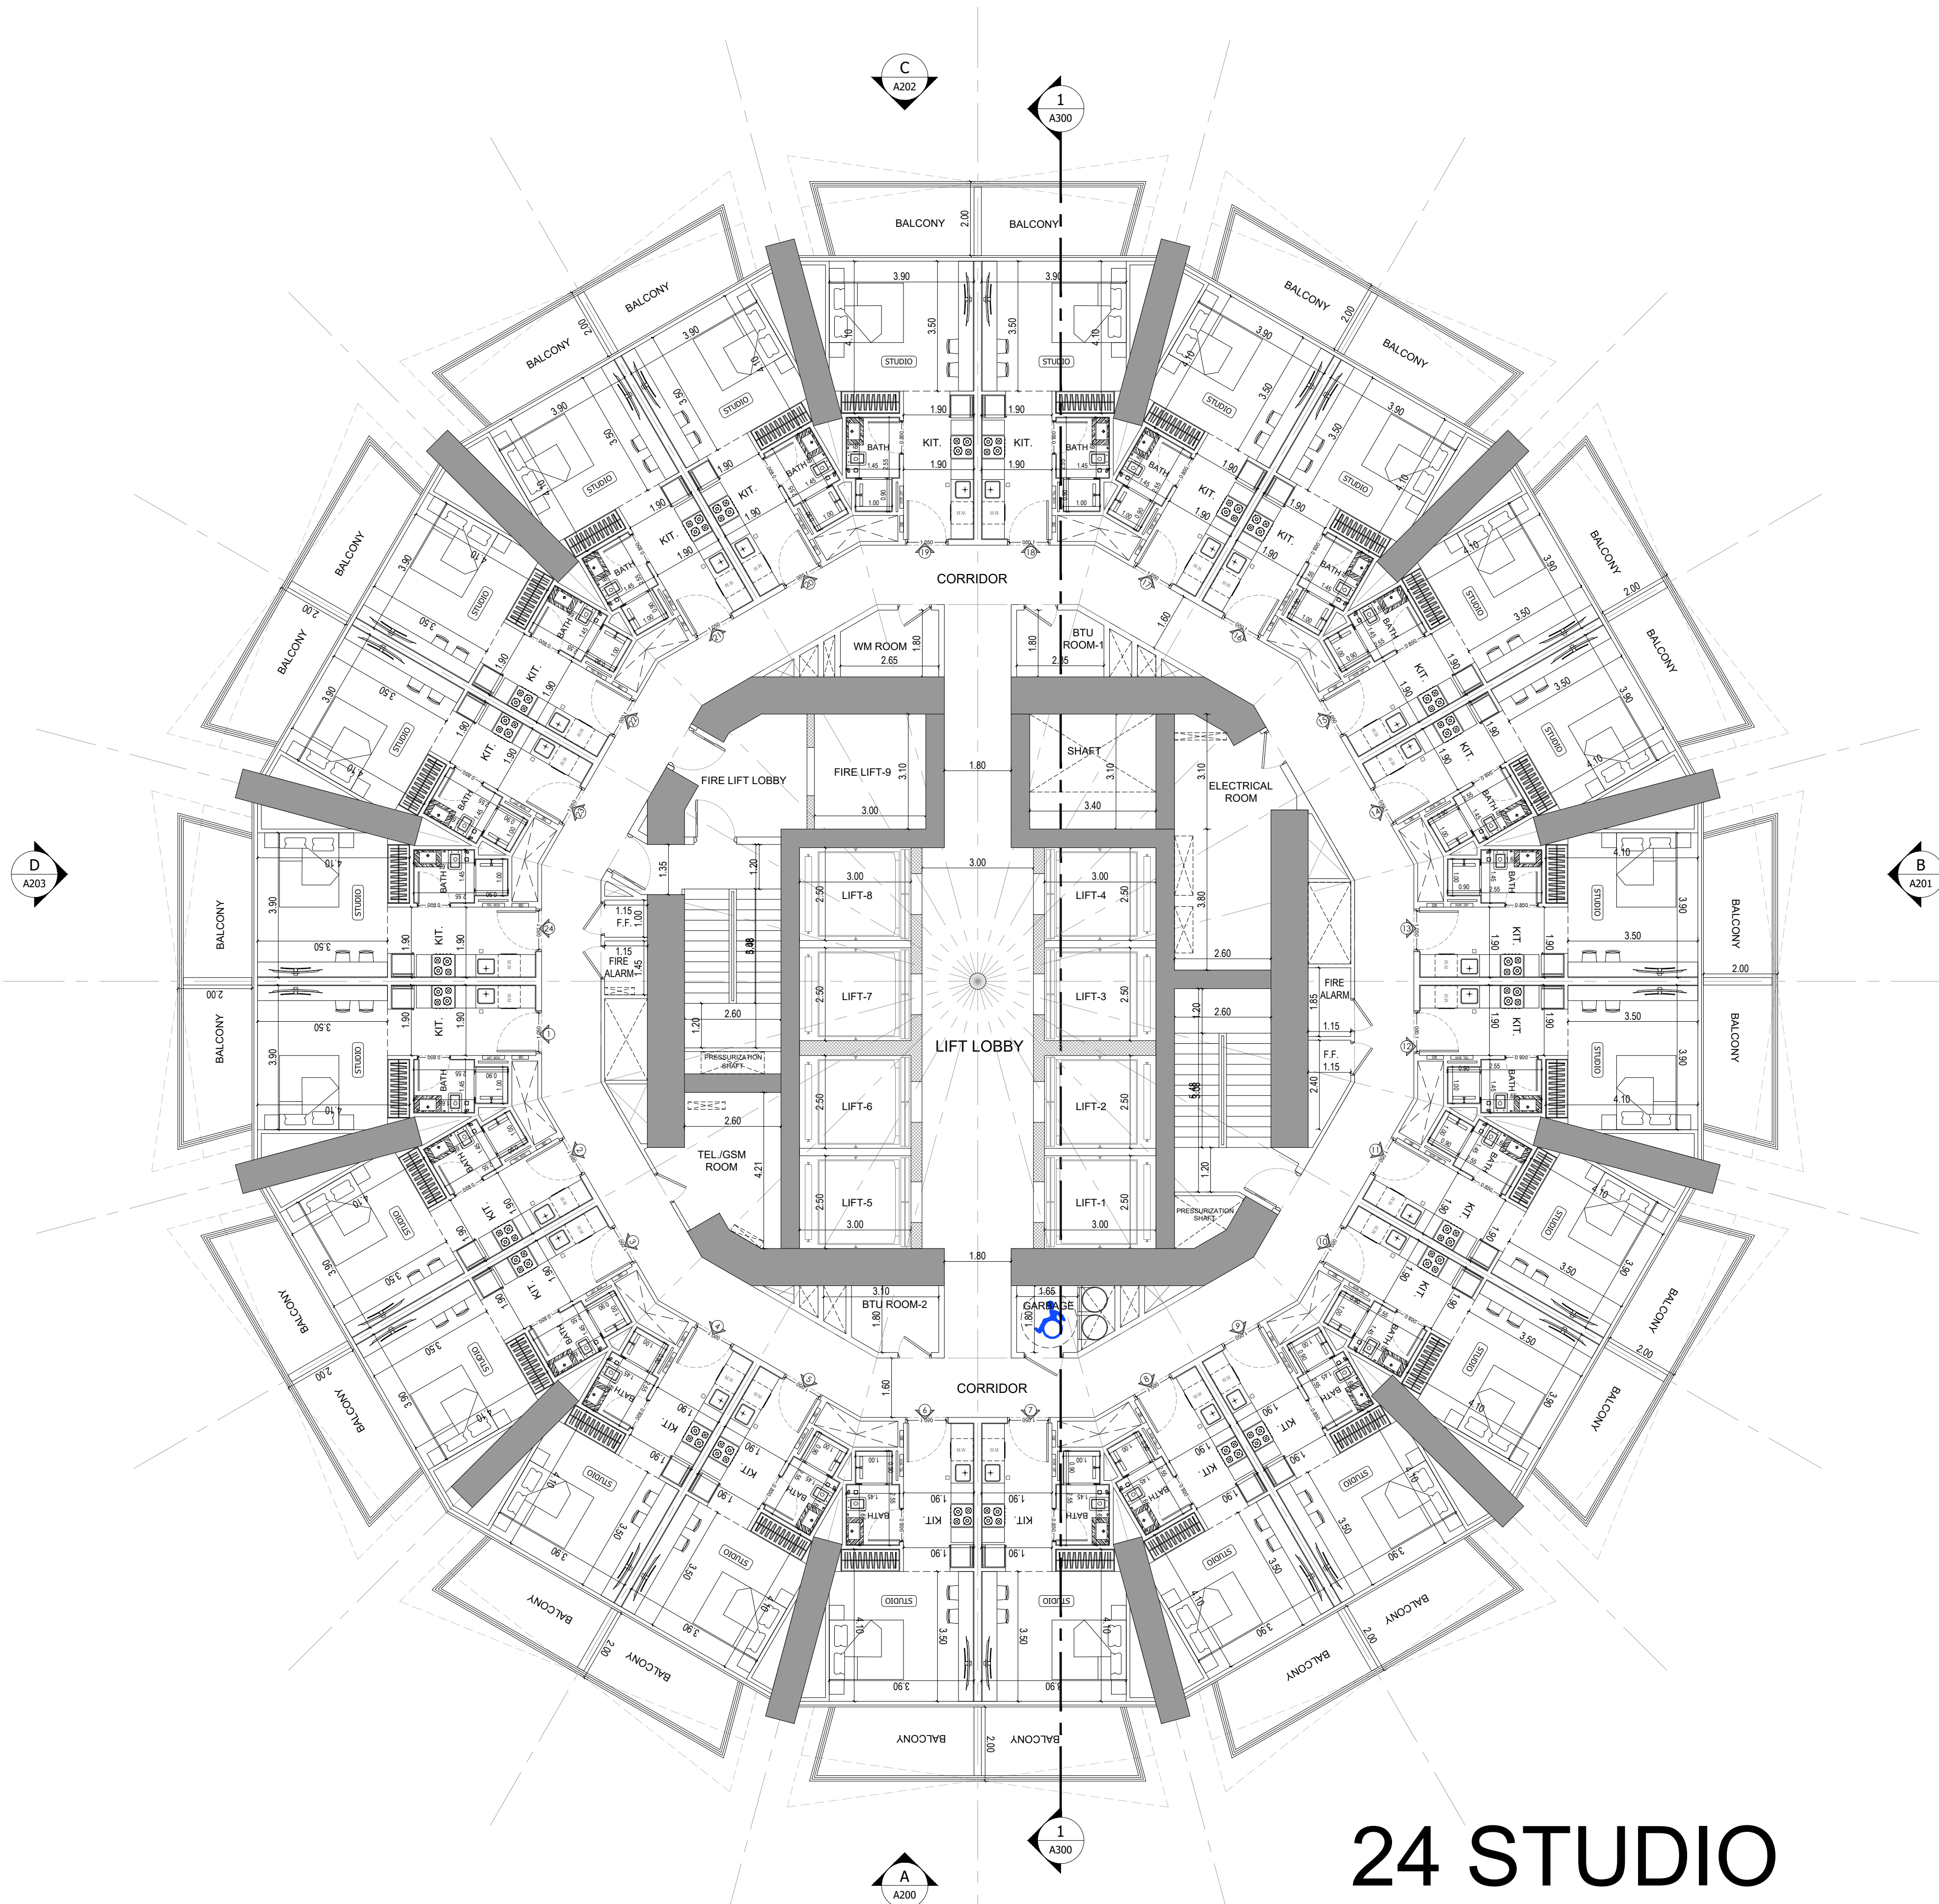

- APPROVAL STAMP:
- NOTES:
- 1.) ALL DIMENSIONS TO BE VERIFIED BY CONTRACTOR ON SITE PRIOR TO COMMENCEMENT OF ANY WORK.
 - 2.) DO NOT SCALE THIS DRAWING FOR THE PURPOSE OF MEASUREMENT. ONLY SCALE DIMENSIONS WHERE SPECIFICALLY INSTRUCTED TO DO SO.
 - 3.) ALL MEASUREMENTS ARE IN MILLIMETERS UNLESS OTHERWISE SPECIFIED.
 - 4.) DIMENSIONS SHOWN ON THESE DRAWINGS ARE STRUCTURAL DIMENSIONS UNLESS CLEARLY NOTED OTHERWISE.
 - 5.) THIS DRAWING IS TO BE READ IN CONJUNCTION WITH ALL OTHER DRAWINGS, DETAIL AND SPECIFICATIONS. ANY DISCREPANCY TO BE IMMEDIATELY BROUGHT TO THE ATTENTION OF ARCHITECT PRIOR TO COMMENCING THE WORKS.

KEY PLAN:-

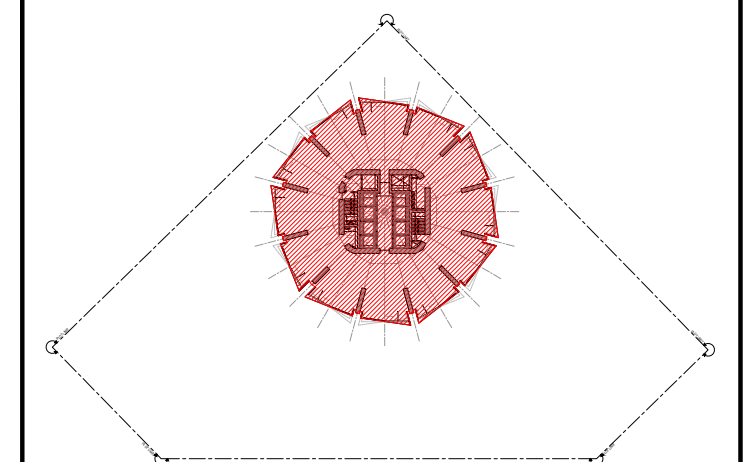

GATE LEVEL PROPOSED = (±0.00 m.) = +15.45 m. DMD LVL.

REV DATE DESCRIPTION CHECK

STATUS:

PRELIMINARY SUBMISSION

OWNER:

ARGENTI PROPERTIES INVESTMENTS LTD

CONSULTANT:



PROJECT:

BINGHATTI BINGHATTI CIRCLE

2B + G + 4P + 58 TYP. FLOORS +3 MECH.+3 STR.+ ROOF

PLOT NO: JVC13RHRG001 LOCATION: AL BARSHA SOUTH FOURTH(681)

ARCH: AMAR M STR Engg: M FLAHA

Reg. No: 114763 Reg. No: 109115

SCALE: DRAWN: MUS CHECKED & APPROVED: AM

1:100



DRAWING TITLE:

6,10,12 & 14TH FLOORS PLAN

PROJECT NO: P025-01 DWG NO: A112 REV: 00

1 6,10,12 & 14TH FLOORS PLAN
A112 SCALE - 1:100


24 STUDIO

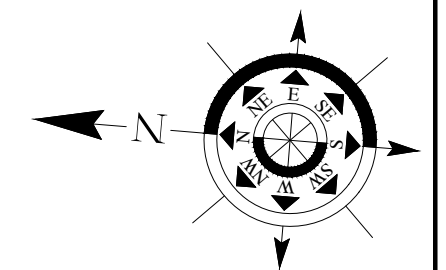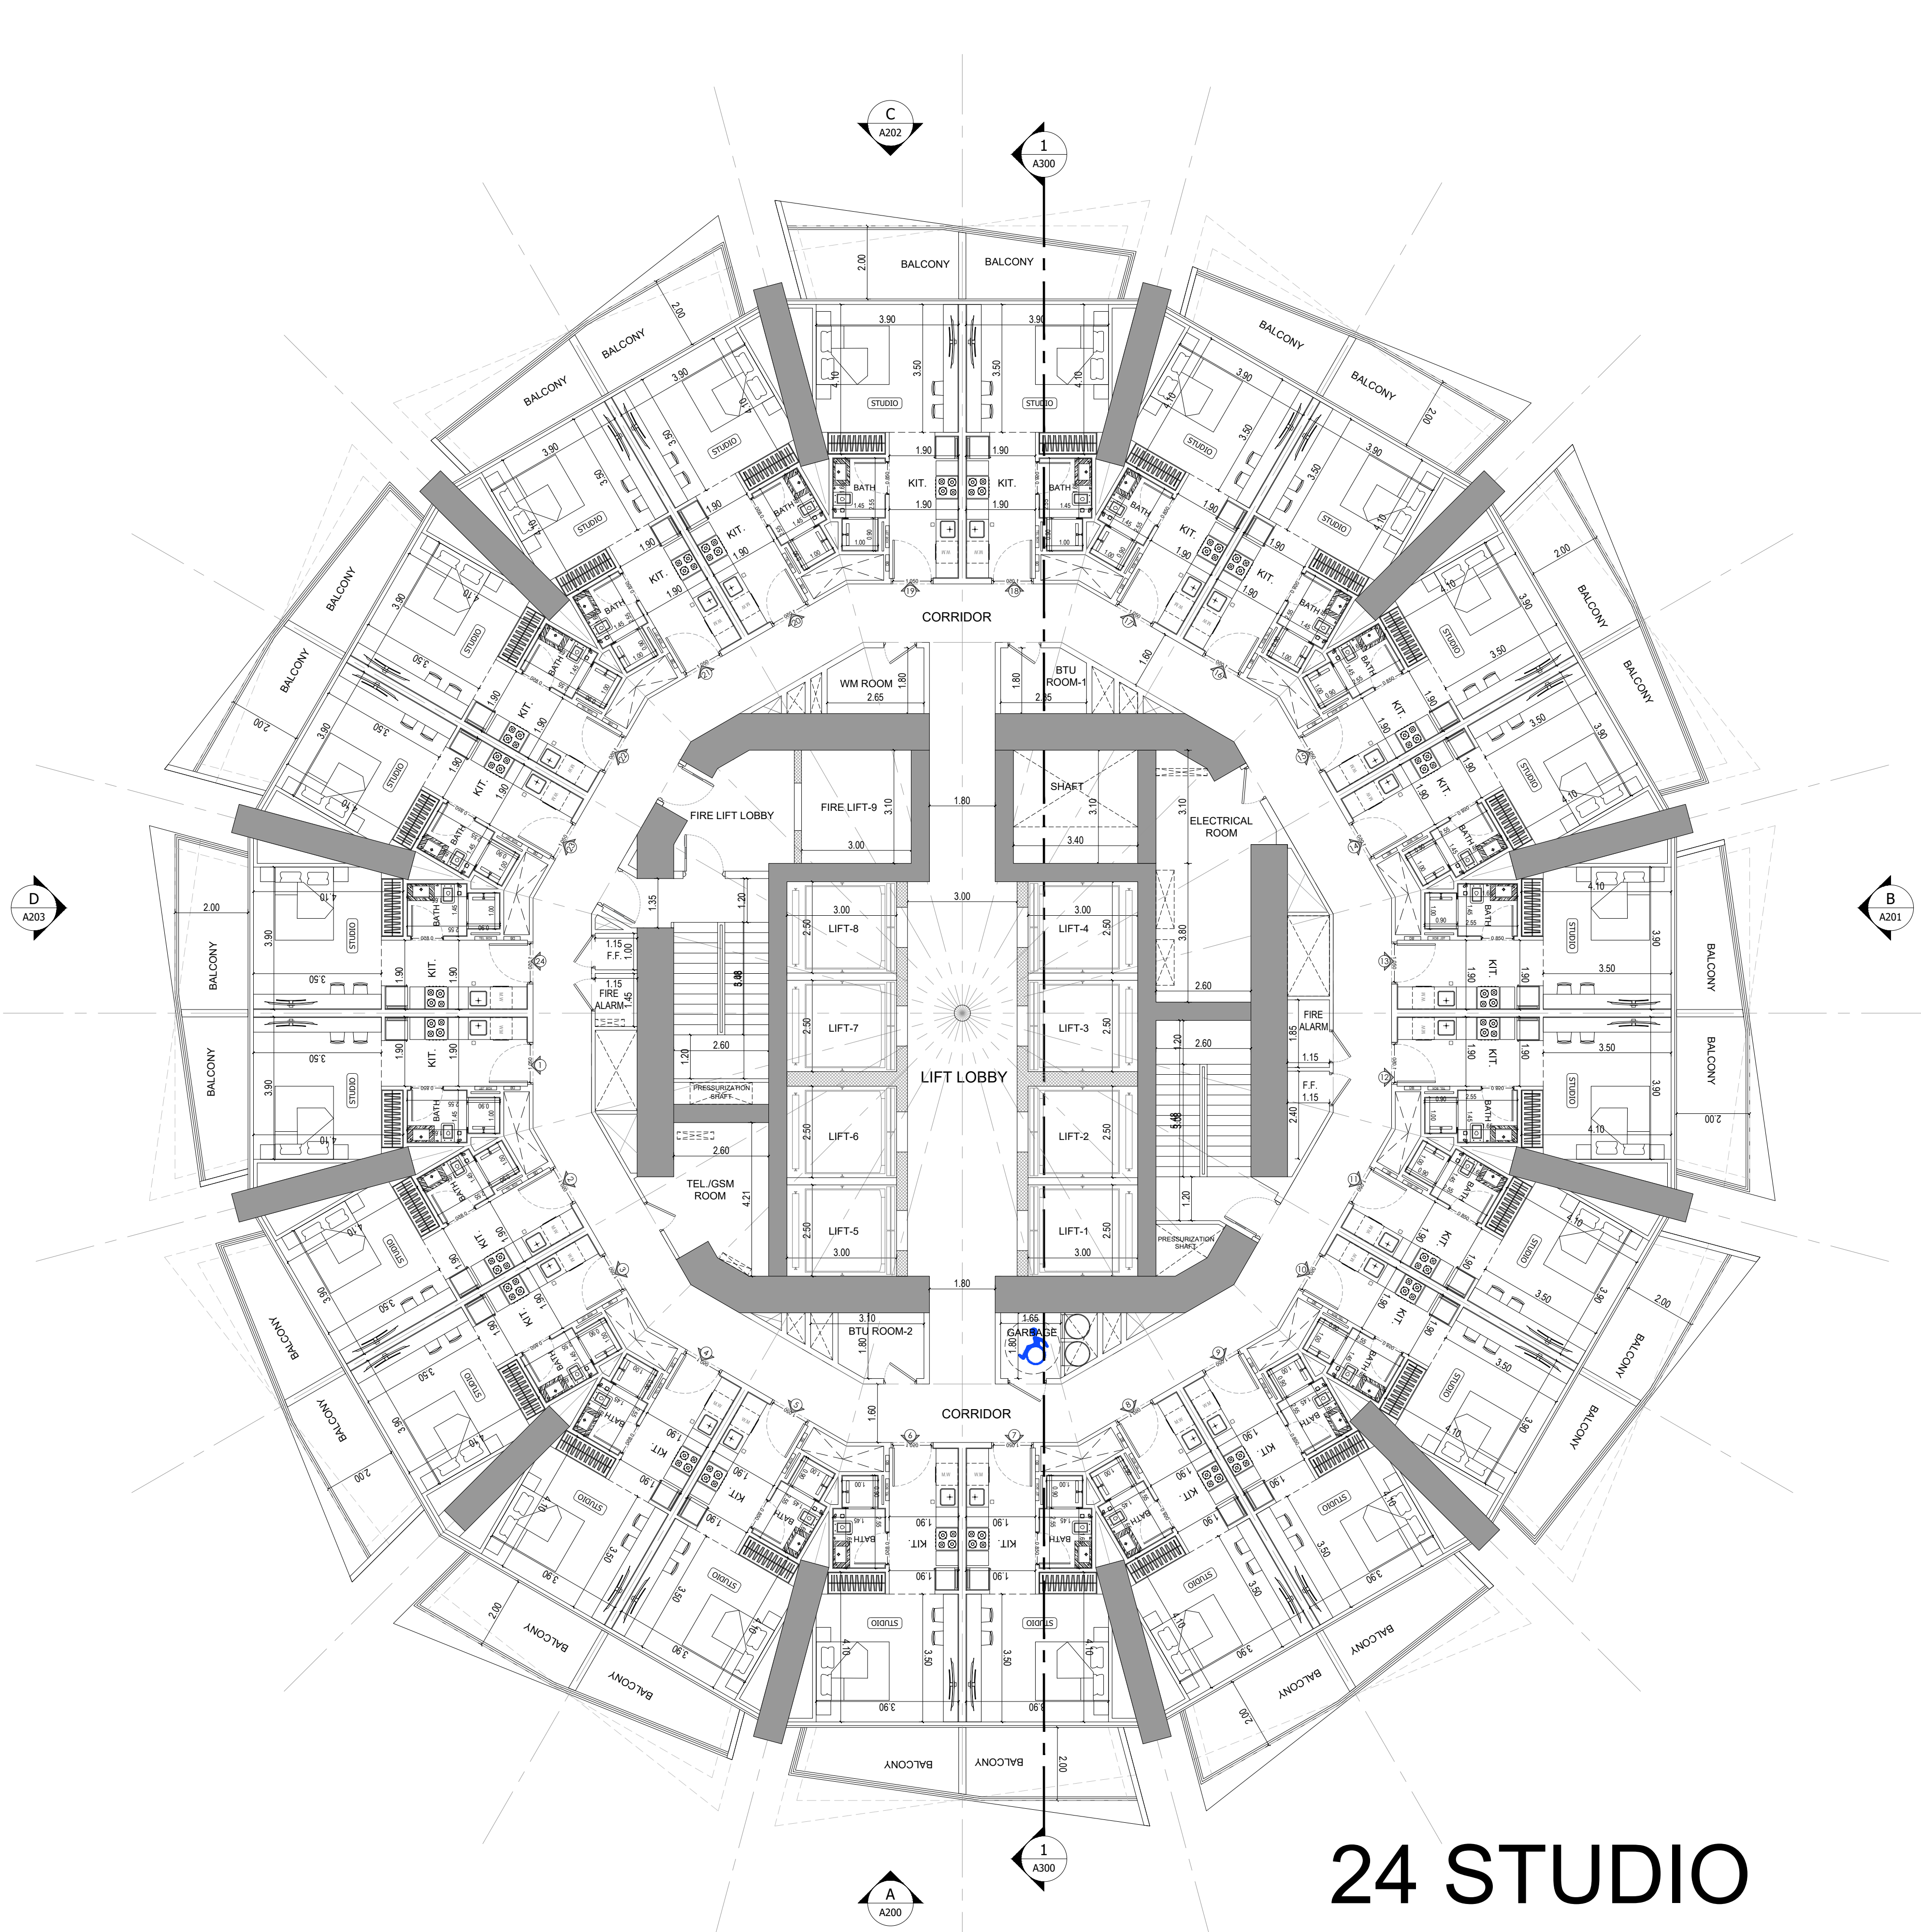

APPROVAL STAMP:

NOTES:

- 1.) ALL DIMENSIONS TO BE VERIFIED BY CONTRACTOR ON SITE PRIOR TO COMMENCEMENT OF ANY WORK.
- 2.) DO NOT SCALE THIS DRAWING FOR THE PURPOSE OF MEASUREMENT. ONLY SCALE DIMENSIONS WHERE SPECIFICALLY INSTRUCTED TO DO SO.
- 3.) ALL MEASUREMENTS ARE IN MILLIMETERS UNLESS OTHERWISE SPECIFIED.
- 4.) DIMENSIONS SHOWN ON THESE DRAWINGS ARE STRUCTURAL DIMENSIONS UNLESS CLEARLY NOTED OTHERWISE.
- 5.) THIS DRAWING IS TO BE READ IN CONJUNCTION WITH ALL OTHER DRAWINGS, DETAIL AND SPECIFICATIONS. ANY DISCREPANCY TO BE IMMEDIATELY BROUGHT TO THE ATTENTION OF ARCHITECT PRIOR TO COMMENCING THE WORKS.

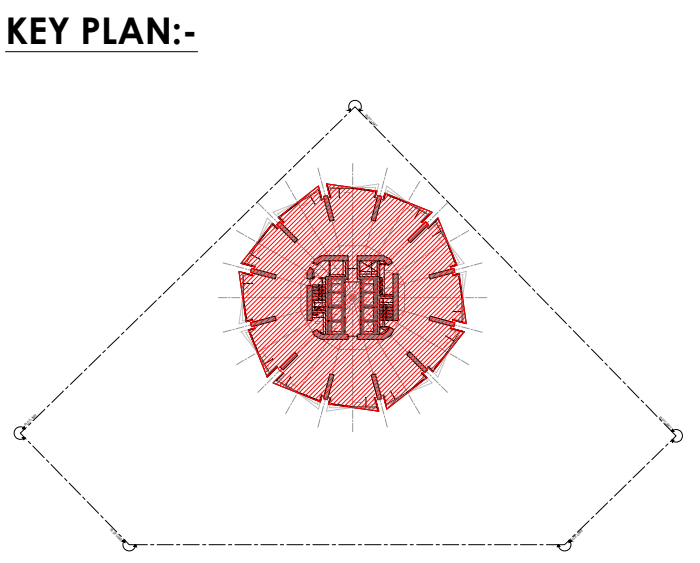

GATE LEVEL PROPOSED = (±0.00 m.) = +15.45 m. DMD LVL.

REV	DATE	DESCRIPTION	CHECK

STATUS: PRELIMINARY SUBMISSION

OWNER: ARGENTI PROPERTIES INVESTMENTS LTD

CONSULTANT: SILVER STONE ENGINEERING CONSULTANTS

PROJECT: BINGHATTI CIRCLE
2B + G + 4P + S8 TYP. FLOORS +3 MECH.+3 STR.+ ROOF

PLOT NO: JVC13RHRG001	LOCATION: AL BARSHA SOUTH FOURTH(681)
ARCH: AMAR M	STR Engg: M FLAHA
Reg. No: 114763	Reg. No: 109115
SCALE: 1:100	DRAWN: MUS
CHECKED & APPROVED: AM	


DRAWING TITLE: 5TH & 13TH FLOORS PLAN

PROJECT NO: P025-01	DWG NO: A113	REV: 00
------------------------	-----------------	------------

1 5TH & 13TH FLOORS PLAN
A113 SCALE - 1:100


24 STUDIO

File Path: X:\Binghatti Project\2025-01-Binghatti Circle\01- ARCHITECTURE\01- CONCEPT\01- DWG- Print Date: 12-Jun-25, Time: 10:23:34 AM

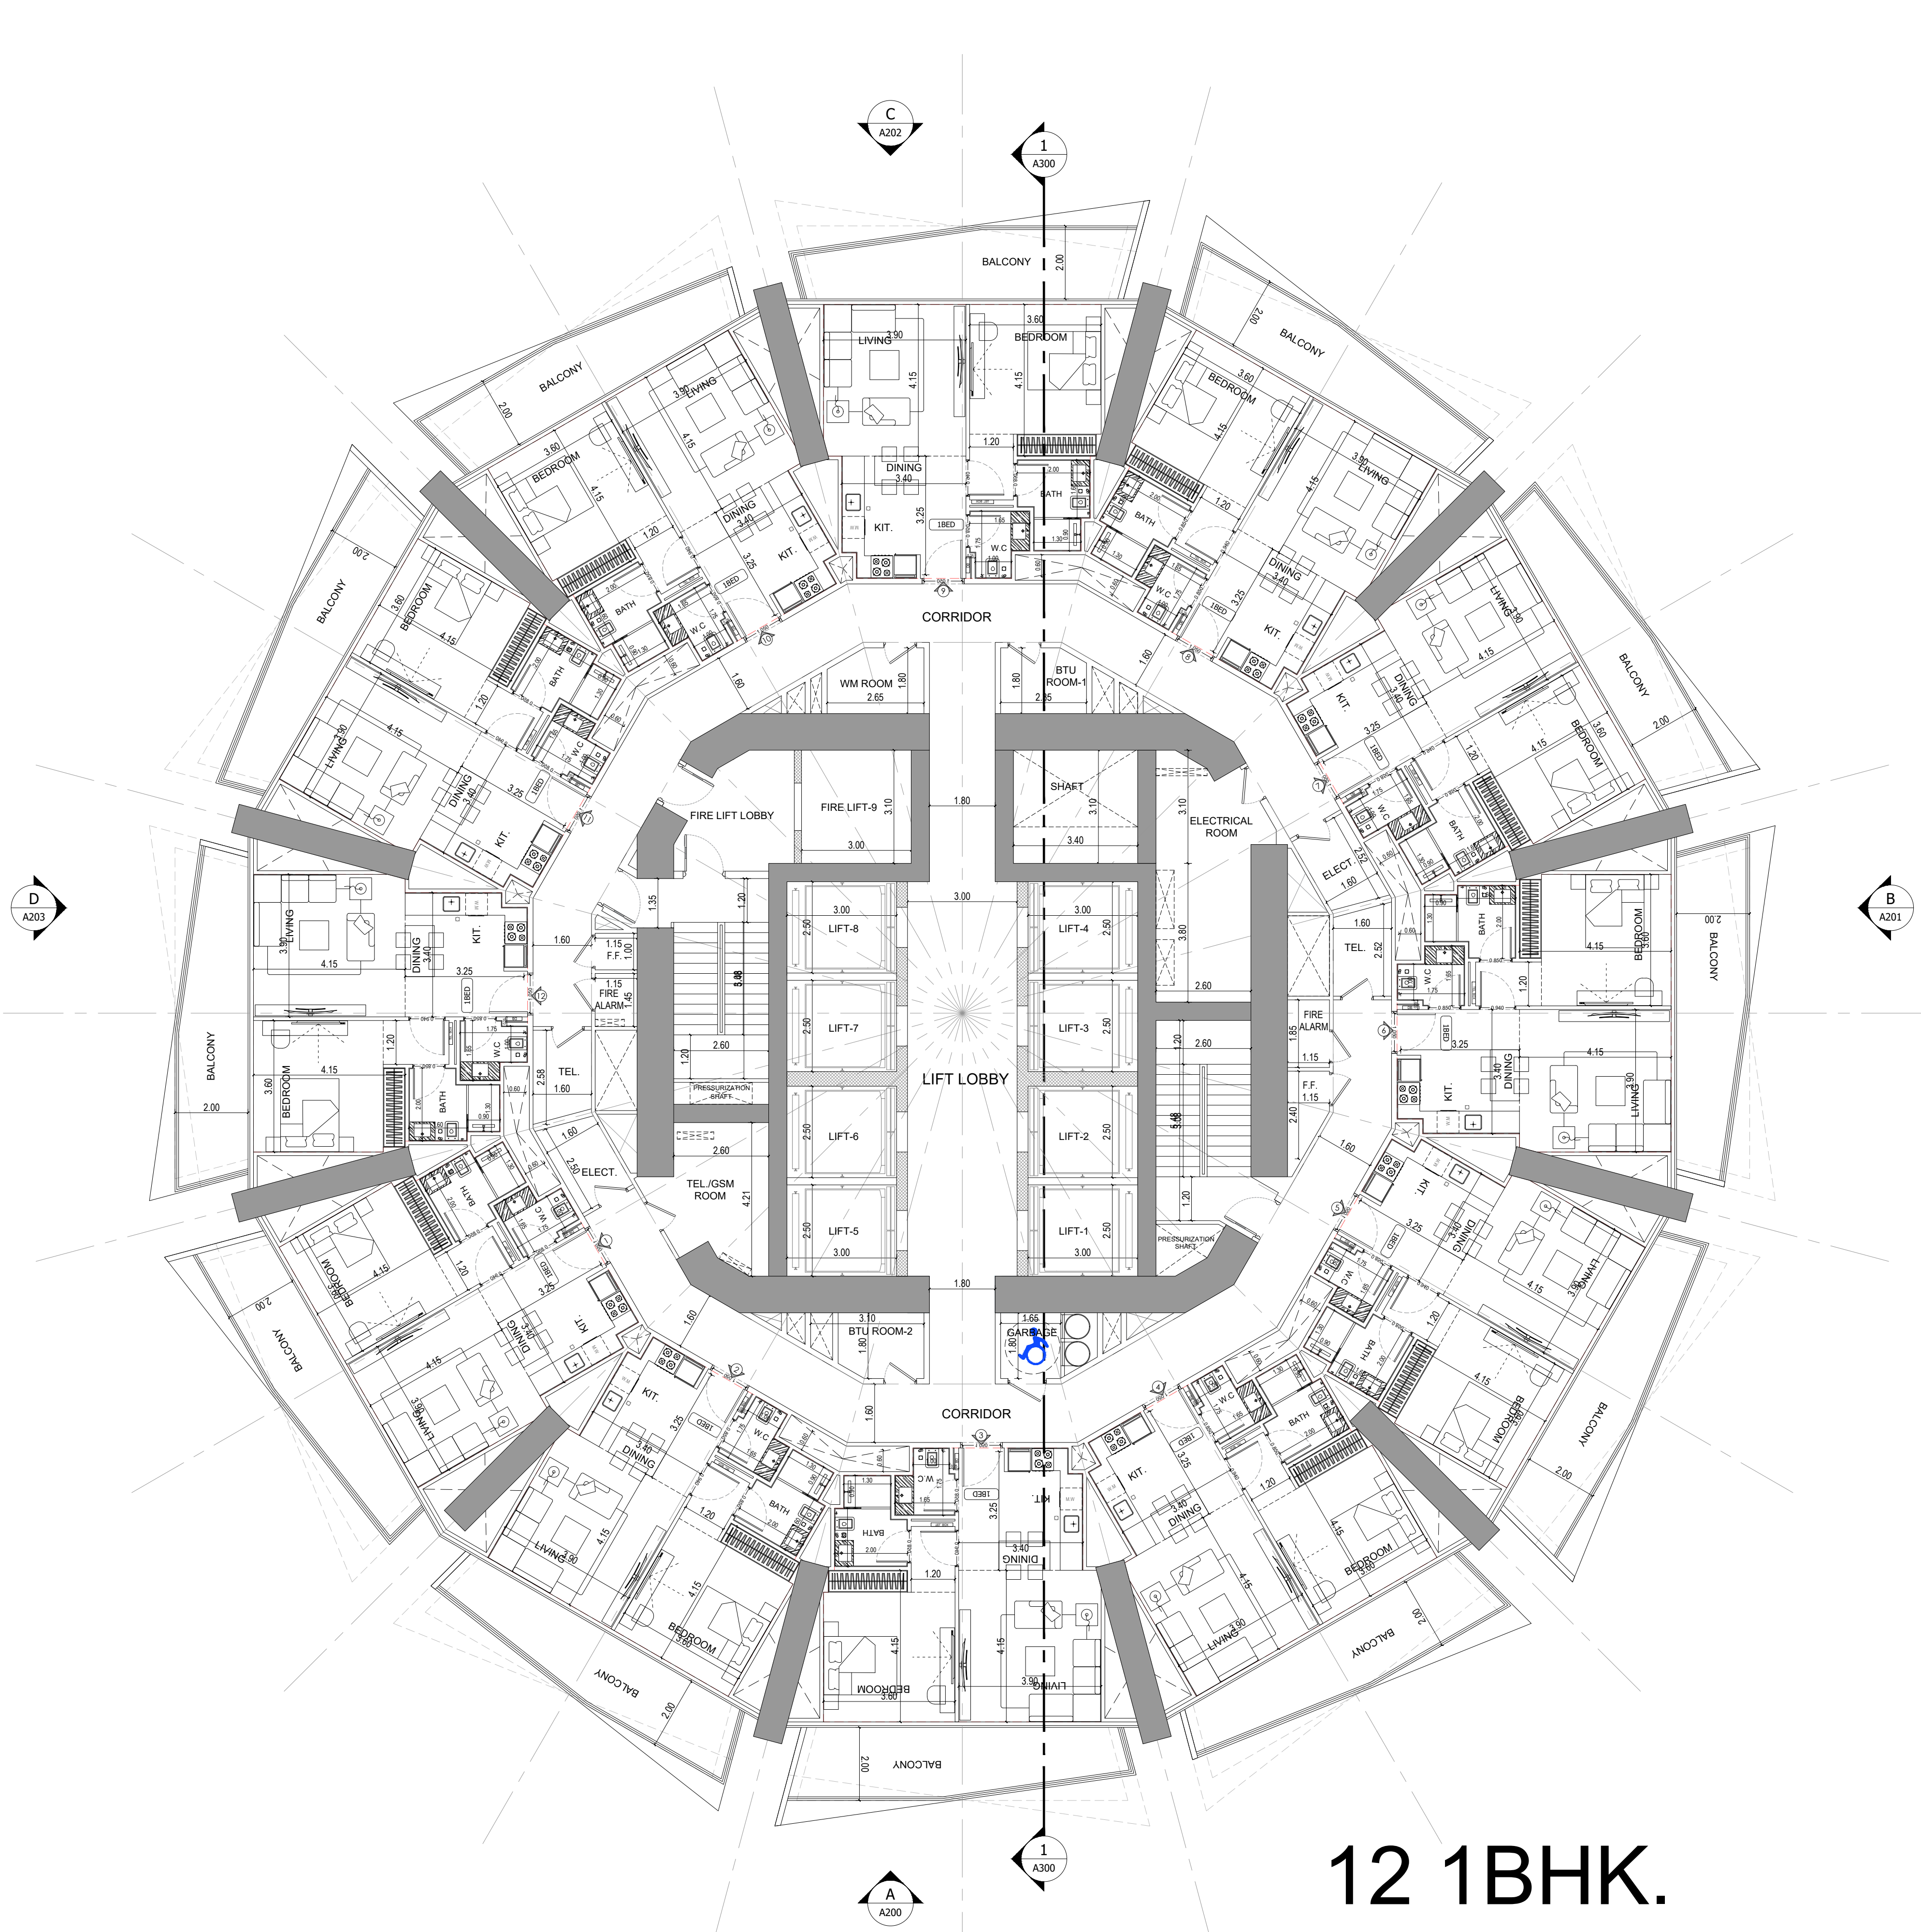

12 1BHK.


1 19,23,31,35,39,43,47,51,55 & 59TH FLOORS PLAN
A114 SCALE - 1:100

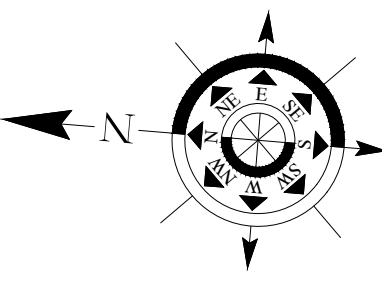

APPROVAL STAMP:

NOTES:

- 1.) ALL DIMENSIONS TO BE VERIFIED BY CONTRACTOR ON SITE PRIOR TO COMMENCEMENT OF ANY WORK.
- 2.) DO NOT SCALE THIS DRAWING FOR THE PURPOSE OF MEASUREMENT. ONLY SCALE DIMENSIONS WHERE SPECIFICALLY INSTRUCTED TO DO SO.
- 3.) ALL MEASUREMENTS ARE IN MILLIMETERS UNLESS OTHERWISE SPECIFIED.
- 4.) DIMENSIONS SHOWN ON THESE DRAWINGS ARE STRUCTURAL DIMENSIONS UNLESS CLEARLY NOTED OTHERWISE.
- 5.) THIS DRAWING IS TO BE READ IN CONJUNCTION WITH ALL OTHER DRAWINGS, DETAIL AND SPECIFICATIONS. ANY DISCREPANCY TO BE IMMEDIATELY BROUGHT TO THE ATTENTION OF ARCHITECT PRIOR TO COMMENCING THE WORKS.

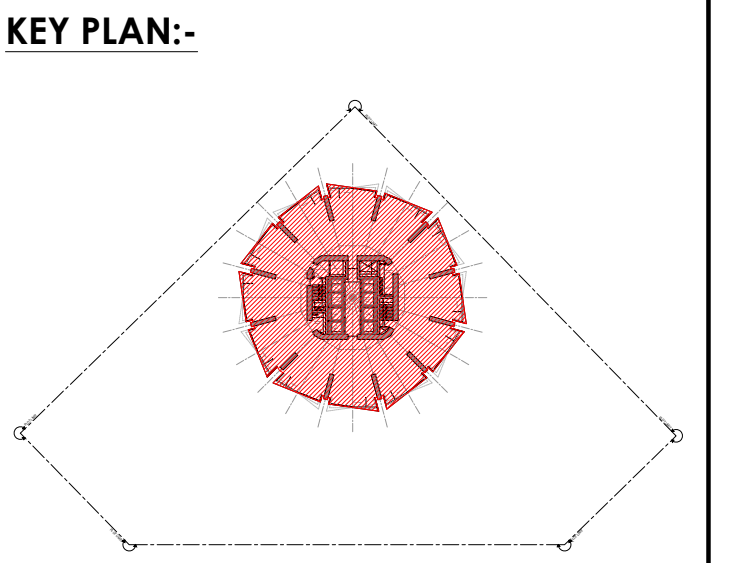

GATE LEVEL PROPOSED = (±0.00 m.) = +15.45 m. DMD LVL.

REV	DATE	DESCRIPTION	CHECK

STATUS : **PRELIMINARY SUBMISSION**

OWNER: **ARGENTI PROPERTIES INVESTMENTS LTD**


CONSULTANT: **SILVER STONE ENGINEERING CONSULTANTS**

PROJECT : **BINGHATTI CIRCLE**
2B + G + 4P + 58 TYP. FLOORS +3 MECH.+3 STR.+ ROOF

PLOT NO: JVC13RHRG001	LOCATION: AL BARSHA SOUTH FOURTH(681)
ARCH: AMAR M	STR Engg: M FLAHA
Reg. No: 114763	Reg. No: 109115
SCALE: 1:100	DRAWN: MUS
CHECKED & APPROVED: AM	


DRAWING TITLE: **19,23,31,35,39,43,47,51,55 & 59TH FLOORS PLAN**

PROJECT NO: P025-01	DWG NO: A114	REV: 00
-------------------------------	------------------------	-------------------

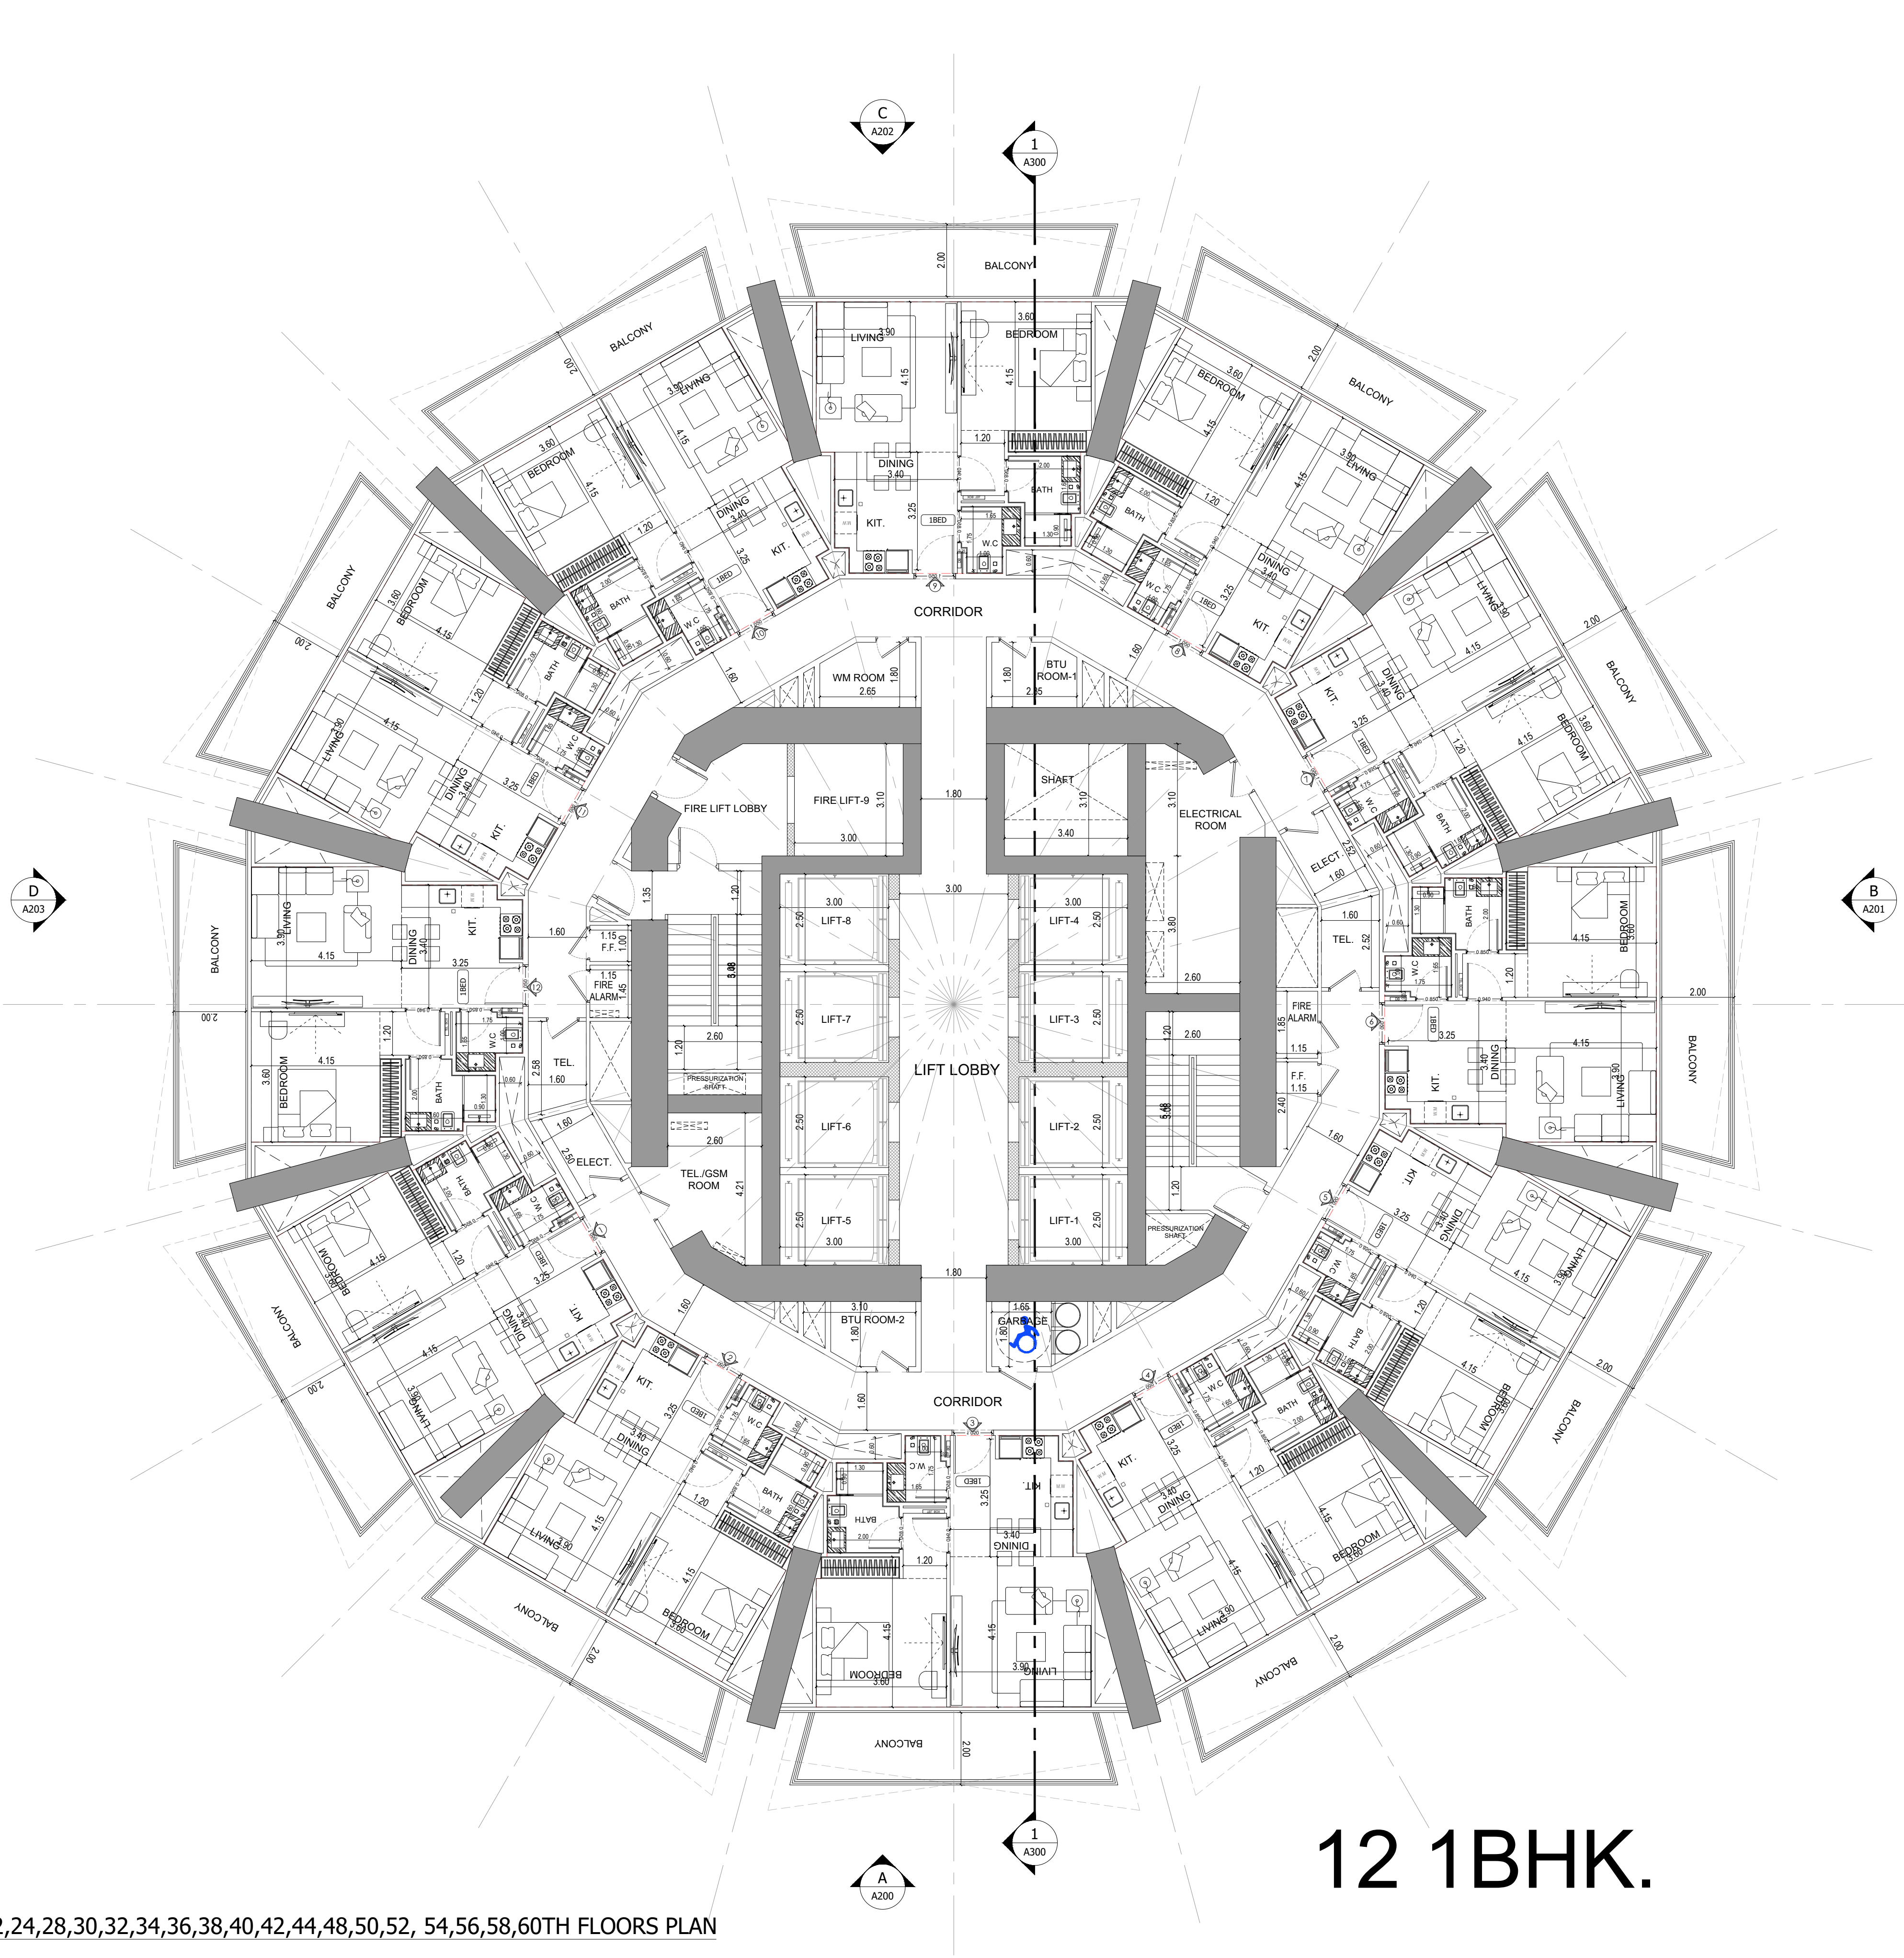

12 1BHK.


1 16,18,20,22,24,28,30,32,34,36,38,40,42,44,48,50,52, 54,56,58,60TH FLOORS PLAN
A115 SCALE - 1:100

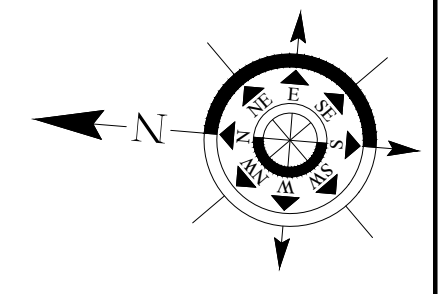

APPROVAL STAMP:

NOTES:


- 1.) ALL DIMENSIONS TO BE VERIFIED BY CONTRACTOR ON SITE PRIOR TO COMMENCEMENT OF ANY WORK.
- 2.) DO NOT SCALE THIS DRAWING FOR THE PURPOSE OF MEASUREMENT. ONLY SCALE DIMENSIONS WHERE SPECIFICALLY INSTRUCTED TO DO SO.
- 3.) ALL MEASUREMENTS ARE IN MILLIMETERS UNLESS OTHERWISE SPECIFIED.
- 4.) DIMENSIONS SHOWN ON THESE DRAWINGS ARE STRUCTURAL DIMENSIONS UNLESS CLEARLY NOTED OTHERWISE.
- 5.) THIS DRAWING IS TO BE READ IN CONJUNCTION WITH ALL OTHER DRAWINGS, DETAIL AND SPECIFICATIONS. ANY DISCREPANCY TO BE IMMEDIATELY BROUGHT TO THE ATTENTION OF ARCHITECT PRIOR TO COMMENCING THE WORKS.

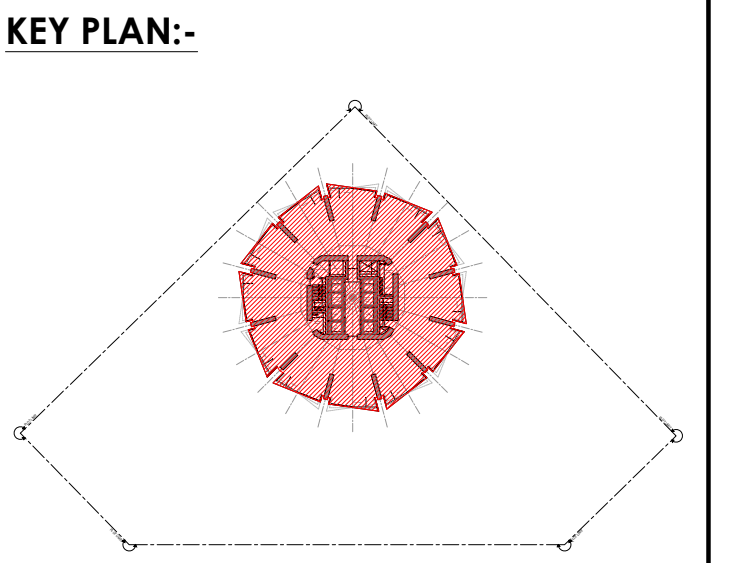

سلفر ستون
للمهندسة
SILVER STONE
ENGINEERING CONSULTANTS
P.O.BOX 3096, DUBAI UAE

GATE LEVEL PROPOSED = (±0.00 m.) = +15.45 m. DMD LVL.

GATE LEVEL PROPOSED = (±0.00 m.) = +15.45 m. DML LVL.			
REV	DATE	DESCRIPTION	CHECK
STATUS :			
PRELIMINARY SUBMISSION			
OWNER:			
ARGENTI PROPERTIES INVESTMENTS LTD			
CONSULTANT:			
 سلفر ستون للمهندسة SILVER STONE ENGINEERING CONSULTANTS			
PROJECT :			
 بن غاطي BINGHATTI BINGHATTI CIRCLE 2B + G + 4P + S8 TYP. FLOORS +3 MECH.+3 STR.+ ROOF			
PLOT NO.		LOCATION:	
JVC13RHRG001		AL BARSHA SOUTH FOURTH(681)	
ARCH: AMAR M		STR Engg: M FLAHA	
Reg. No: 114763		Reg. No: 109115	
SCALE:		DRAWN: MUS	
1:100		CHECKED & APPROVED: AM	
DRAWING TITLE:			
16,18,20,22,24,28,30,32,34,36,38,40,42,44,48,50, 52, 54,56,58,60TH FLOORS PLAN			
PROJECT NO:		DWG NO:	REV:
P025-01		A115	00

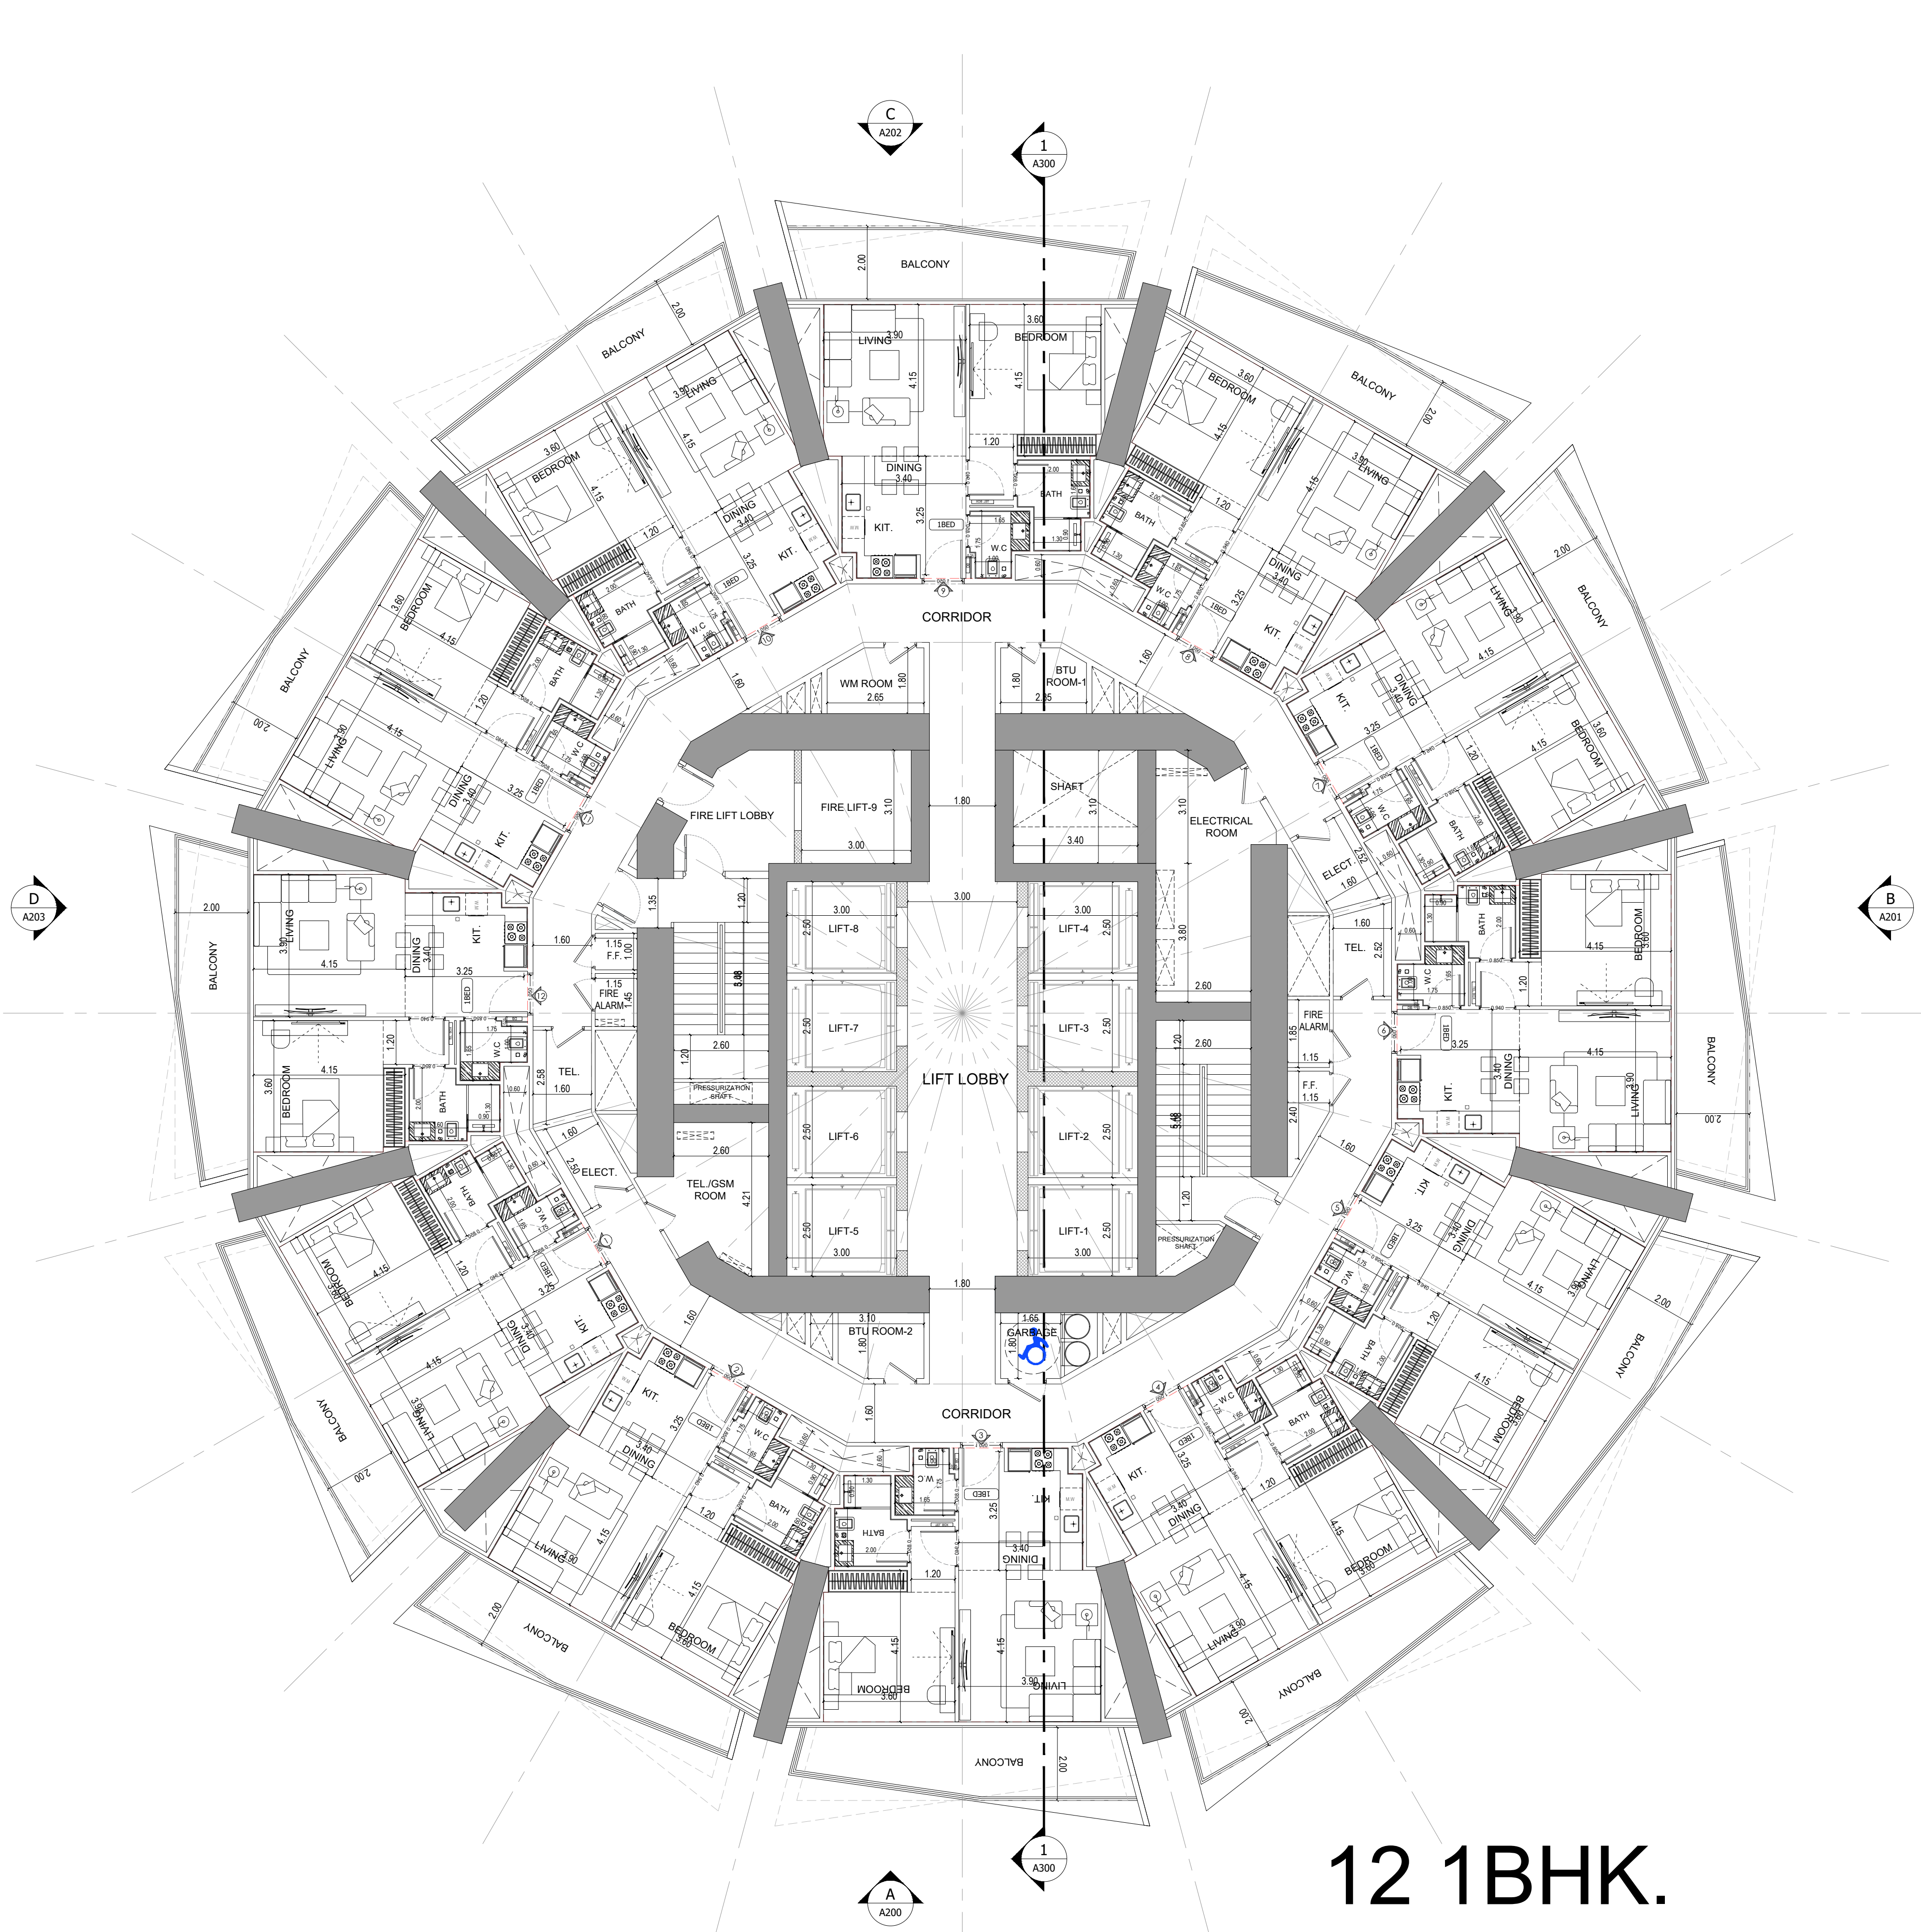

12 1BHK.

1 17,21,25,29,33,37,41,49,53,57 & 61ST FLOORS PLAN
A116 SCALE - 1:100

APPROVAL STAMP:

NOTES:
1.) ALL DIMENSIONS TO BE VERIFIED BY CONTRACTOR ON SITE PRIOR TO COMMENCEMENT OF ANY WORK.
2.) DO NOT SCALE THIS DRAWING FOR THE PURPOSE OF MEASUREMENT. ONLY SCALE DIMENSIONS WHERE SPECIFICALLY INSTRUCTED TO DO SO.
3.) ALL MEASUREMENTS ARE IN MILLIMETERS UNLESS OTHERWISE SPECIFIED.
4.) DIMENSIONS SHOWN ON THESE DRAWINGS ARE STRUCTURAL DIMENSIONS UNLESS CLEARLY NOTED OTHERWISE.
5.) THIS DRAWING IS TO BE READ IN CONJUNCTION WITH ALL OTHER DRAWINGS, DETAIL AND SPECIFICATIONS. ANY DISCREPANCY TO BE IMMEDIATELY BROUGHT TO THE ATTENTION OF ARCHITECT PRIOR TO COMMENCING THE WORKS.

KEY PLAN:-

SILVER STONE
ENGINEERING CONSULTANTS
P.O. BOX 3096, DUBAI UAE

GATE LEVEL PROPOSED = (±0.00 m.) = +15.45 m. DMD LVL.

REV	DATE	DESCRIPTION	CHECK

STATUS :
PRELIMINARY SUBMISSION

OWNER:
ARGENTI PROPERTIES INVESTMENTS LTD

CONSULTANT:

SILVER STONE
ENGINEERING CONSULTANTS

PROJECT :

BINGHATTI CIRCLE
2B + G + 4P + S8 TYP. FLOORS +3 MECH.+3 STR.+ ROOF


LOCATIONS	AL BARSHA SOUTH FOURTH(681)
ARCH:	AMAR M
STR Engg:	M FLAHA
Reg. No:	114763
Reg. No:	109115
SCALE:	DRAWN: MUS
CHECKED & APPROVED:	AM

1:100

DRAWING TITLE:
17,21,25,29,33,37,41,49,53,57 & 61ST FLOORS PLAN


PROJECT NO:	DWG NO:	REV:
P025-01	A116	00

File Path: X:\Binghatti Project\2025-01-Binghatti Circle\01- ARCHITECTURE\01- CONCEPT\01- DWG- Prit Date: 12-Jun-25, Time: 10:23:34 AM

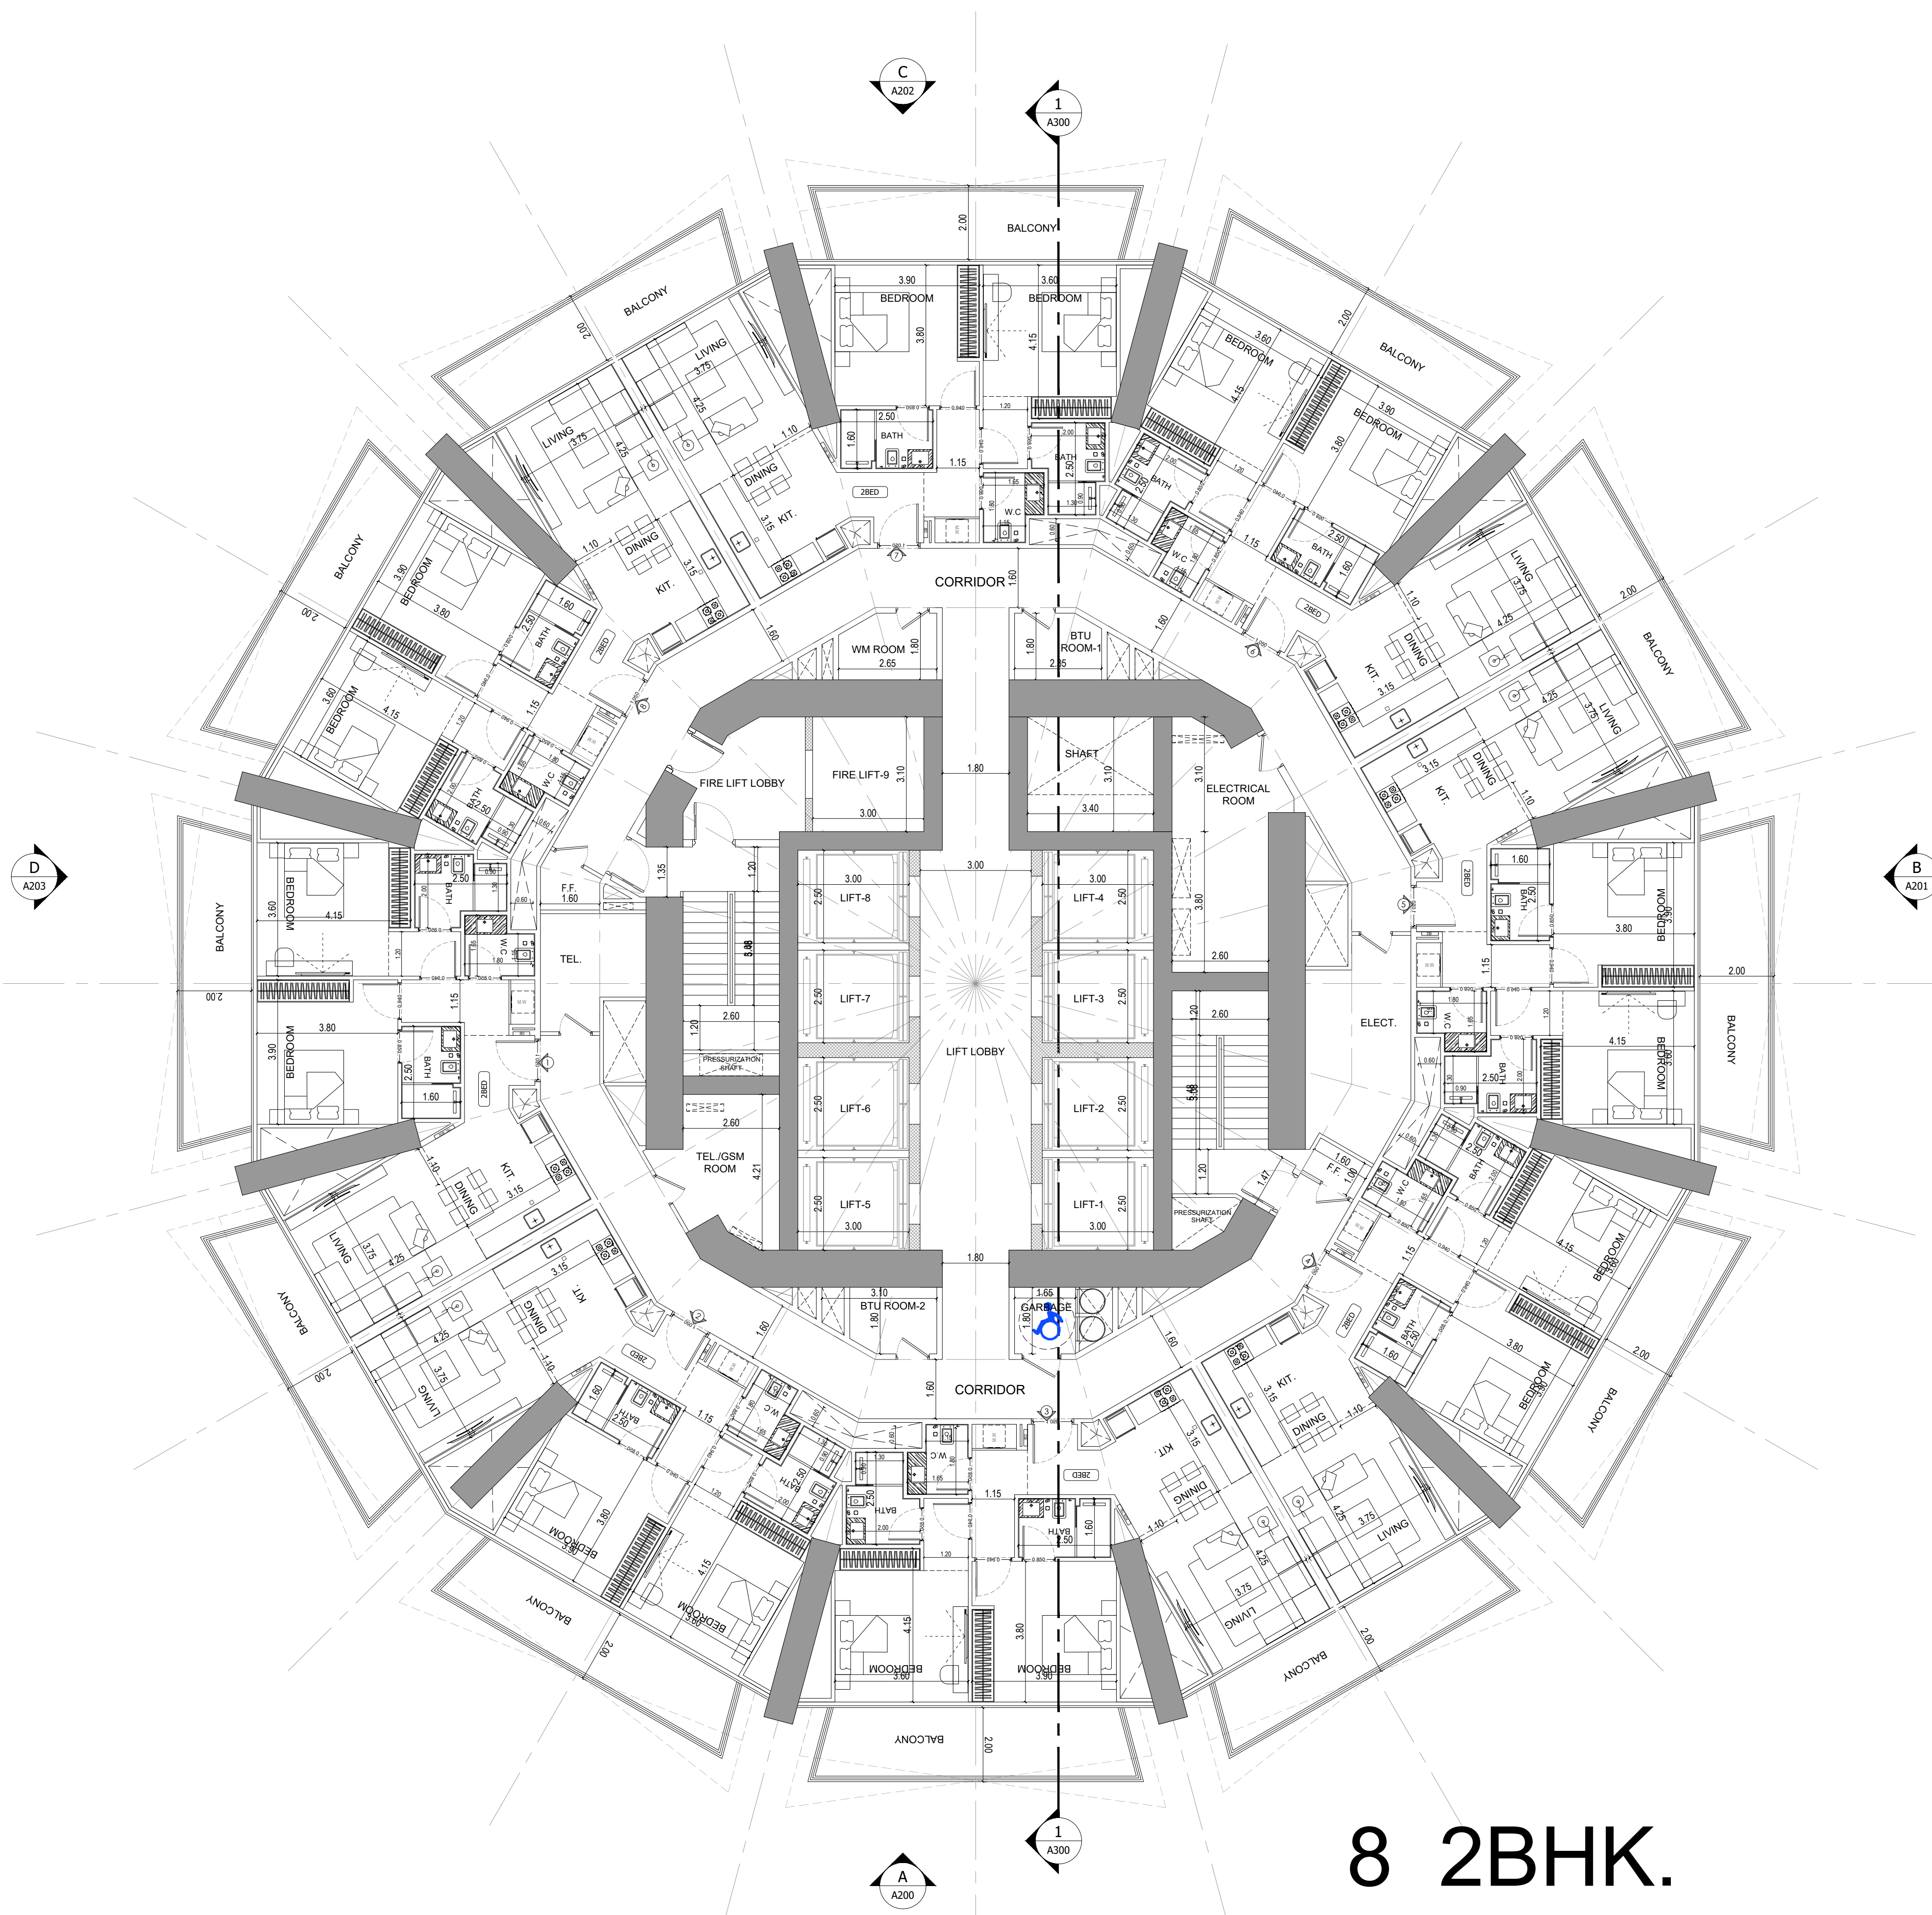

1 62ND FLOOR PLAN
A117 SCALE - 1:100


8 2BHK.

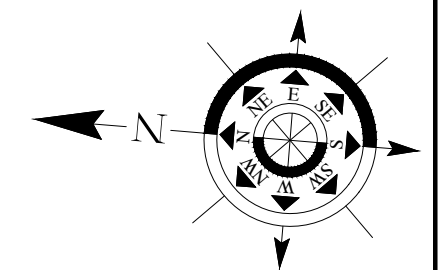

APPROVAL STAMP:

NOTES:

- 1.) ALL DIMENSIONS TO BE VERIFIED BY CONTRACTOR ON SITE PRIOR TO COMMENCEMENT OF ANY WORK.
- 2.) DO NOT SCALE THIS DRAWING FOR THE PURPOSE OF MEASUREMENT. ONLY SCALE DIMENSIONS WHERE SPECIFICALLY INSTRUCTED TO DO SO.
- 3.) ALL MEASUREMENTS ARE IN MILLIMETERS UNLESS OTHERWISE SPECIFIED.
- 4.) DIMENSIONS SHOWN ON THESE DRAWINGS ARE STRUCTURAL DIMENSIONS UNLESS CLEARLY NOTED OTHERWISE.
- 5.) THIS DRAWING IS TO BE READ IN CONJUNCTION WITH ALL OTHER DRAWINGS, DETAIL AND SPECIFICATIONS. ANY DISCREPANCY TO BE IMMEDIATELY BROUGHT TO THE ATTENTION OF ARCHITECT PRIOR TO COMMENCING THE WORKS.

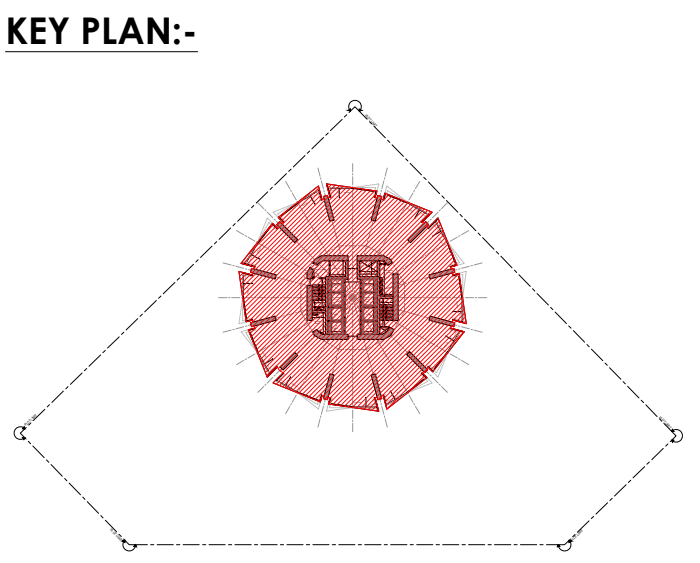

GATE LEVEL PROPOSED = (±0.00 m.) = +15.45 m. DMD LVL.

REV	DATE	DESCRIPTION	CHECK

STATUS: PRELIMINARY SUBMISSION

OWNER: ARGENTI PROPERTIES INVESTMENTS LTD




PROJECT: BINGHATTI CIRCLE
2B + G + 4P + S8 TYP. FLOORS +3 MECH.+3 STR.+ ROOF

LOCATION: AL BARSHA SOUTH FOURTH(681)	ARCH: AMAR M	STR Engg: M FLAHA
Reg. No: 114763	Reg. No: 109115	SCALE: DRAWN: MUS
CHECKED & APPROVED: AM		

DRAWING TITLE: 62ND FLOOR PLAN


PROJECT NO: P025-01	DWG NO: A117	REV: 00
---------------------	--------------	---------

File Path: X:\Binghatti Project\025-01-Binghatti Circle\01- ARCHITECTURE\01- CONCEPT\01- DWG- P11 Date: 12-Jun-25, Time: 10:23:34 AM

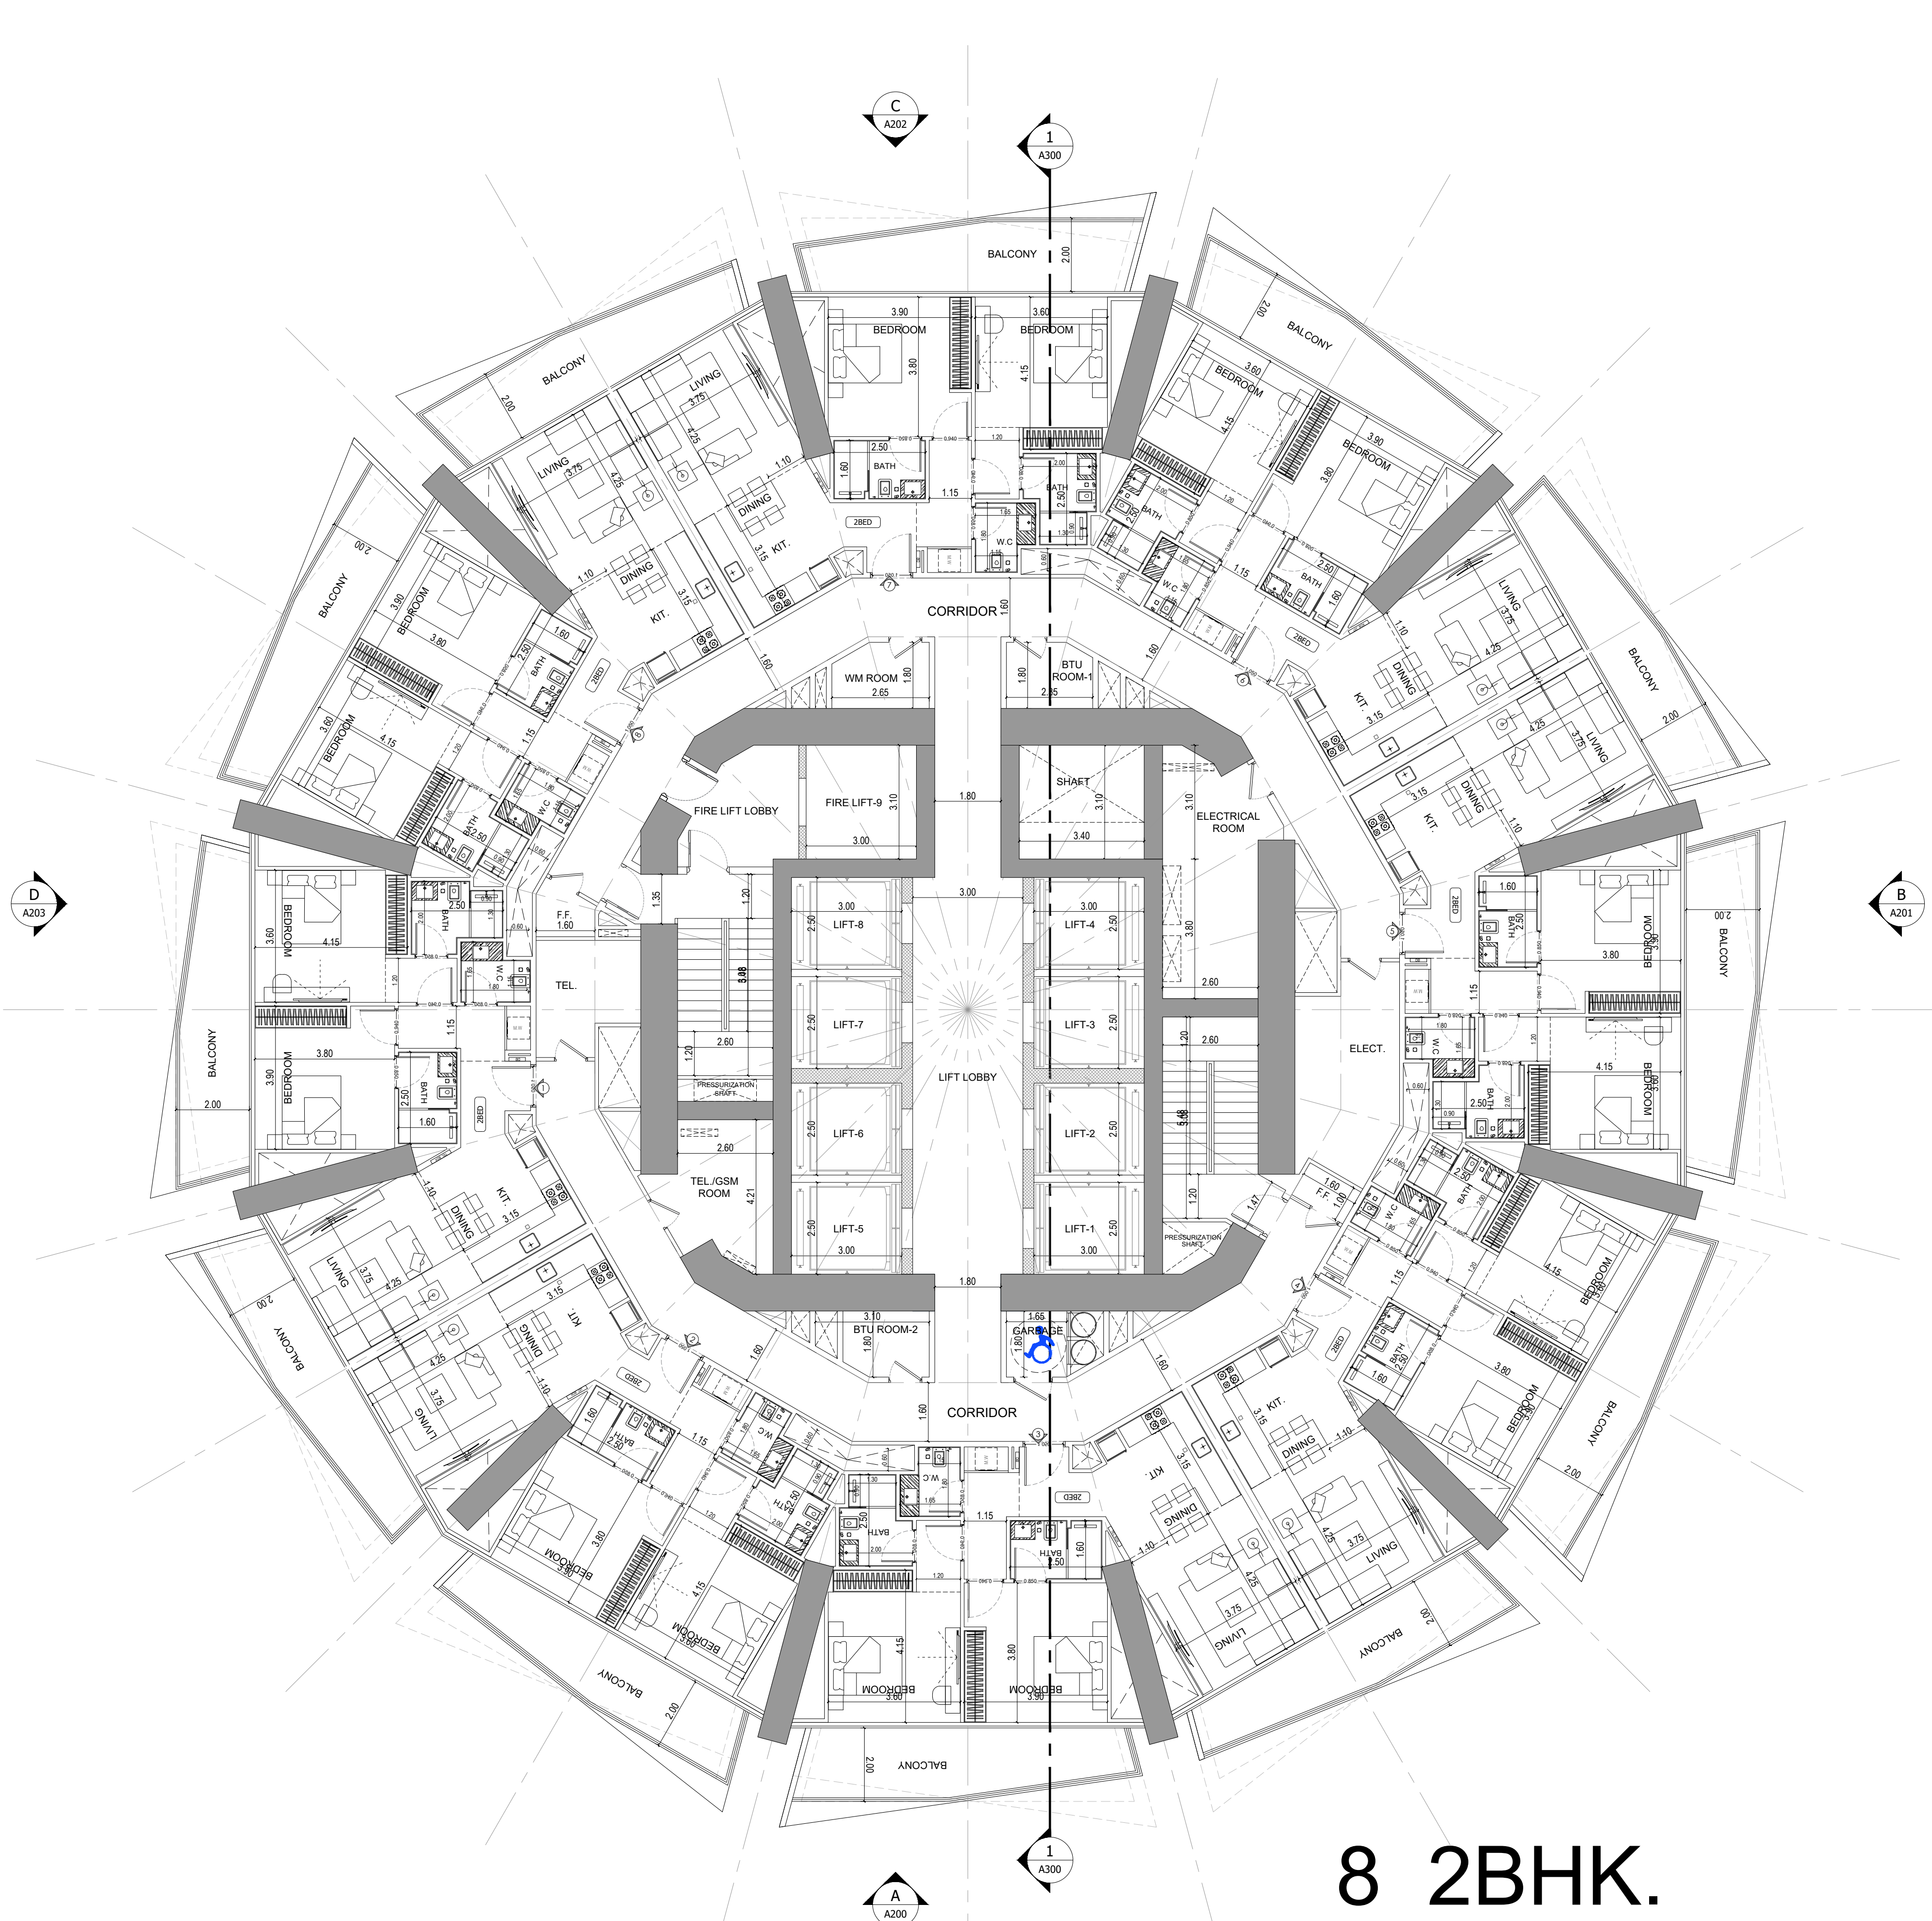

1 63RD FLOOR PLAN
A118 SCALE - 1:100


8 2BHK.

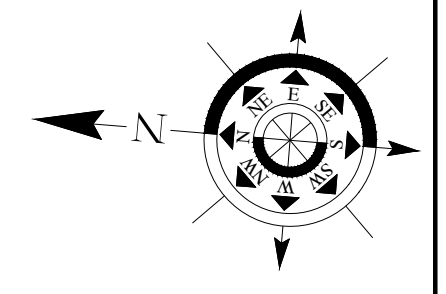

APPROVAL STAMP:

NOTES:

- 1.) ALL DIMENSIONS TO BE VERIFIED BY CONTRACTOR ON SITE PRIOR TO COMMENCEMENT OF ANY WORK.
- 2.) DO NOT SCALE THIS DRAWING FOR THE PURPOSE OF MEASUREMENT. ONLY SCALE DIMENSIONS WHERE SPECIFICALLY INSTRUCTED TO DO SO.
- 3.) ALL MEASUREMENTS ARE IN MILLIMETERS UNLESS OTHERWISE SPECIFIED.
- 4.) DIMENSIONS SHOWN ON THESE DRAWINGS ARE STRUCTURAL DIMENSIONS UNLESS CLEARLY NOTED OTHERWISE.
- 5.) THIS DRAWING IS TO BE READ IN CONJUNCTION WITH ALL OTHER DRAWINGS, DETAIL AND SPECIFICATIONS. ANY DISCREPANCY TO BE IMMEDIATELY BROUGHT TO THE ATTENTION OF ARCHITECT PRIOR TO COMMENCING THE WORKS.

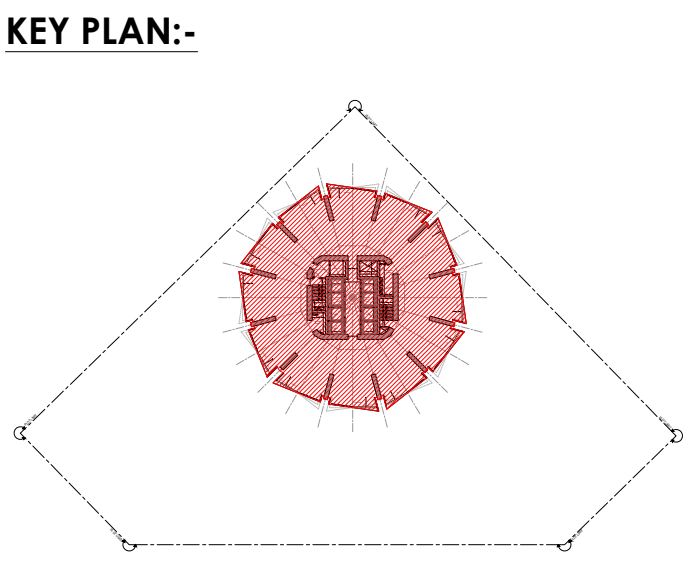

GATE LEVEL PROPOSED = (±0.00 m.) = +15.45 m. DMD LVL.

REV	DATE	DESCRIPTION	CHECK

STATUS: PRELIMINARY SUBMISSION

OWNER: ARGENTI PROPERTIES INVESTMENTS LTD

CONSULTANT: SILVER STONE ENGINEERING CONSULTANTS

PROJECT: BINGHATTI BINGHATTI CIRCLE
2B + G + 4P + S8 TYP. FLOORS +3 MECH.+3 STR.+ ROOF



PROJECT NO: JVC13RHRG001	LOCATION: AL BARSHA SOUTH FOURTH(681)
ARCH: AMAR M	STR Engg: M FLAHA
Reg. No: 114763	Reg. No: 109115
SCALE: DRAWN: MUS	CHECKED & APPROVED: AM

1:100

DRAWING TITLE: 63RD FLOOR PLAN

PROJECT NO: P025-01	DWG NO: A118	REV: 00
------------------------	-----------------	------------


File Path: X:\Binghatti Project\2025-01-Binghatti Circle\01- ARCHITECTURE\01- CONCEPT\01- DWG- Print Date: 12-Jun-25, Time: 10:23:34 AM

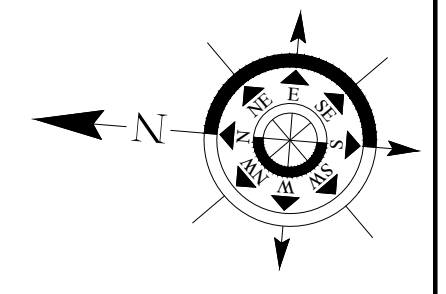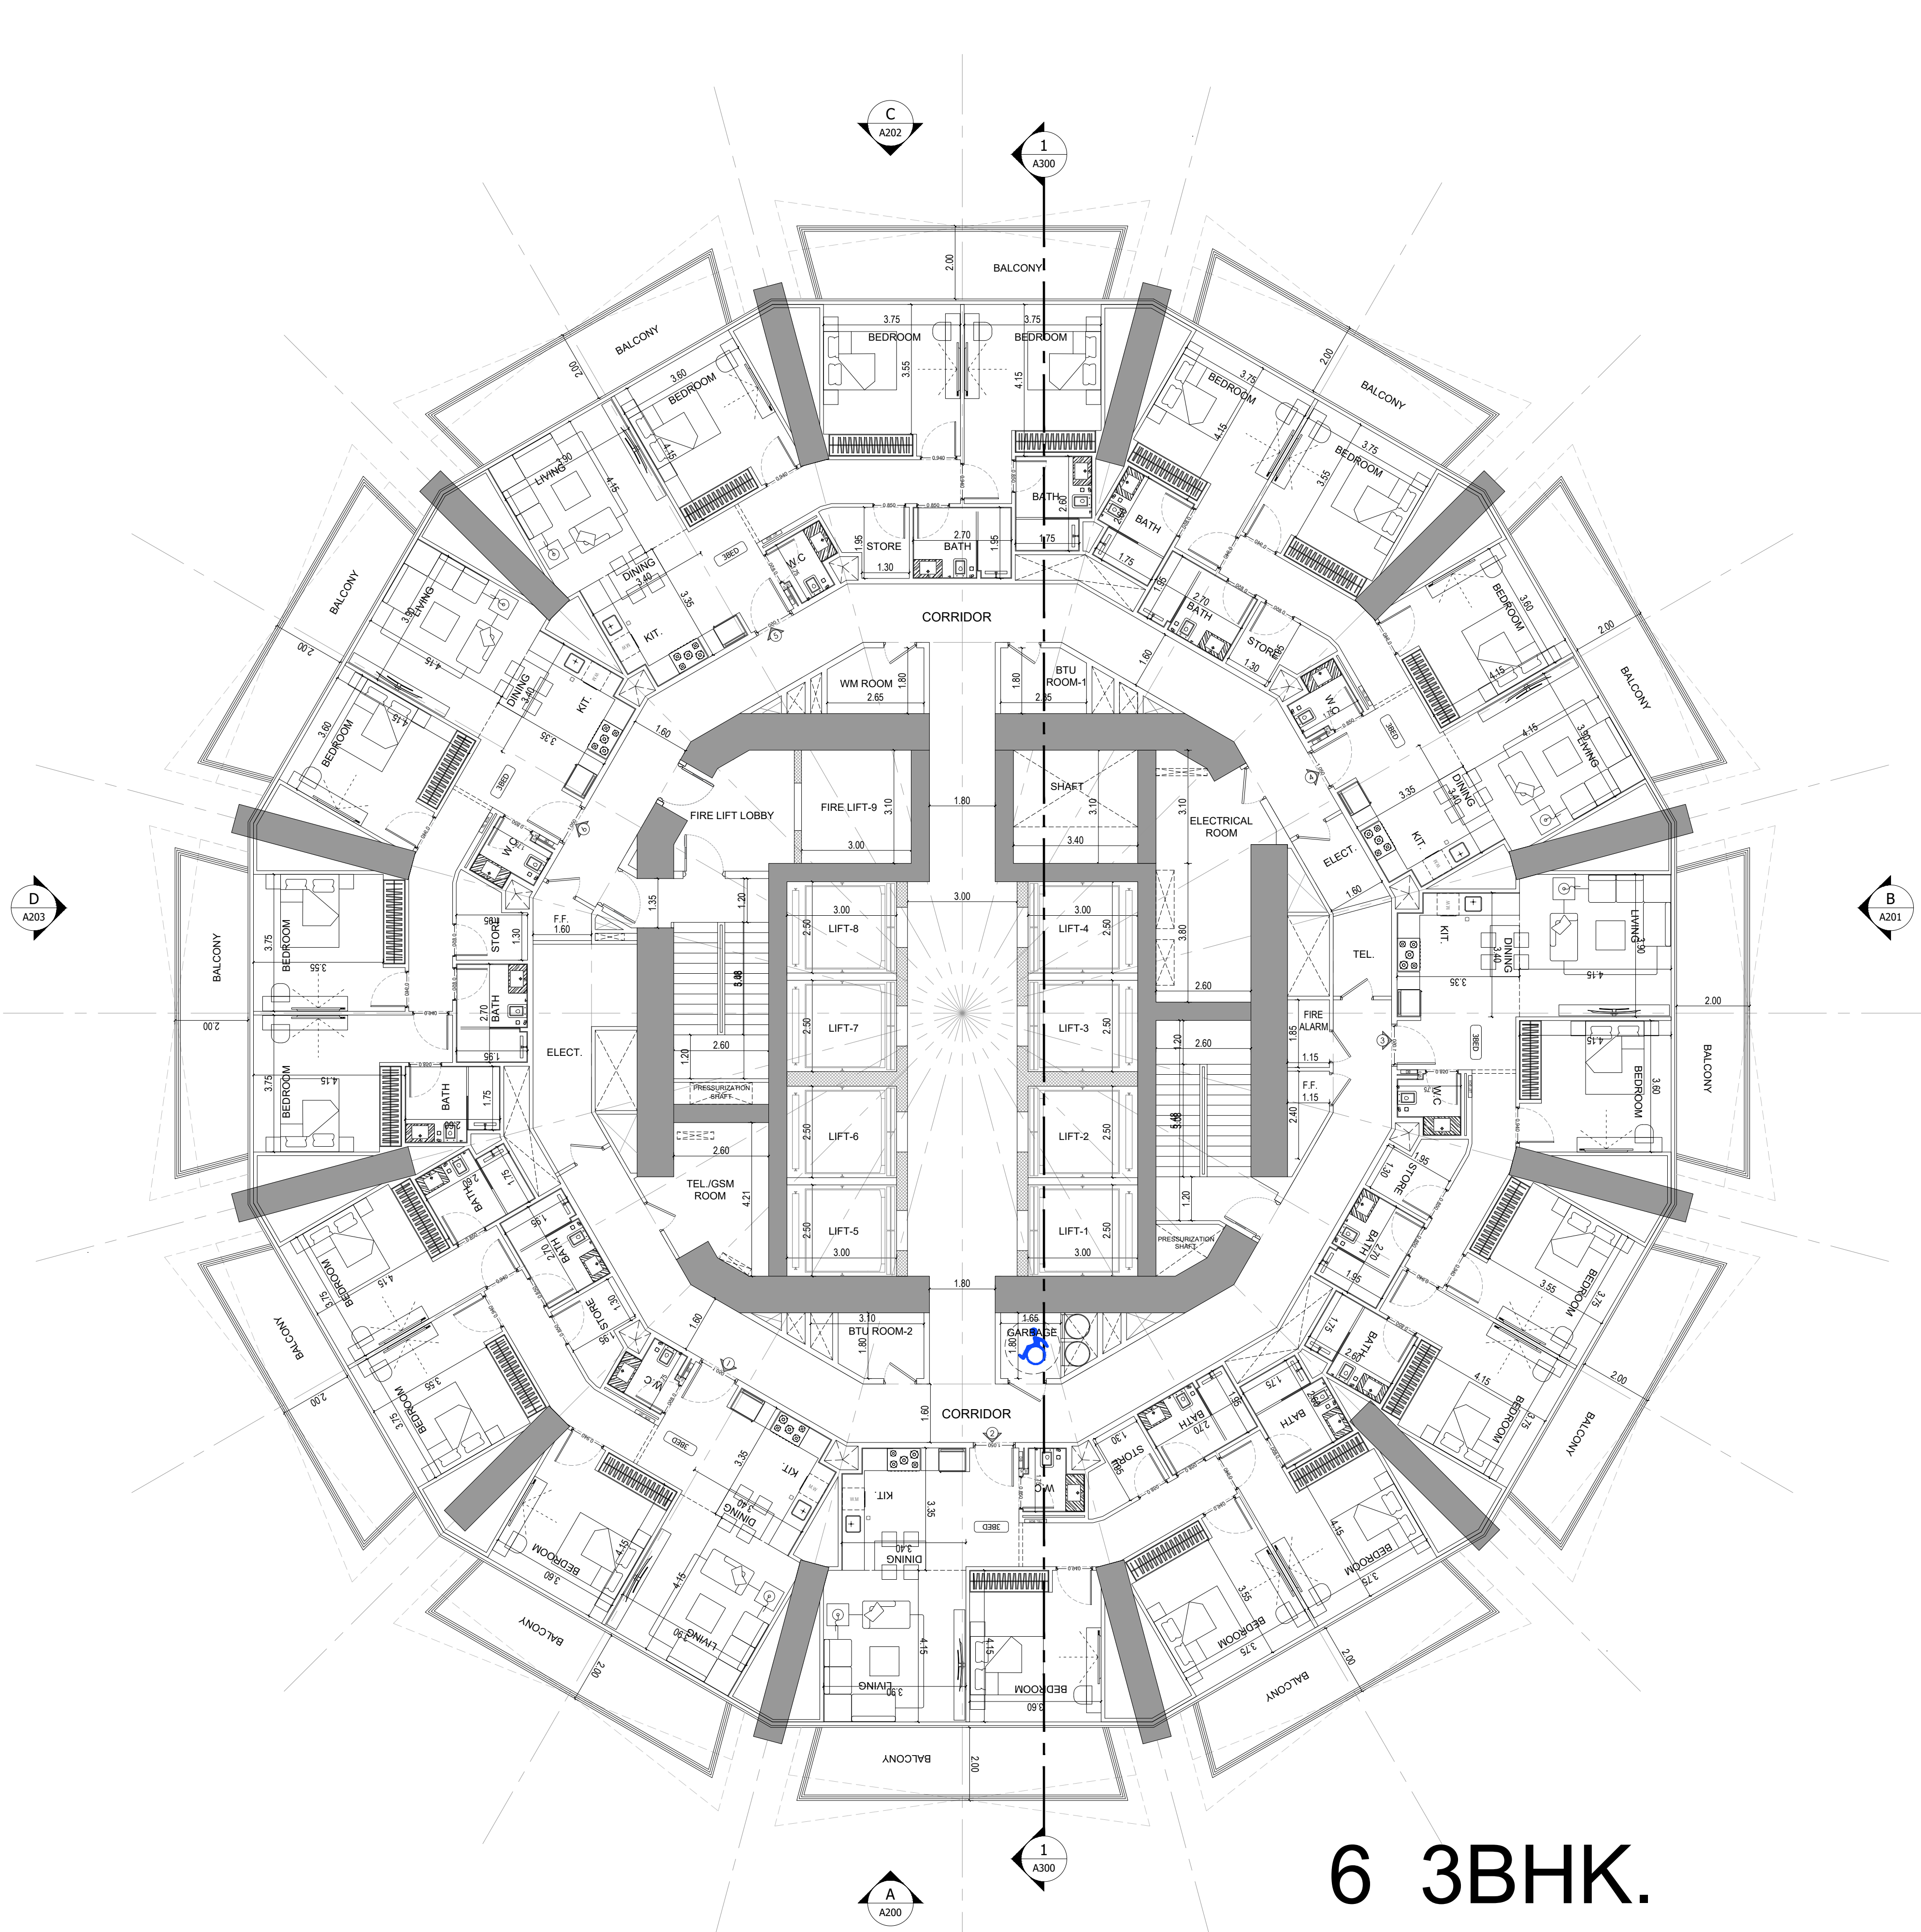

APPROVAL STAMP:

NOTES:

- 1.) ALL DIMENSIONS TO BE VERIFIED BY CONTRACTOR ON SITE PRIOR TO COMMENCEMENT OF ANY WORK.
- 2.) DO NOT SCALE THIS DRAWING FOR THE PURPOSE OF MEASUREMENT. ONLY SCALE DIMENSIONS WHERE SPECIFICALLY INSTRUCTED TO DO SO.
- 3.) ALL MEASUREMENTS ARE IN MILLIMETERS UNLESS OTHERWISE SPECIFIED.
- 4.) DIMENSIONS SHOWN ON THESE DRAWINGS ARE STRUCTURAL DIMENSIONS UNLESS CLEARLY NOTED OTHERWISE.
- 5.) THIS DRAWING IS TO BE READ IN CONJUNCTION WITH ALL OTHER DRAWINGS, DETAIL AND SPECIFICATIONS. ANY DISCREPANCY TO BE IMMEDIATELY BROUGHT TO THE ATTENTION OF ARCHITECT PRIOR TO COMMENCING THE WORKS.

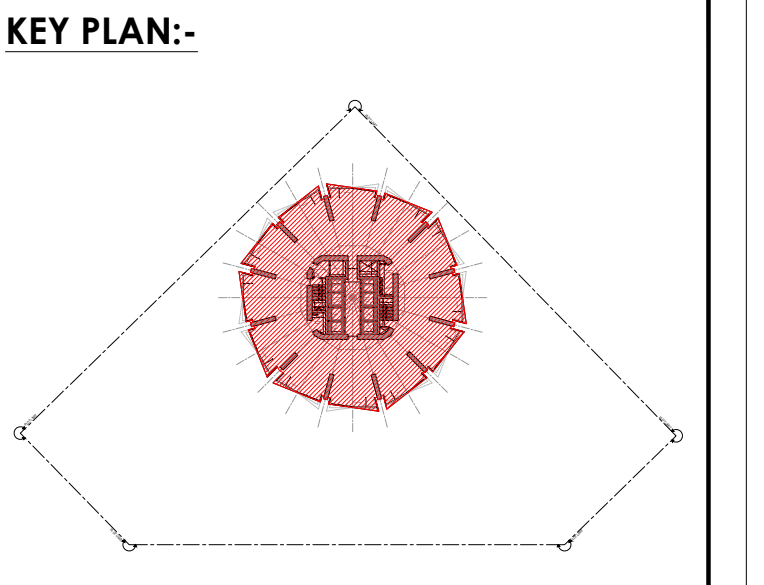

GATE LEVEL PROPOSED = (±0.00 m.) = +15.45 m. DMD LVL.

REV	DATE	DESCRIPTION	CHECK

STATUS: **PRELIMINARY SUBMISSION**

OWNER: **ARGENTI PROPERTIES INVESTMENTS LTD**

CONSULTANT: **SILVER STONE ENGINEERING CONSULTANTS**

PROJECT: **BINGHATTI CIRCLE**

2B + G + 4P + 58 TYP. FLOORS + 3 MECH. + 3 STR. + ROOF

1:100



DRAWING TITLE: **64TH FLOOR PLAN**

PROJECT NO: **P025-01** DWG NO: **A119** REV: **00**

1 64TH FLOOR PLAN
A119 SCALE - 1:100

6 3BHK.


File Path: X:\Binghatti Project\2025-01-Binghatti Circle\01- ARCHITECTURE\01- CONCEPT\01- DWG- Pmt Date: 12-Jun-25, Time: 10:23:34 AM

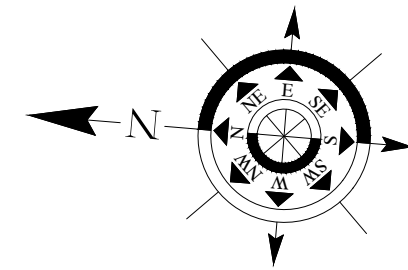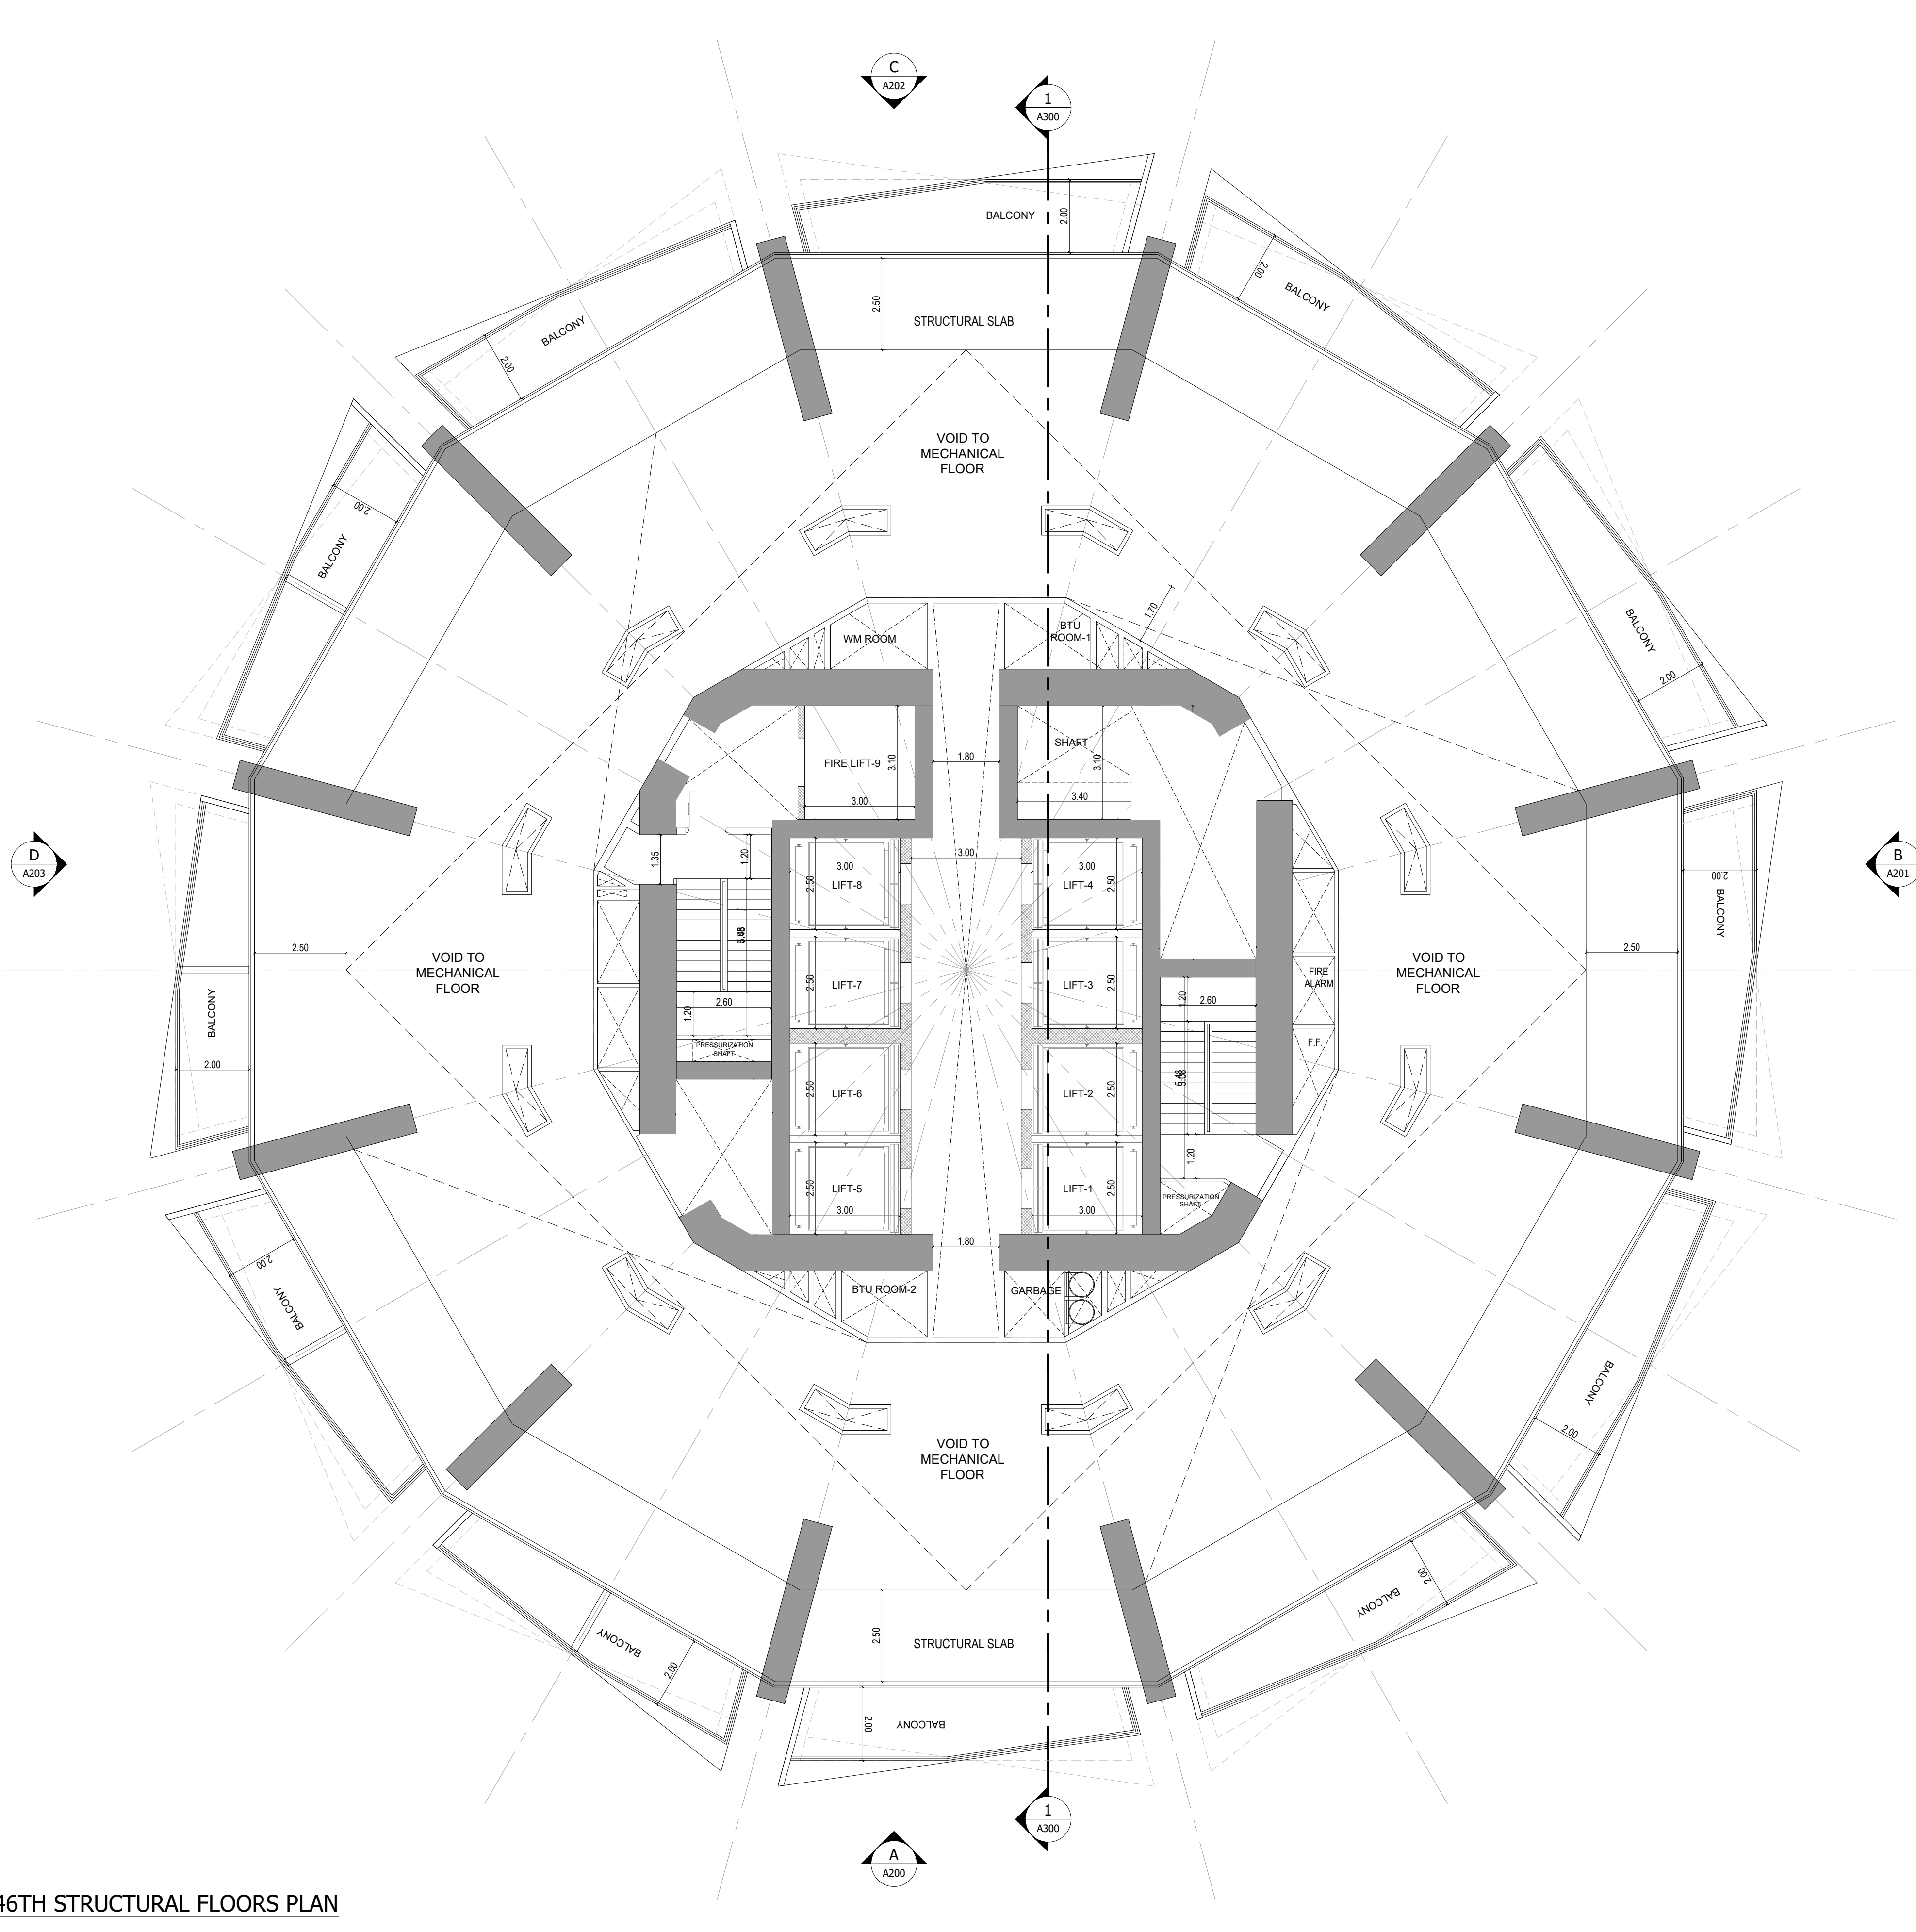

APPROVAL STAMP:

- NOTES:
- 1.) ALL DIMENSIONS TO BE VERIFIED BY CONTRACTOR ON SITE PRIOR TO COMMENCEMENT OF ANY WORK.
 - 2.) DO NOT SCALE THIS DRAWING FOR THE PURPOSE OF MEASUREMENT. ONLY SCALE DIMENSIONS WHERE SPECIFICALLY INSTRUCTED TO DO SO.
 - 3.) ALL MEASUREMENTS ARE IN MILLIMETERS UNLESS OTHERWISE SPECIFIED.
 - 4.) DIMENSIONS SHOWN ON THESE DRAWINGS ARE STRUCTURAL DIMENSIONS UNLESS CLEARLY NOTED OTHERWISE.
 - 5.) THIS DRAWING IS TO BE READ IN CONJUNCTION WITH ALL OTHER DRAWINGS, DETAIL AND SPECIFICATIONS. ANY DISCREPANCY TO BE IMMEDIATELY BROUGHT TO THE ATTENTION OF ARCHITECT PRIOR TO COMMENCING THE WORKS.

KEY PLAN:-

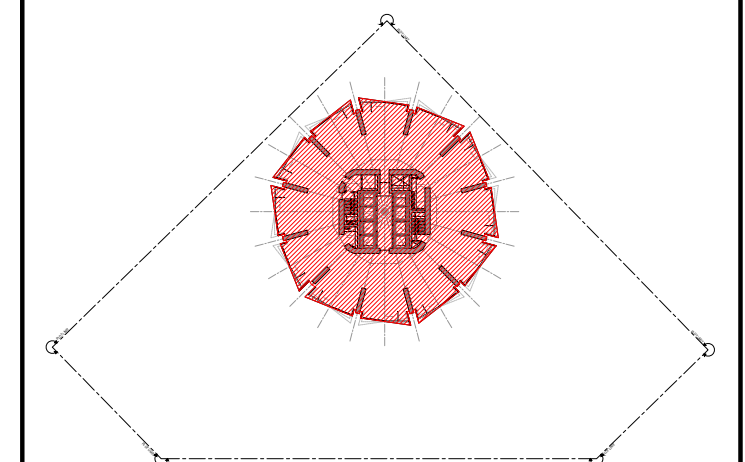

GATE LEVEL PROPOSED = (±0.00 m.) = +15.45 m. DMD LVL.

REV DATE DESCRIPTION CHECK

STATUS :

PRELIMINARY SUBMISSION

OWNER:

ARGENTI PROPERTIES INVESTMENTS LTD

CONSULTANT:



PROJECT :

BINGHATTI BINGHATTI CIRCLE

2B + G + 4P + 58 TYP. FLOORS +3 MECH.+3 STR.+ ROOF

PLOT NO. LOCATION: AL BARSHA SOUTH FOURTH (681)

ARCH: AMAR M STR Engg: M FLAHA

Reg. No: 114763 Reg. No: 109115

SCALE: DRAWN: MUS CHECKED & APPROVED: AM

1:100



DRAWING TITLE:

9TH,27TH&46TH STRUCTURAL FLOORS PLAN

PROJECT NO: DWG NO: REV:

P025-01 A120 00


1 9TH,27TH&46TH STRUCTURAL FLOORS PLAN
A120 SCALE - 1:100

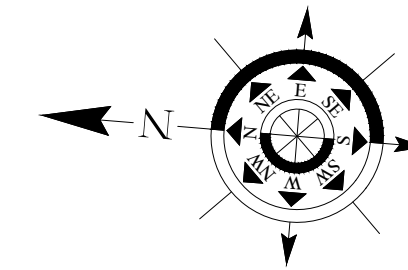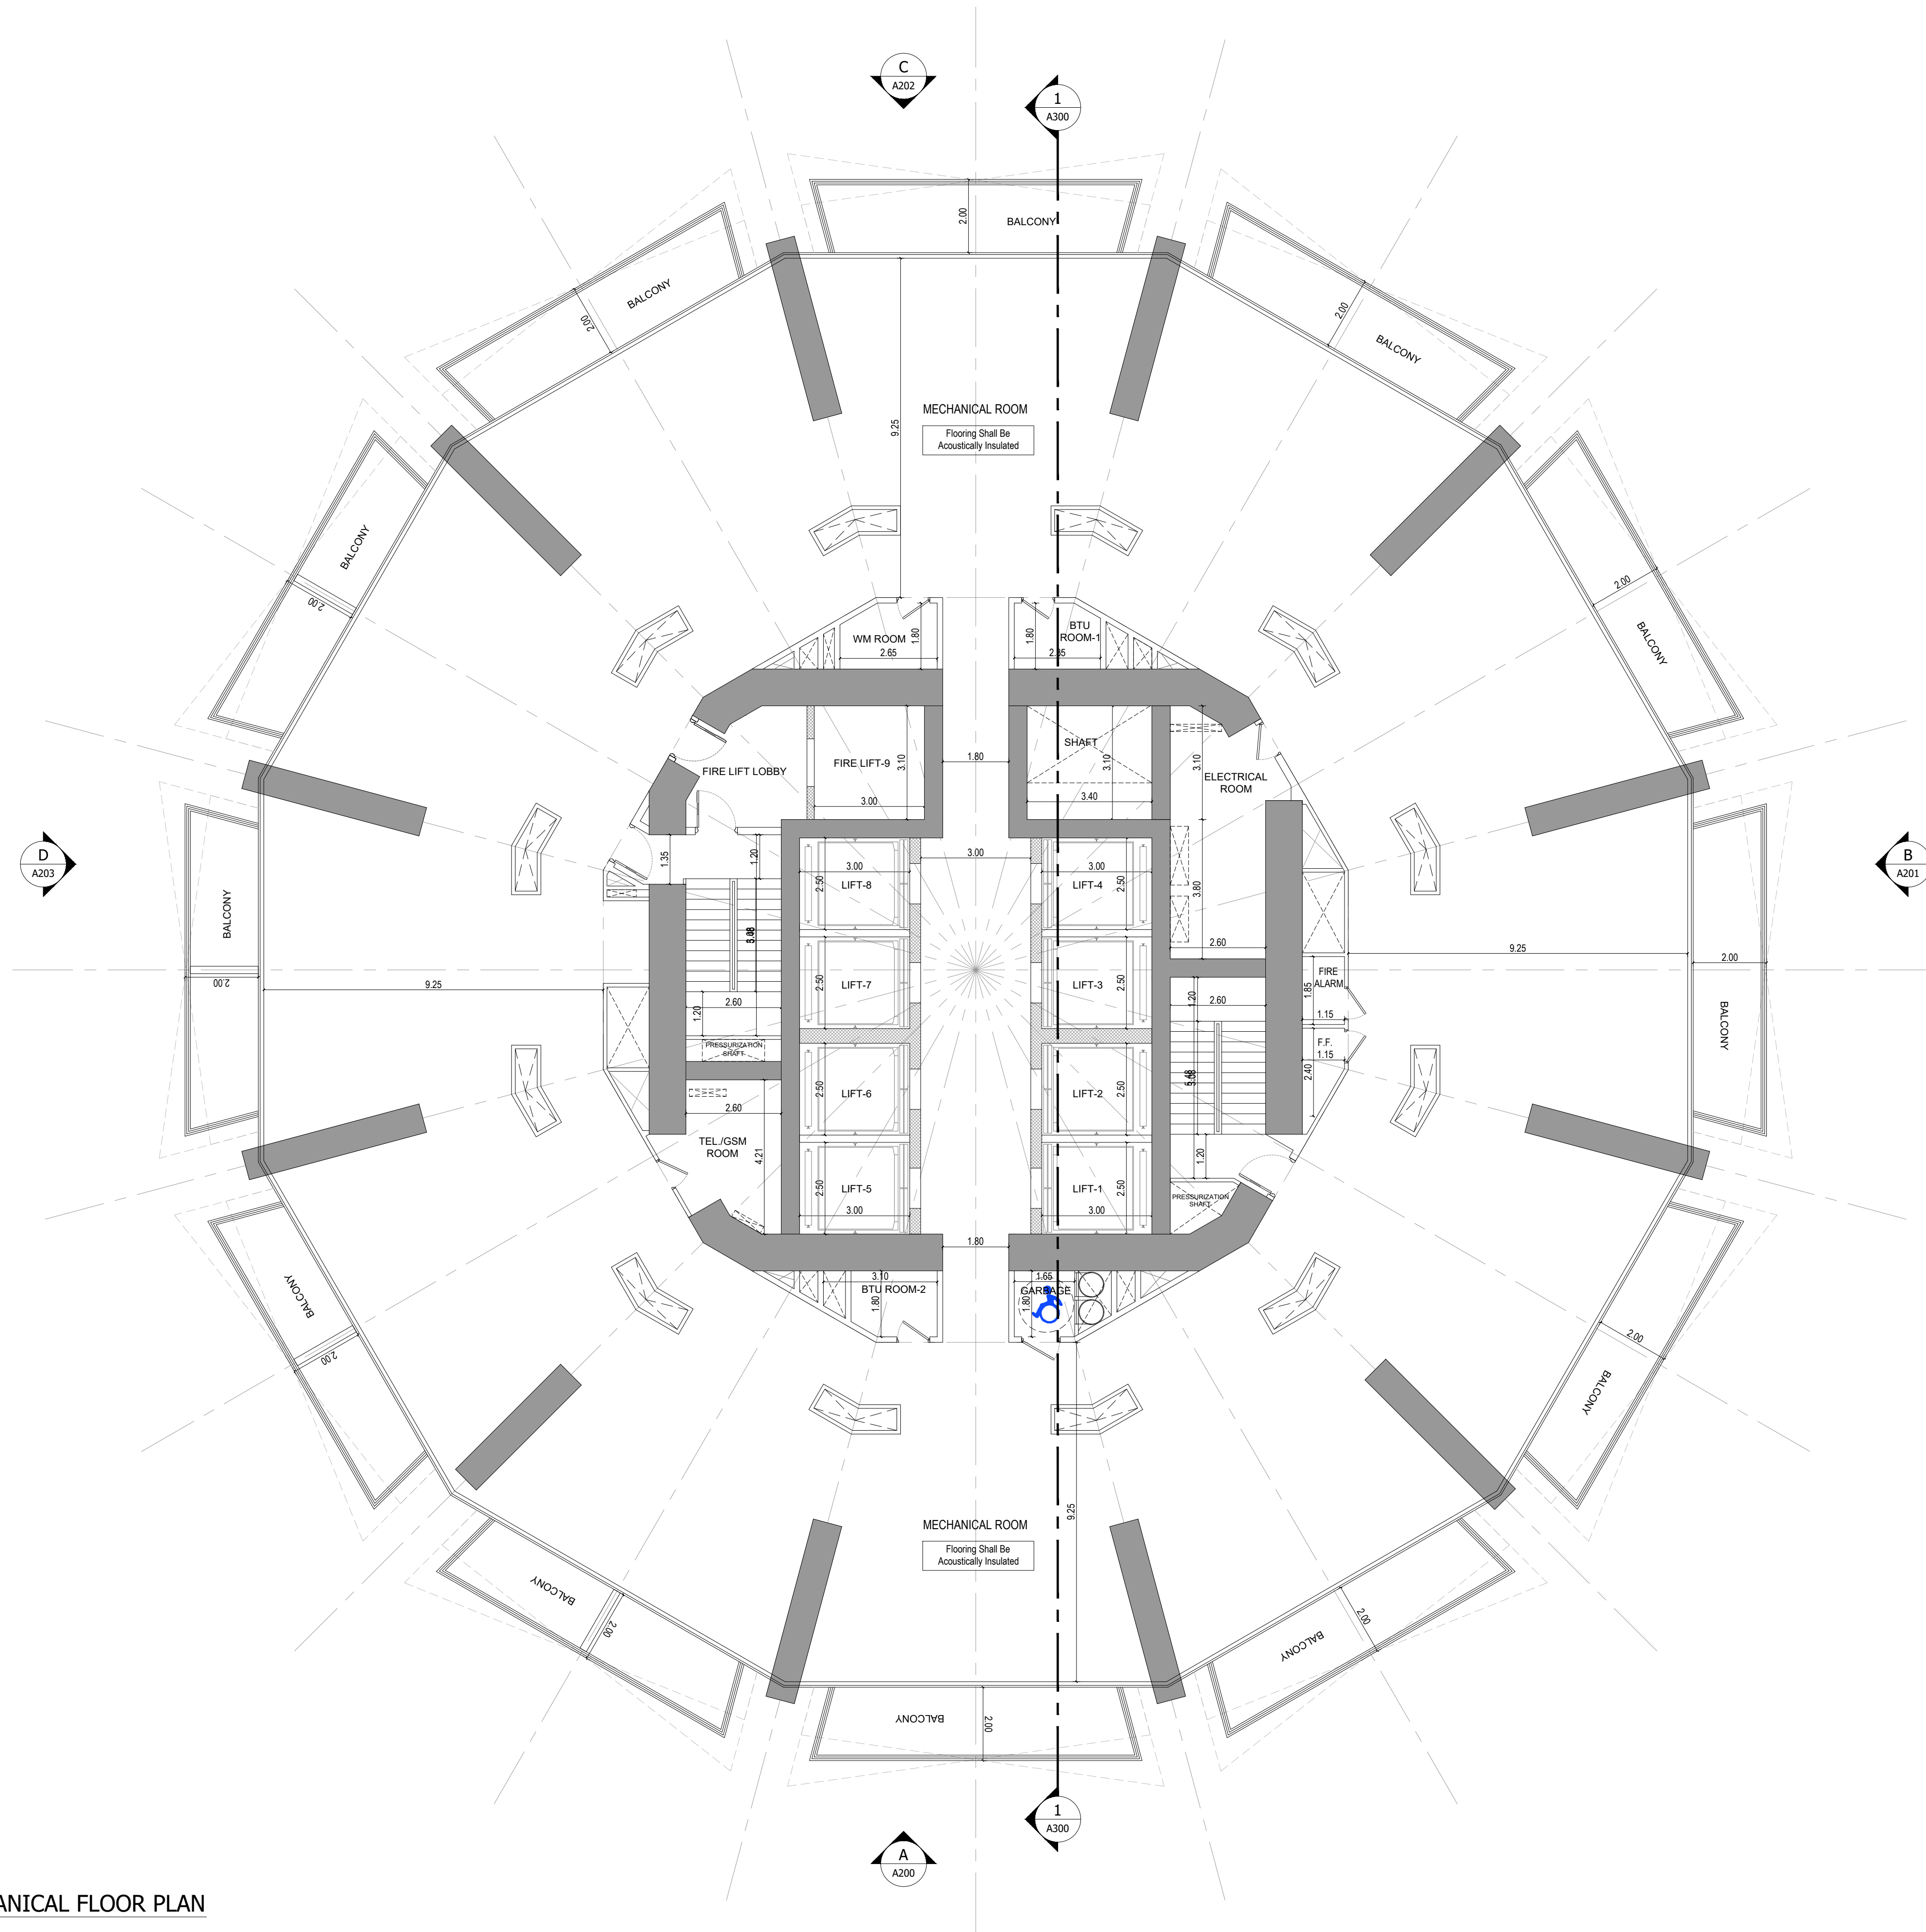

APPROVAL STAMP:

- NOTES:
- 1.) ALL DIMENSIONS TO BE VERIFIED BY CONTRACTOR ON SITE PRIOR TO COMMENCEMENT OF ANY WORK.
 - 2.) DO NOT SCALE THIS DRAWING FOR THE PURPOSE OF MEASUREMENT. ONLY SCALE DIMENSIONS WHERE SPECIFICALLY INSTRUCTED TO DO SO.
 - 3.) ALL MEASUREMENTS ARE IN MILLIMETERS UNLESS OTHERWISE SPECIFIED.
 - 4.) DIMENSIONS SHOWN ON THESE DRAWINGS ARE STRUCTURAL DIMENSIONS UNLESS CLEARLY NOTED OTHERWISE.
 - 5.) THIS DRAWING IS TO BE READ IN CONJUNCTION WITH ALL OTHER DRAWINGS, DETAIL AND SPECIFICATIONS. ANY DISCREPANCY TO BE IMMEDIATELY BROUGHT TO THE ATTENTION OF ARCHITECT PRIOR TO COMMENCING THE WORKS.

KEY PLAN:-

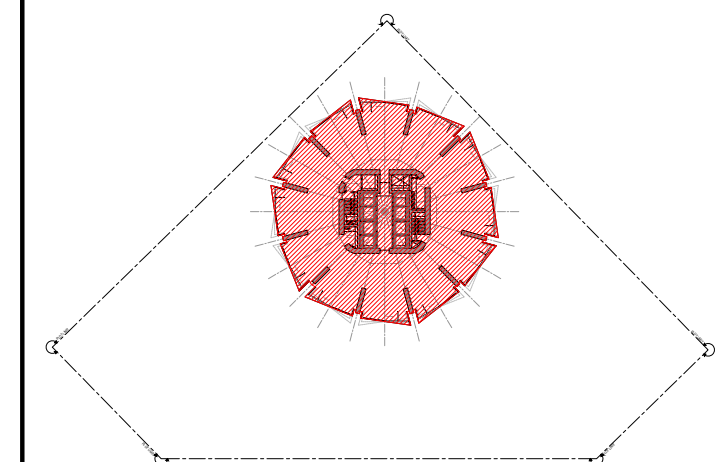

GATE LEVEL PROPOSED = (±0.00 m.) = +15.45 m. DMD LVL.

REV DATE DESCRIPTION CHECK

STATUS:

PRELIMINARY SUBMISSION

OWNER:

ARGENTI PROPERTIES INVESTMENTS LTD

CONSULTANT:



PROJECT :

BINGHATTI CIRCLE

2B + G + 4P + 58 TYP. FLOORS +3 MECH.+3 STR.+ ROOF

PLOT NO: JVC13RHRG001 LOCATION: AL BARSHA SOUTH FOURTH(681)

ARCH: AMAR M STR Engg: M FLAHA

Reg. No: 114763 Reg. No: 109115

SCALE: DRAWN: MUS CHECKED & APPROVED: AM

1:100



DRAWING TITLE:

8TH MECHANICAL FLOOR PLAN

PROJECT NO: DWG NO: REV:

P025-01 A121 00


1 8TH MECHANICAL FLOOR PLAN
A121 SCALE - 1:100

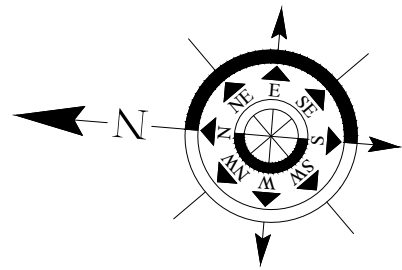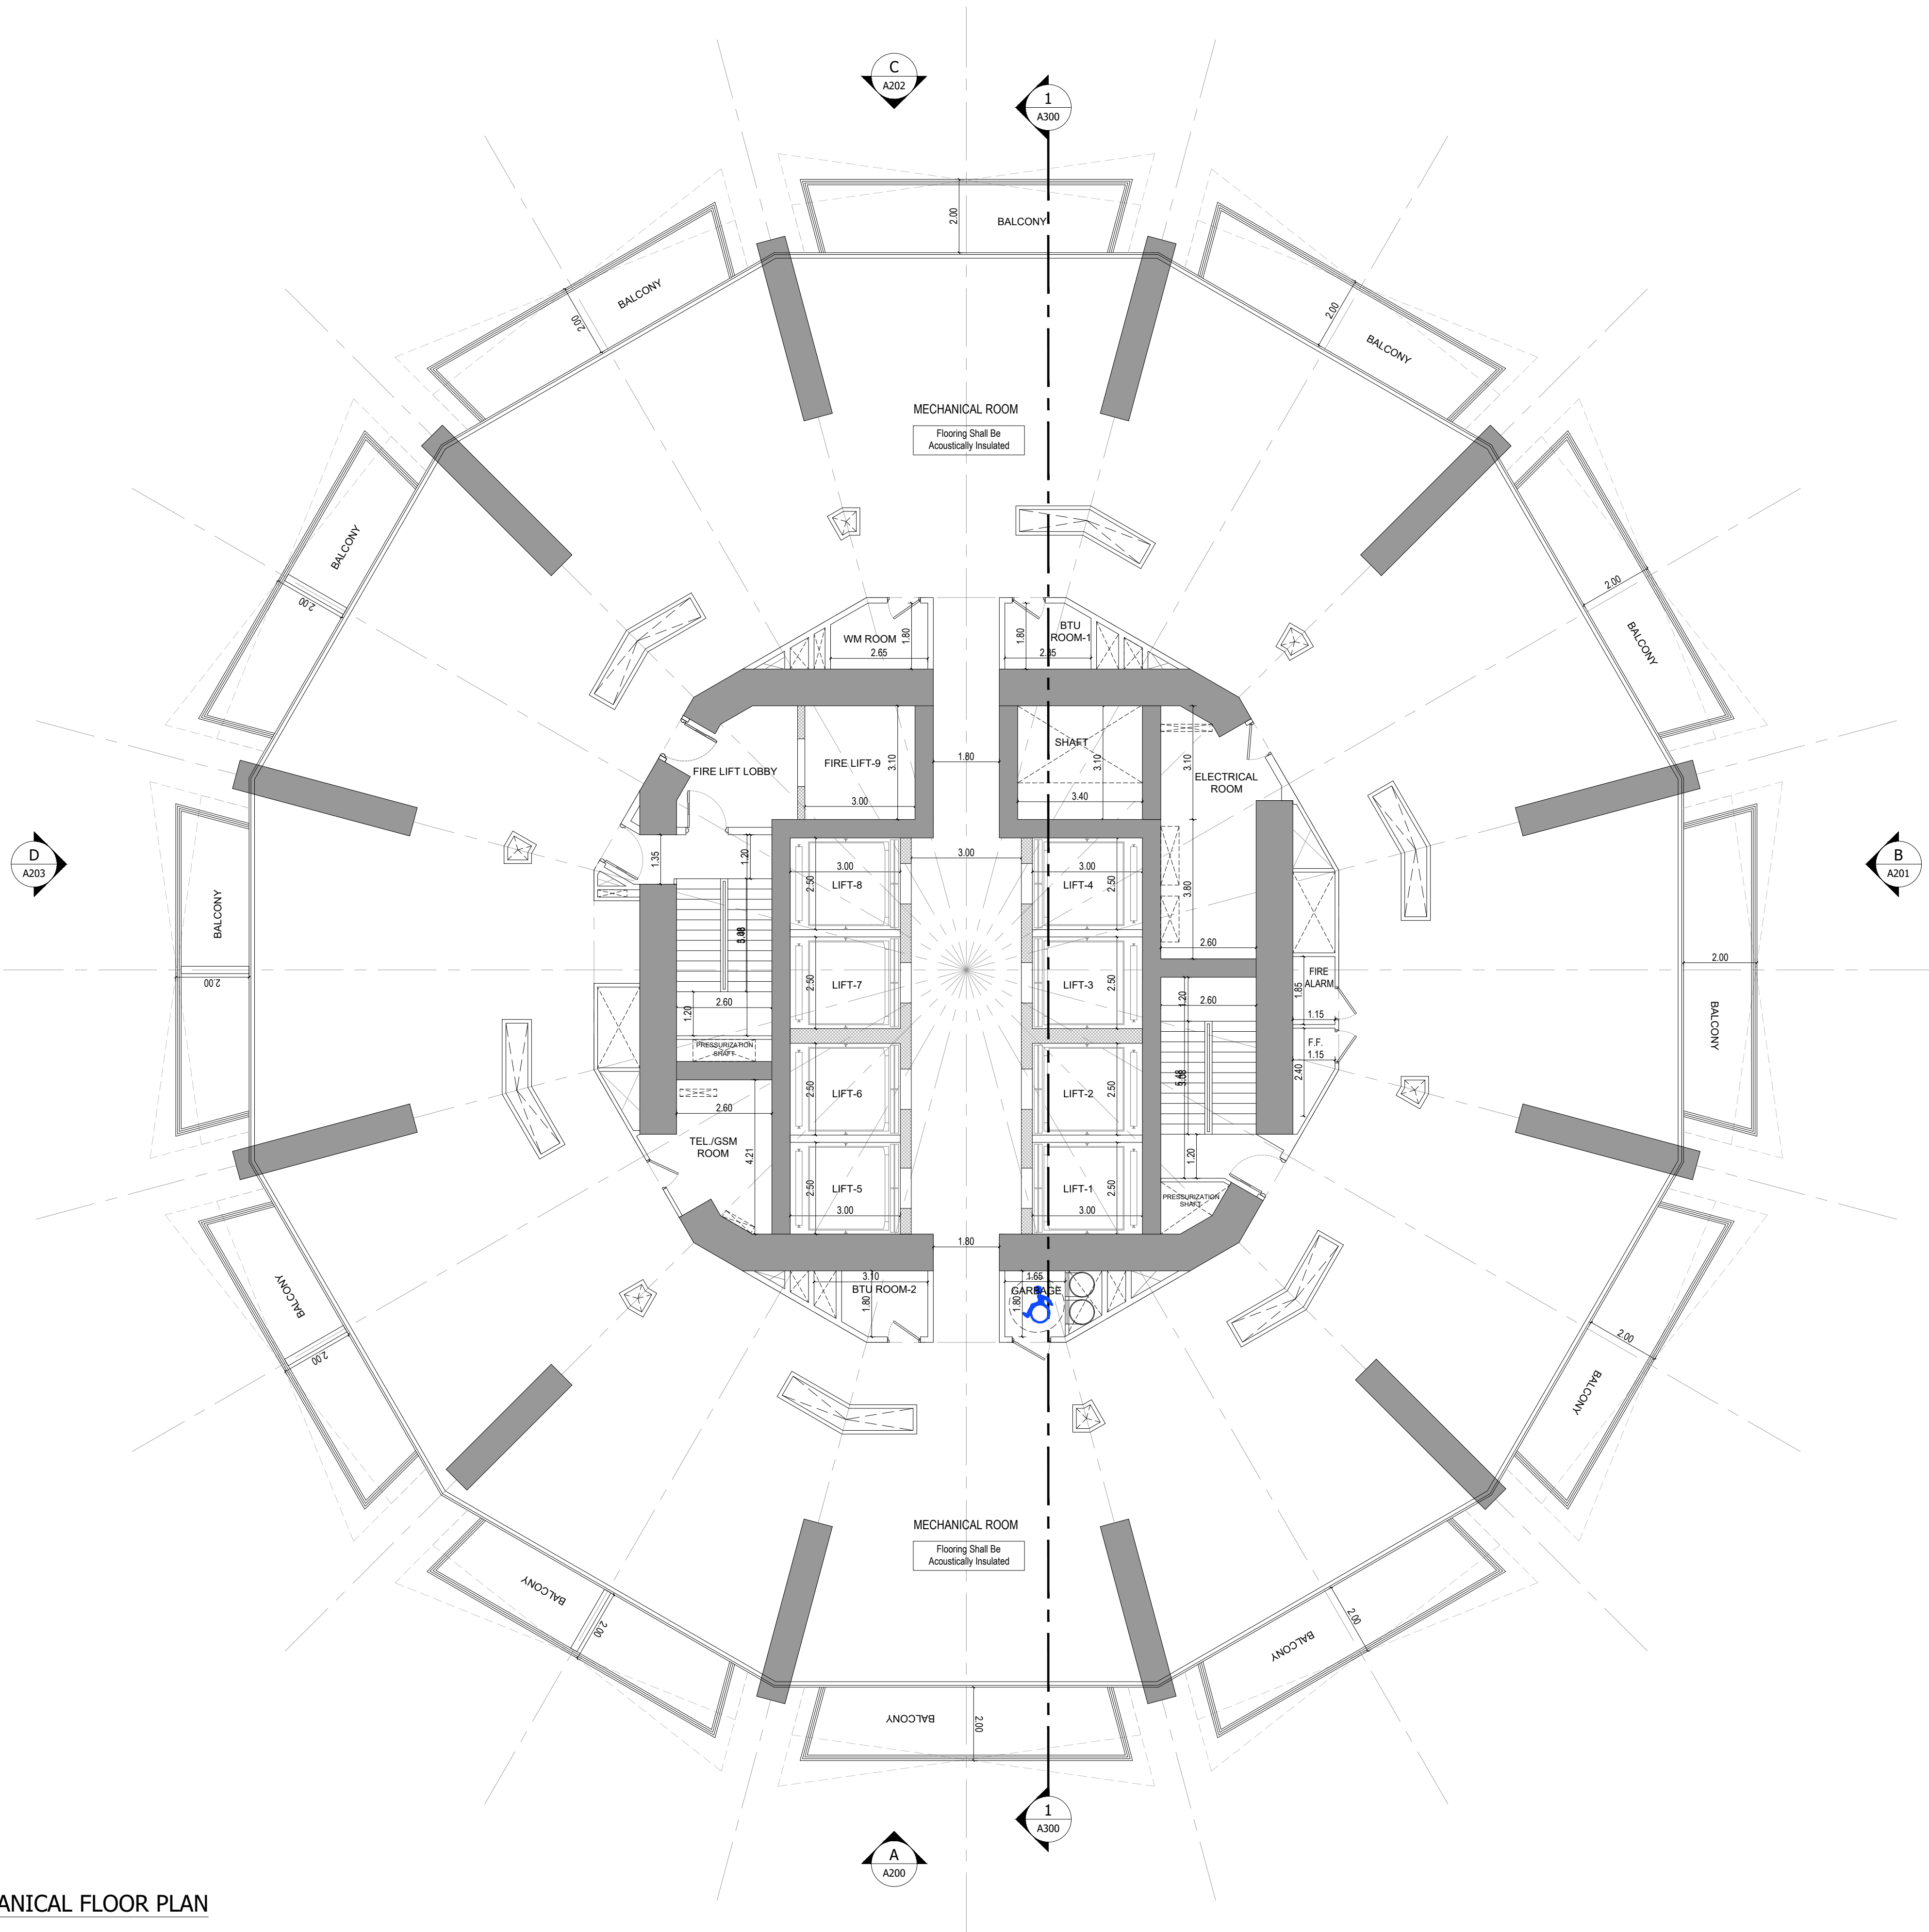

APPROVAL STAMP:

- NOTES:
- 1.) ALL DIMENSIONS TO BE VERIFIED BY CONTRACTOR ON SITE PRIOR TO COMMENCEMENT OF ANY WORK.
 - 2.) DO NOT SCALE THIS DRAWING FOR THE PURPOSE OF MEASUREMENT. ONLY SCALE DIMENSIONS WHERE SPECIFICALLY INSTRUCTED TO DO SO.
 - 3.) ALL MEASUREMENTS ARE IN MILLIMETERS UNLESS OTHERWISE SPECIFIED.
 - 4.) DIMENSIONS SHOWN ON THESE DRAWINGS ARE STRUCTURAL DIMENSIONS UNLESS CLEARLY NOTED OTHERWISE.
 - 5.) THIS DRAWING IS TO BE READ IN CONJUNCTION WITH ALL OTHER DRAWINGS, DETAIL AND SPECIFICATIONS. ANY DISCREPANCY TO BE IMMEDIATELY BROUGHT TO THE ATTENTION OF ARCHITECT PRIOR TO COMMENCING THE WORKS.

KEY PLAN:-

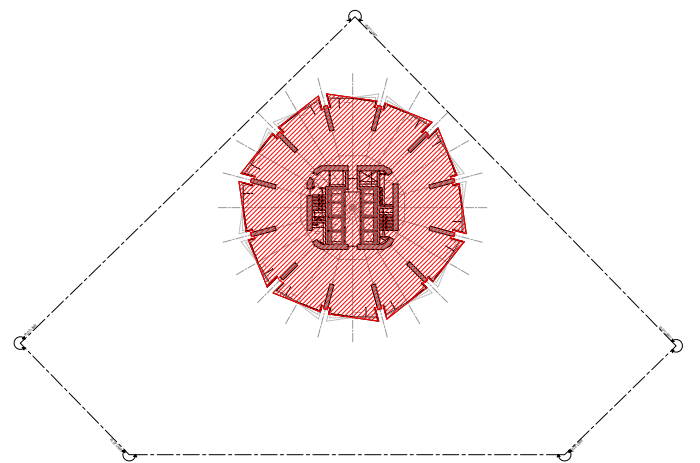

GATE LEVEL PROPOSED = (±0.00 m.) = +15.45 m. DMD LVL.

REV DATE DESCRIPTION CHECK

STATUS:

PRELIMINARY SUBMISSION

OWNER:

ARGENTI PROPERTIES
INVESTMENTS LTD

CONSULTANT:



PROJECT :



BINGHATTI CIRCLE
2B + G + 4P + 5B TYP. FLOORS +3 MECH.+3 STR.+ ROOF

PLOT NO: JVC13RHRG001 LOCATION: AL BARSHA SOUTH FOURTH(681)

ARCH: AMAR M STR Engg: M FLAHA

Reg. No: 114763 Reg. No: 109115



SCALE: 1:100 DRAWN: MUS CHECKED & APPROVED: AM

DRAWING TITLE:

26TH MECHANICAL FLOOR PLAN

PROJECT NO: P025-01 DWG NO: A122 REV: 00


1 26TH MECHANICAL FLOOR PLAN
A122 SCALE - 1:100

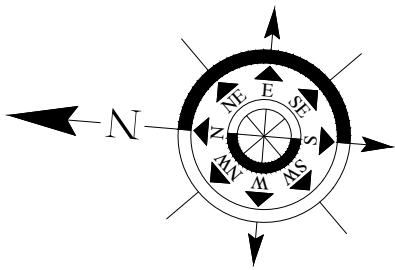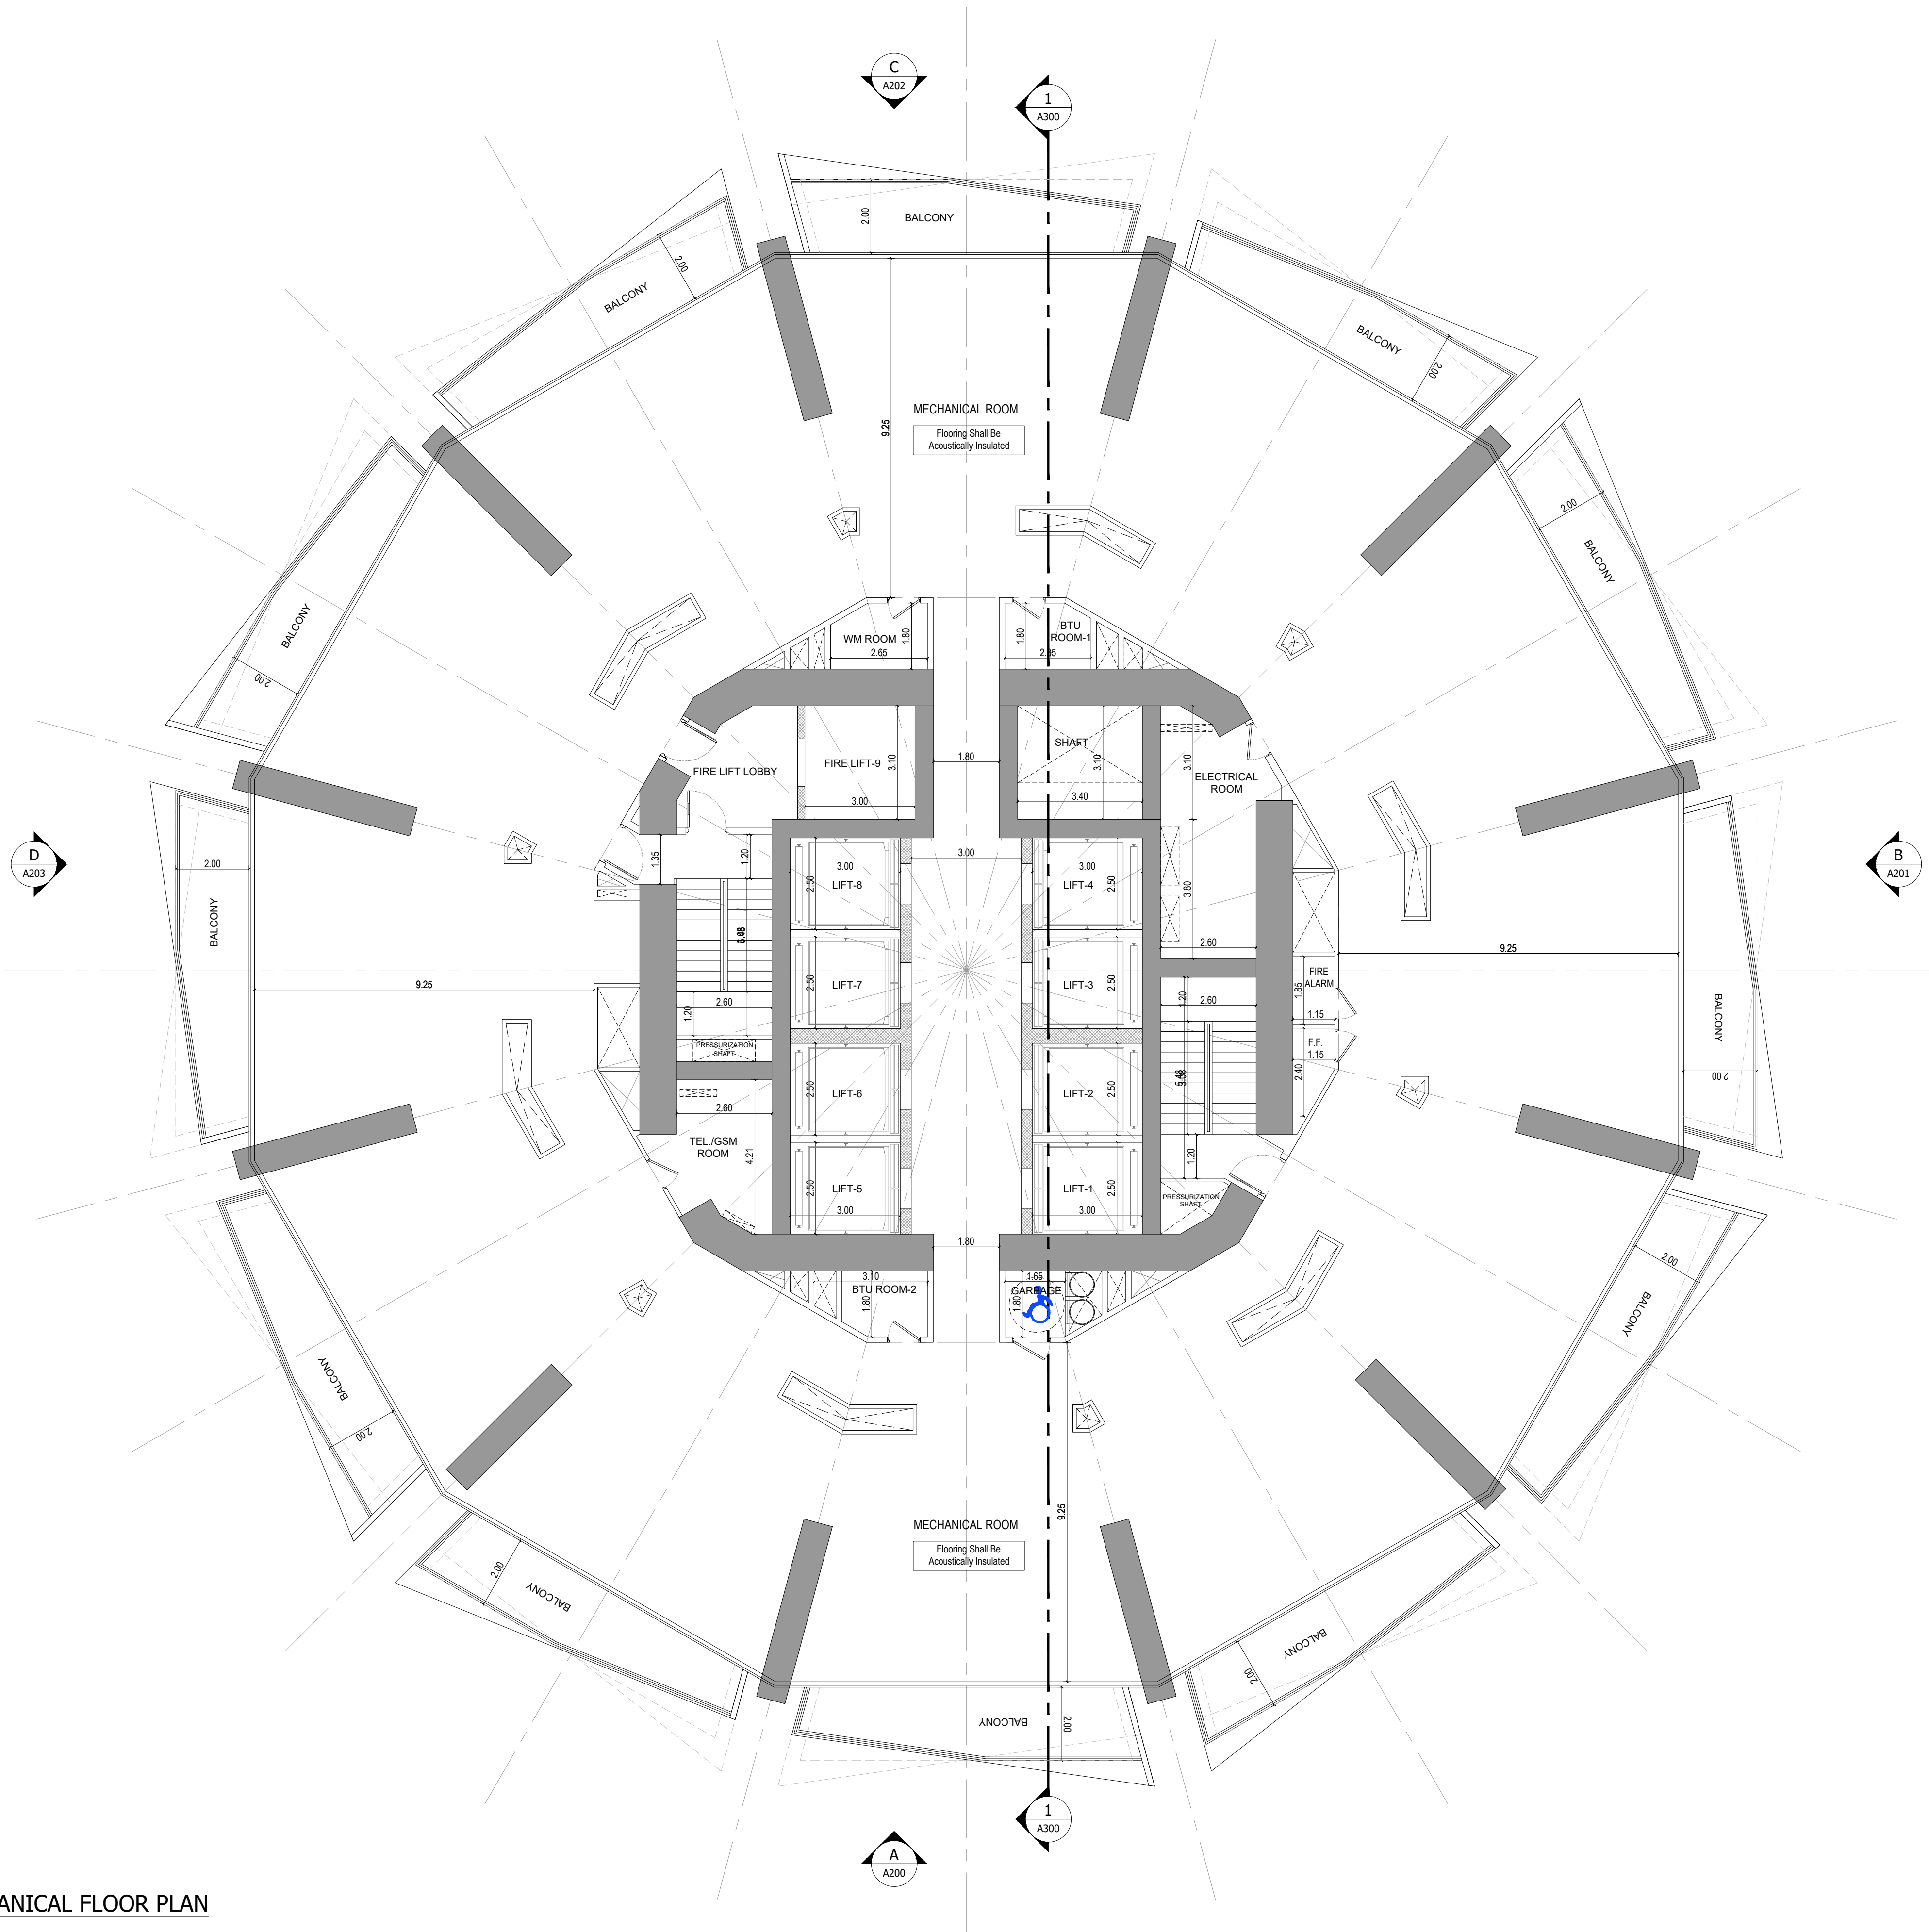

APPROVAL STAMP:

- NOTES:
- 1.) ALL DIMENSIONS TO BE VERIFIED BY CONTRACTOR ON SITE PRIOR TO COMMENCEMENT OF ANY WORK.
 - 2.) DO NOT SCALE THIS DRAWING FOR THE PURPOSE OF MEASUREMENT. ONLY SCALE DIMENSIONS WHERE SPECIFICALLY INSTRUCTED TO DO SO.
 - 3.) ALL MEASUREMENTS ARE IN MILLIMETERS UNLESS OTHERWISE SPECIFIED.
 - 4.) DIMENSIONS SHOWN ON THESE DRAWINGS ARE STRUCTURAL DIMENSIONS UNLESS CLEARLY NOTED OTHERWISE.
 - 5.) THIS DRAWING IS TO BE READ IN CONJUNCTION WITH ALL OTHER DRAWINGS, DETAIL AND SPECIFICATIONS. ANY DISCREPANCY TO BE IMMEDIATELY BROUGHT TO THE ATTENTION OF ARCHITECT PRIOR TO COMMENCING THE WORKS.

KEY PLAN:-

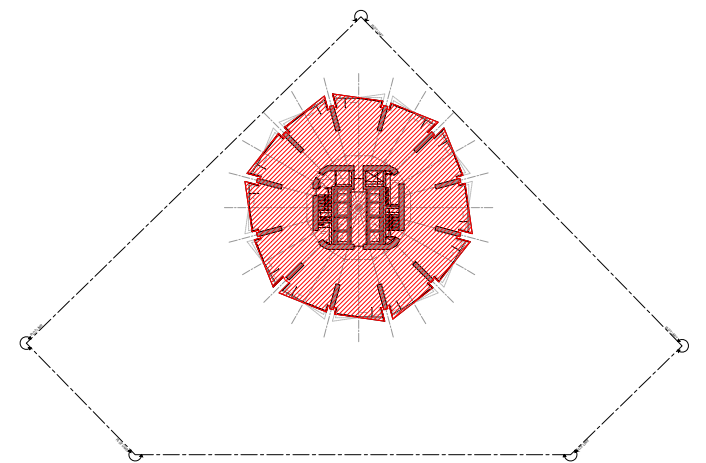

GATE LEVEL PROPOSED = (±0.00 m.) = +15.45 m. DMD LVL.

REV DATE DESCRIPTION CHECK

STATUS:

PRELIMINARY SUBMISSION

OWNER:

ARGENTI PROPERTIES INVESTMENTS LTD

CONSULTANT:



PROJECT:



BINGHATTI CIRCLE

2B + G + 4P + 58 TYP. FLOORS +3 MECH.+3 STR.+ ROOF

PLOT NO: JVC13RHRG001 LOCATION: AL BARSHA SOUTH FOURTH(681)

ARCH: AMAR M STR Engg: M FLAHA

Reg. No: 114763 Reg. No: 109115

SCALE: DRAWN: MUS CHECKED & APPROVED: AM

1:100

DRAWING TITLE:

45TH MECHANICAL FLOOR PLAN

PROJECT NO: DWG NO: REV:

P025-01 A123 00


1

A123

45TH MECHANICAL FLOOR PLAN

SCALE - 1:100


File Path: X:\Binghatti Project\PO25-01-Binghatti Circle\01- ARCHITECTURE\01- CONCEPT\01- DWG- Print Date: 12-Jun-25, Time: 10:23:34 AM

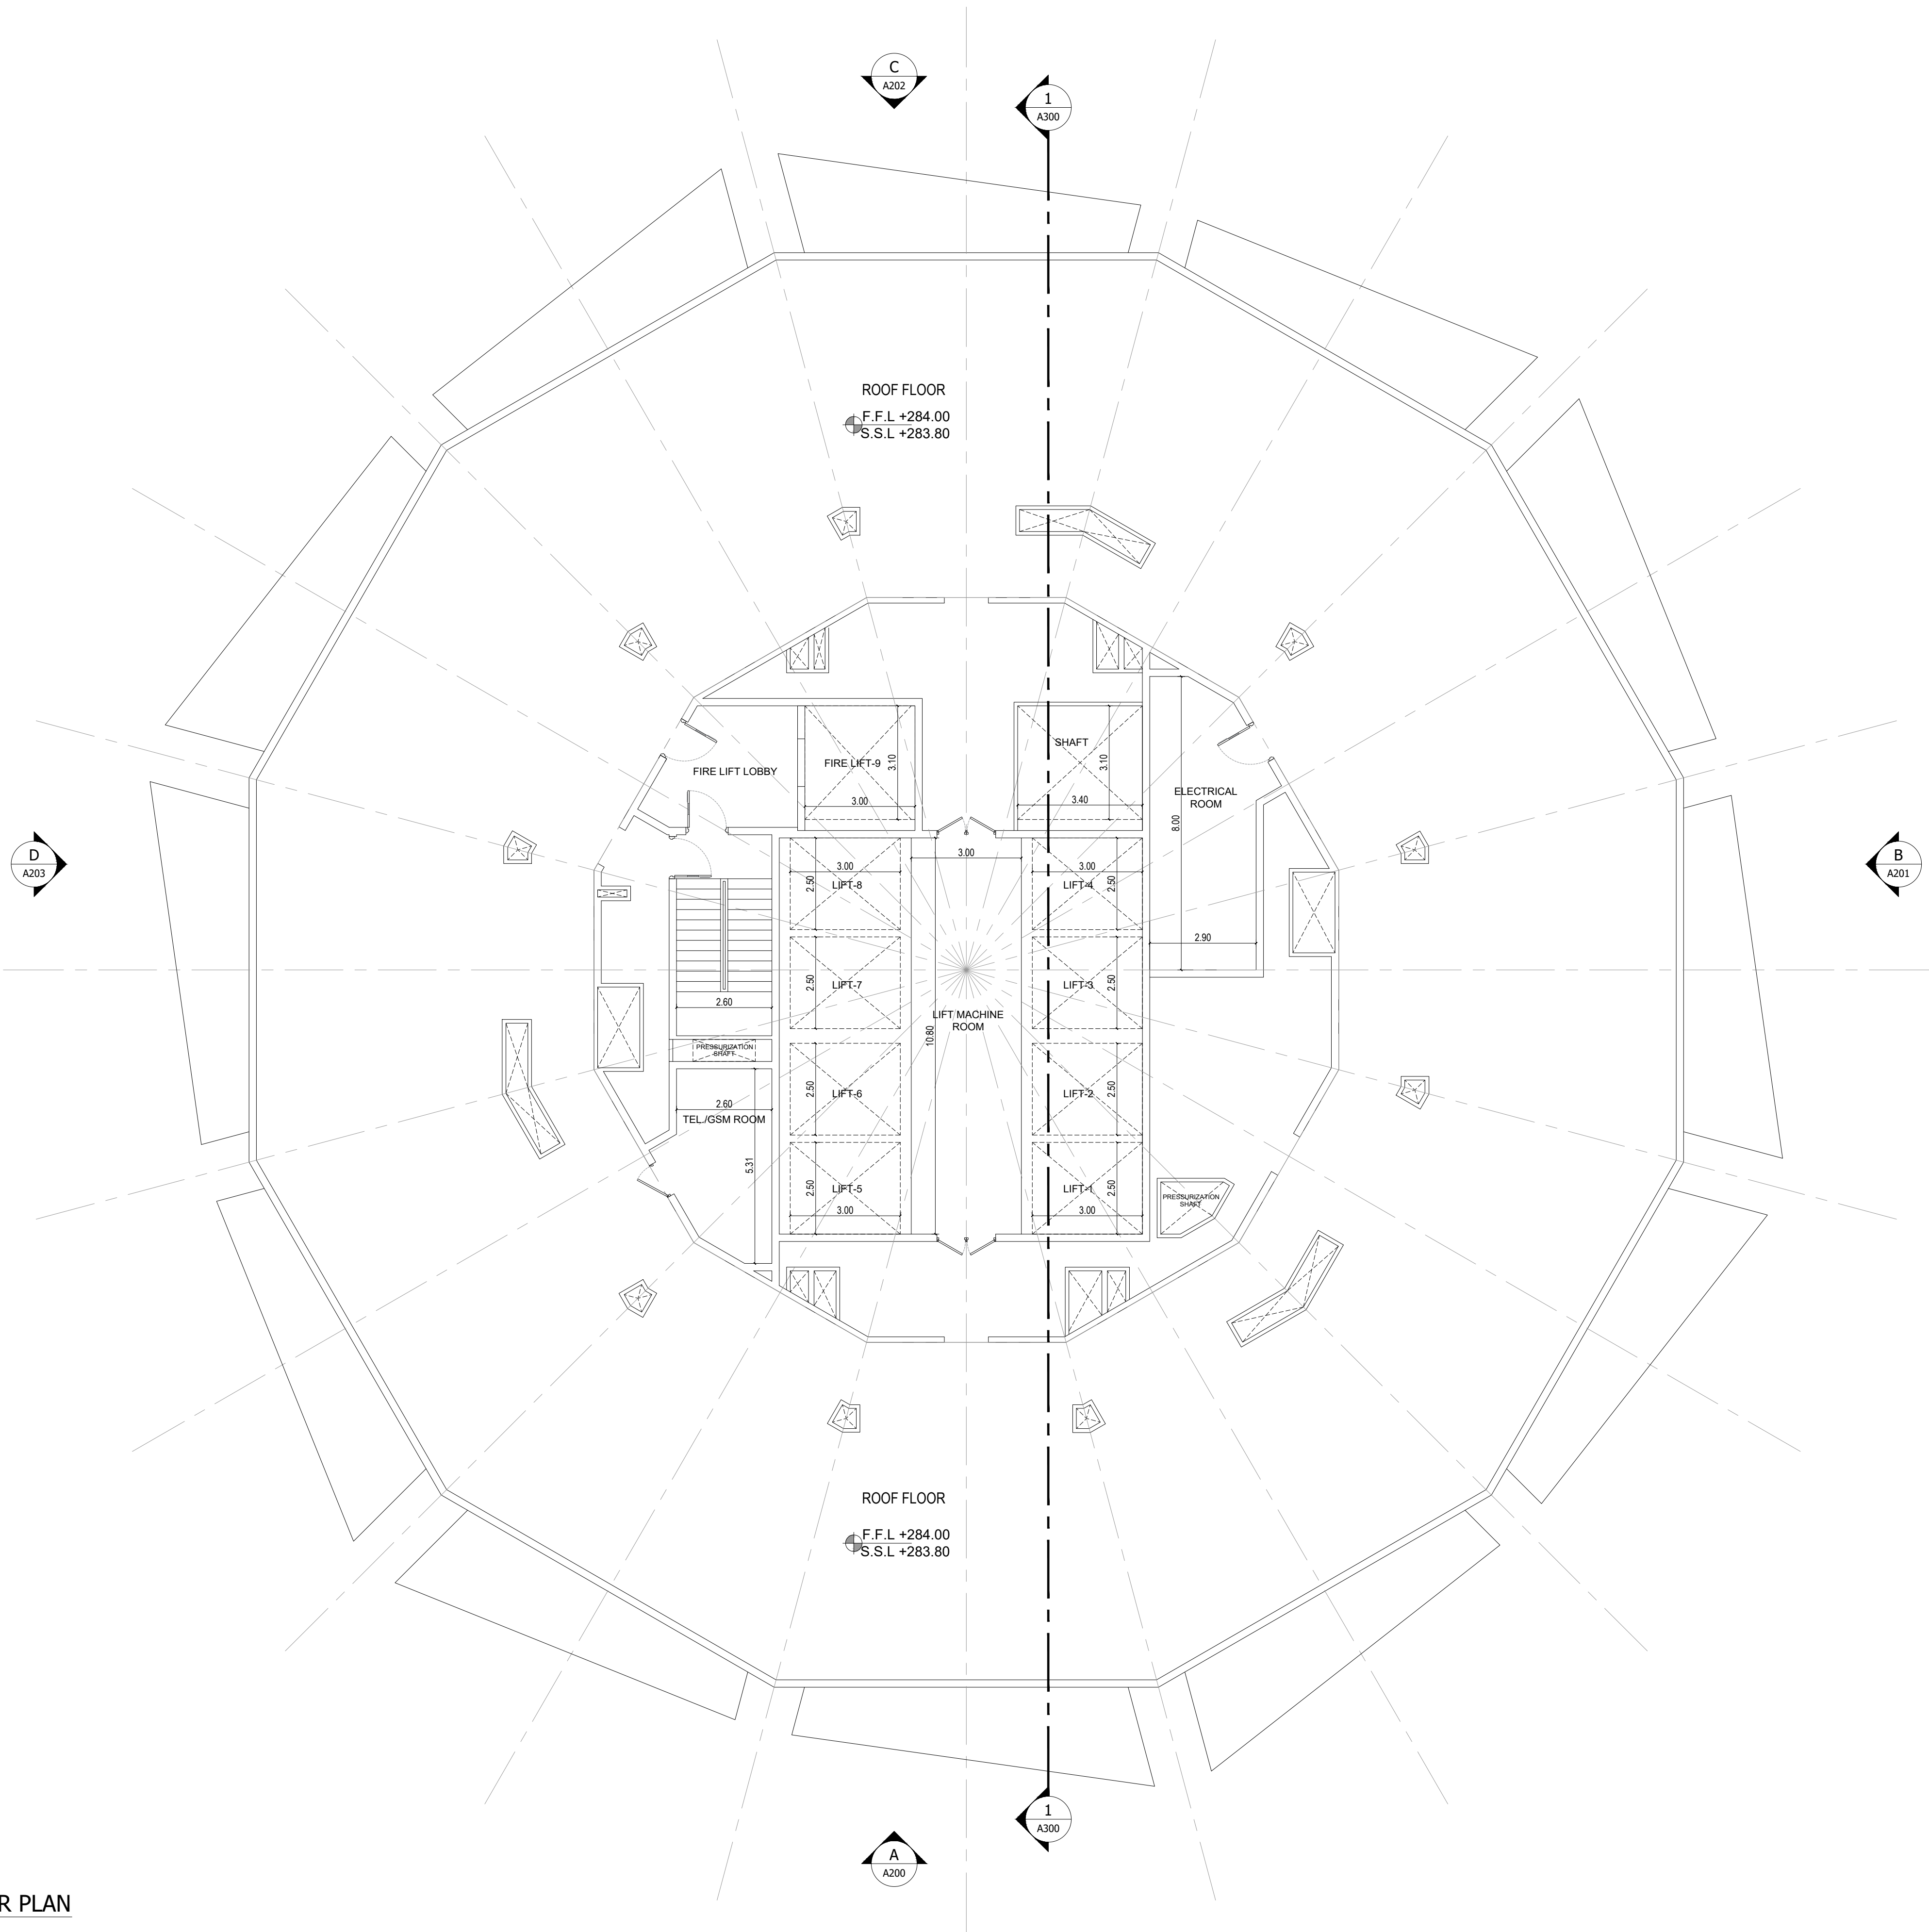

APPROVAL STAMP:

NOTES:

- 1.) ALL DIMENSIONS TO BE VERIFIED BY CONTRACTOR ON SITE PRIOR TO COMMENCEMENT OF ANY WORK.
- 2.) DO NOT SCALE THIS DRAWING FOR THE PURPOSE OF MEASUREMENT. ONLY SCALE DIMENSIONS WHERE SPECIFICALLY INSTRUCTED TO DO SO.
- 3.) ALL MEASUREMENTS ARE IN MILLIMETERS UNLESS OTHERWISE SPECIFIED.
- 4.) DIMENSIONS SHOWN ON THESE DRAWINGS ARE STRUCTURAL DIMENSIONS UNLESS CLEARLY NOTED OTHERWISE.
- 5.) THIS DRAWING IS TO BE READ IN CONJUNCTION WITH ALL OTHER DRAWINGS, DETAIL AND SPECIFICATIONS. ANY DISCREPANCY TO BE IMMEDIATELY BROUGHT TO THE ATTENTION OF ARCHITECT PRIOR TO COMMENCING THE WORKS.

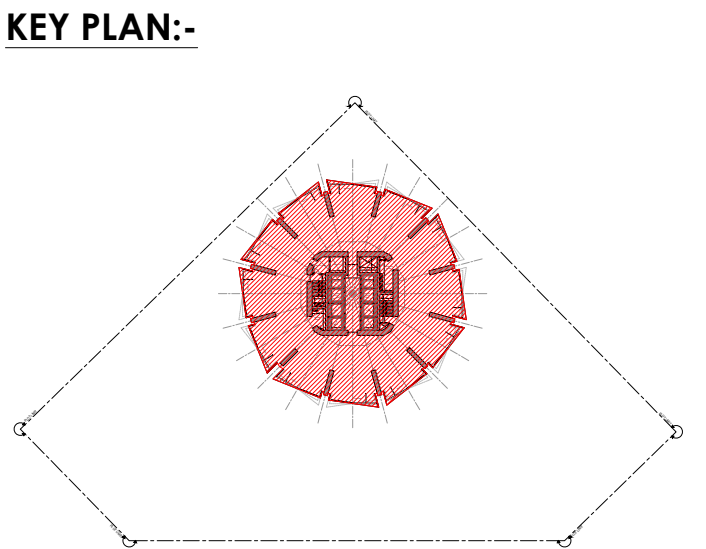

GATE LEVEL PROPOSED = (±0.00 m.) = +15.45 m. DMD LVL.

REV	DATE	DESCRIPTION	CHECK

STATUS : PRELIMINARY SUBMISSION

OWNER: ARGENTI PROPERTIES INVESTMENTS LTD



CONSULTANT: SILVER STONE ENGINEERING CONSULTANTS

PROJECT : BINGHATTI CIRCLE
2B + G + 4P + S8 TYP. FLOORS +3 MECH.+3 STR.+ ROOF

PLOT NO: JVC13RHRG001	LOCATION: AL BARSHA SOUTH FOURTH(681)
ARCH: AMAR M	STR Engg: M FLAHA
Reg. No: 114763	Reg. No: 109115
SCALE:	DRAWN: MUS
CHECKED & APPROVED: AM	

DRAWING TITLE: ROOF FLOOR PLAN


PROJECT NO: P025-01	DWG NO: A124	REV: 00
-------------------------------	------------------------	-------------------

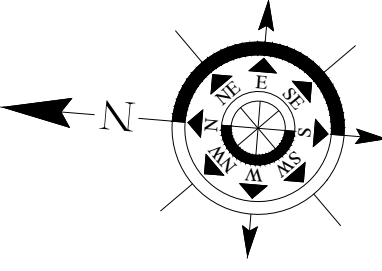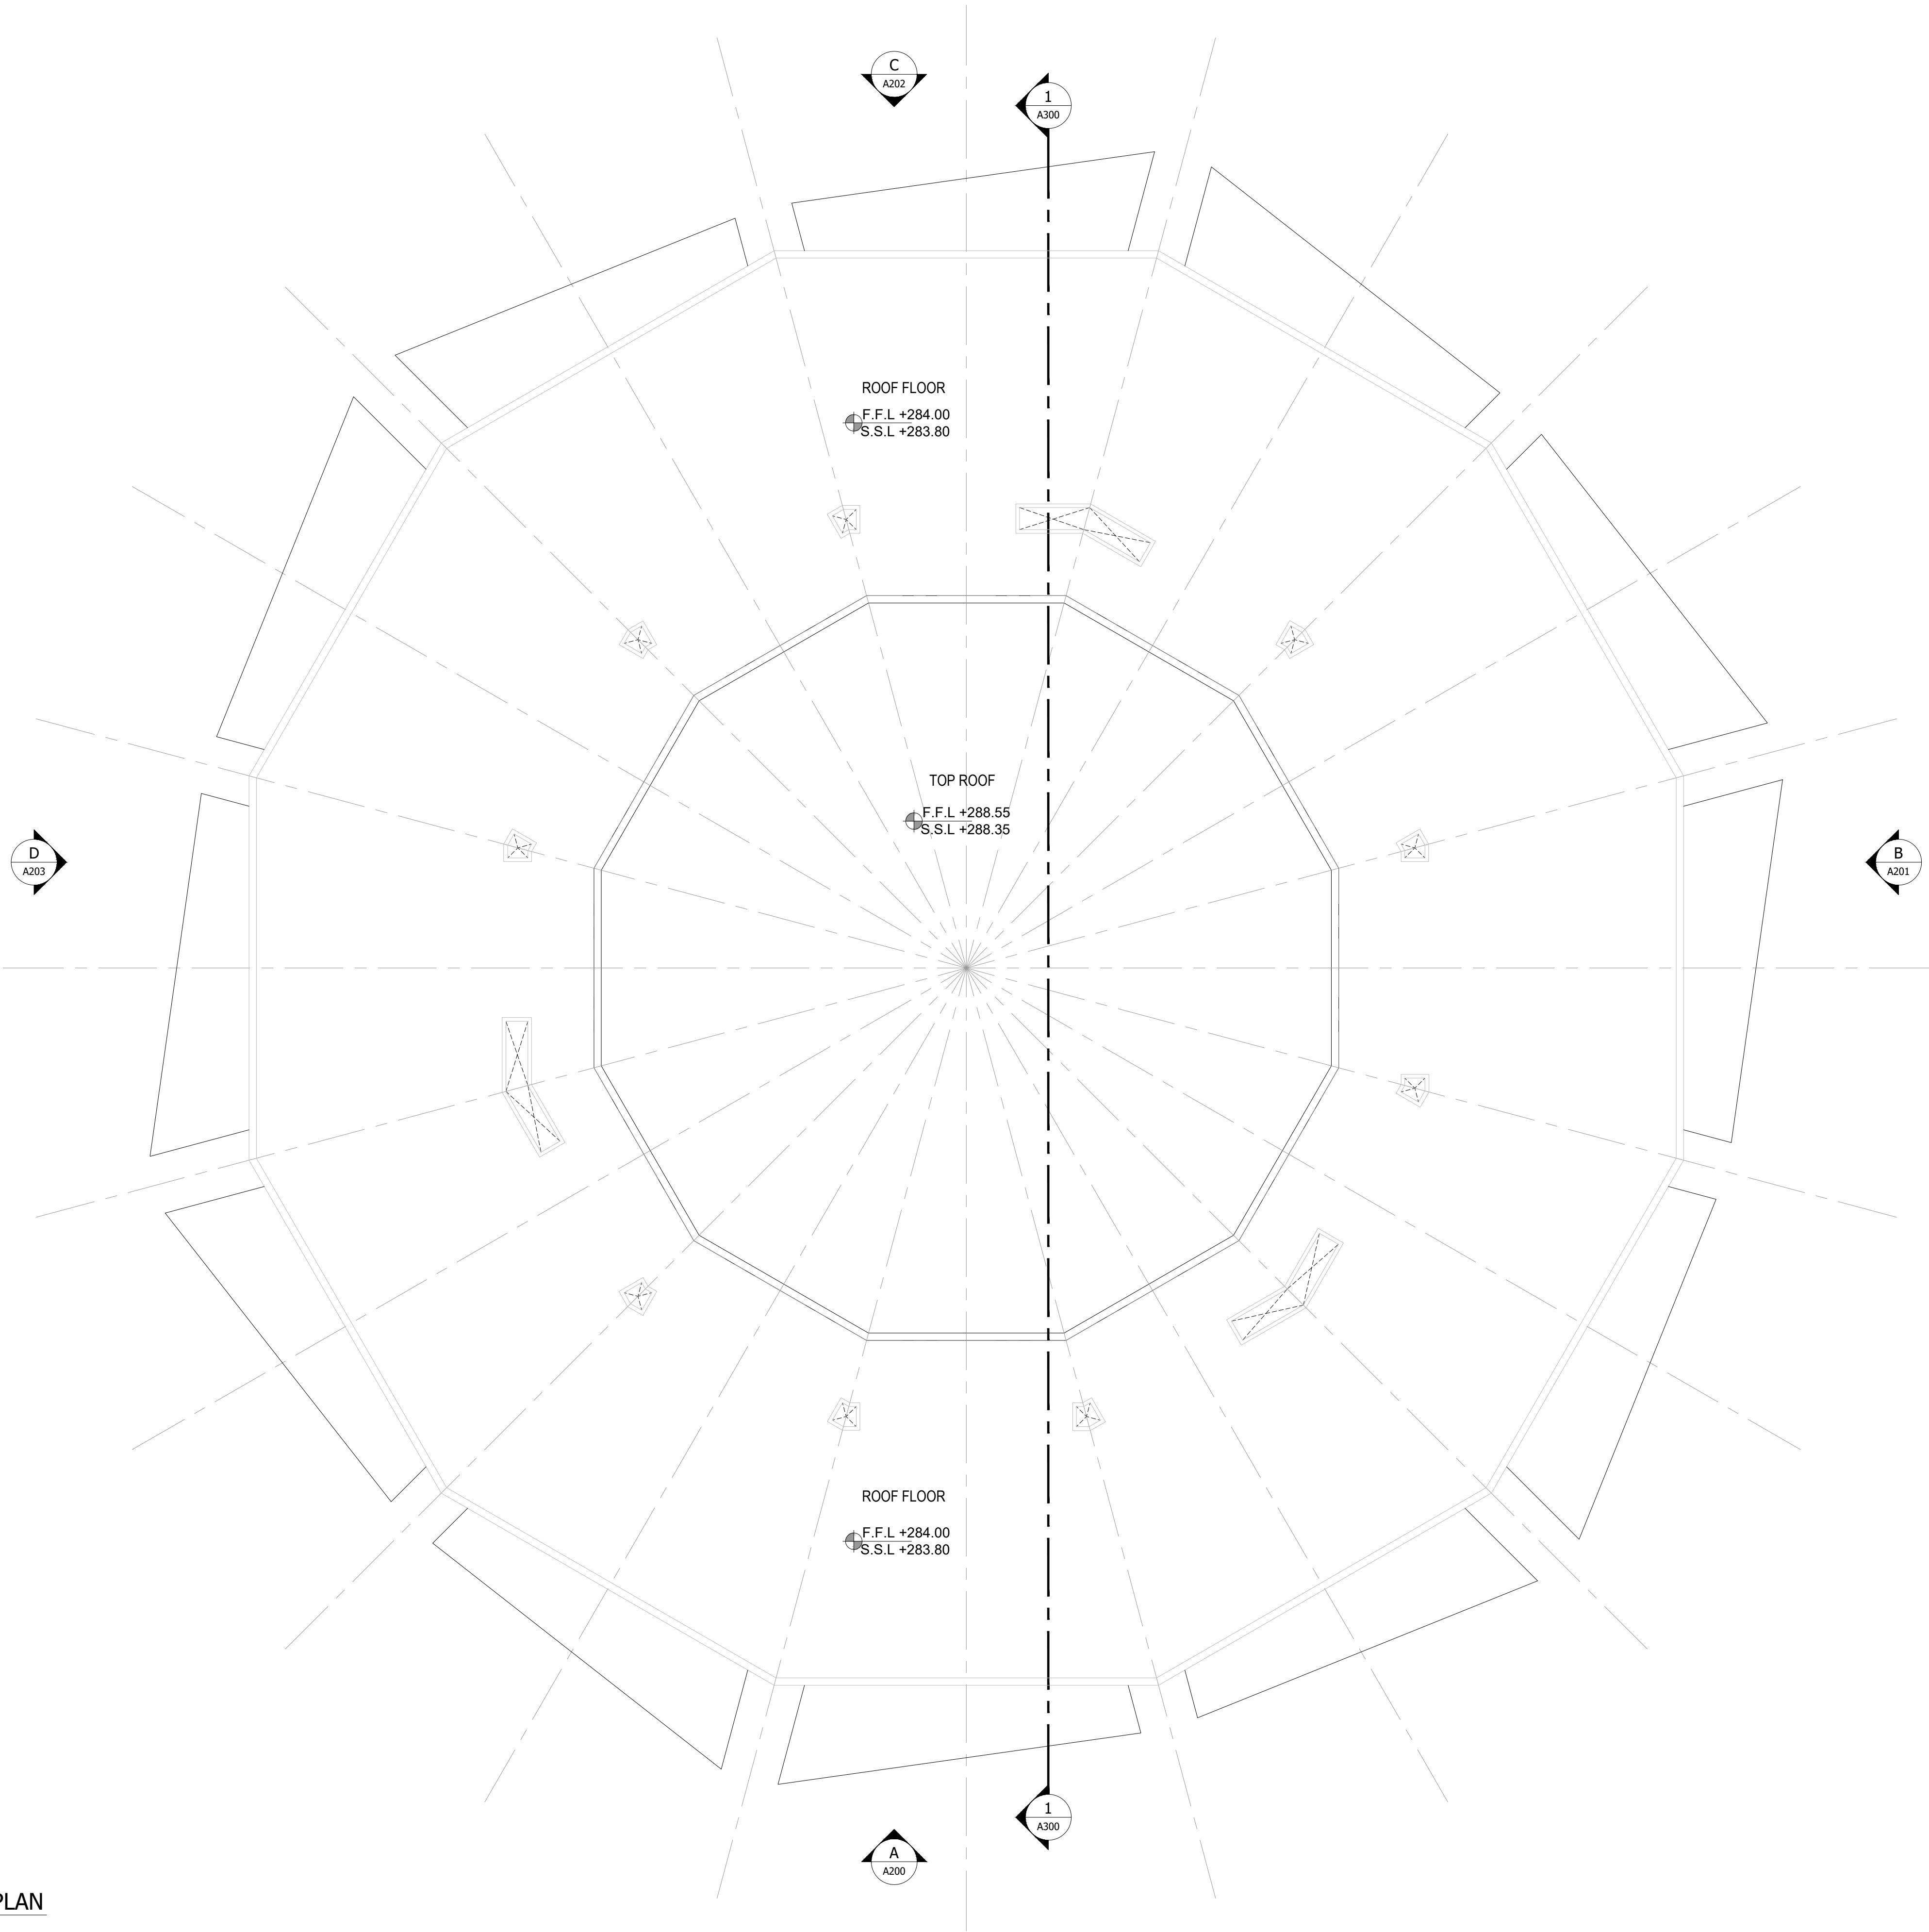

APPROVAL STAMP:

- NOTES:
- 1.) ALL DIMENSIONS TO BE VERIFIED BY CONTRACTOR ON SITE PRIOR TO COMMENCEMENT OF ANY WORK.
 - 2.) DO NOT SCALE THIS DRAWING FOR THE PURPOSE OF MEASUREMENT. ONLY SCALE DIMENSIONS WHERE SPECIFICALLY INSTRUCTED TO DO SO.
 - 3.) ALL MEASUREMENTS ARE IN MILLIMETERS UNLESS OTHERWISE SPECIFIED.
 - 4.) DIMENSIONS SHOWN ON THESE DRAWINGS ARE STRUCTURAL DIMENSIONS UNLESS CLEARLY NOTED OTHERWISE.
 - 5.) THIS DRAWING IS TO BE READ IN CONJUNCTION WITH ALL OTHER DRAWINGS. DETAIL AND SPECIFICATIONS. ANY DISCREPANCY TO BE IMMEDIATELY BROUGHT TO THE ATTENTION OF ARCHITECT PRIOR TO COMMENCING THE WORKS.

KEY PLAN:-

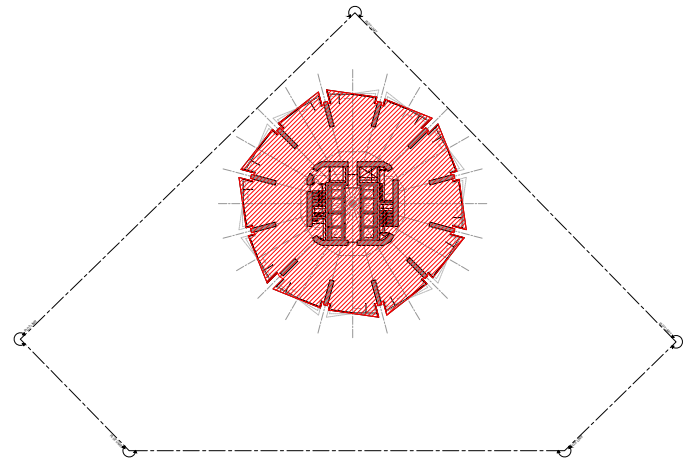

GATE LEVEL PROPOSED = (±0.00 m.) = +15.45 m. DMD LVL.

REV	DATE	DESCRIPTION	CHECK

STATUS :
PRELIMINARY SUBMISSION

OWNER:
ARGENTI PROPERTIES INVESTMENTS LTD

CONSULTANT:
SILVER STONE ENGINEERING CONSULTANTS

PROJECT :
BINGHATTI CIRCLE

PLOT NO: **JVC13RHRG001**
LOCATION: **AL BARSHA SOUTH FOURTH(681)**
ARCH: **AMAR M** STR Engg: **M FLAHA**
Reg. No: **114763** Reg. No: **109115**
SCALE: **1:100** DRAWN: **MUS** CHECKED & APPROVED: **AM**

DRAWING TITLE:
TOP ROOF PLAN

PROJECT NO: **P025-01** DWG NO: **A125** REV: **00**

1 TOP ROOF PLAN
A125 SCALE - 1:100

File Path: X:\Binghatti Project\025-01-Binghatti Circle\01- ARCHITECTURE\01- CONCEPT\01- DWG- Prit Date: 12-Jun-25, Time: 10:23:34 AM